


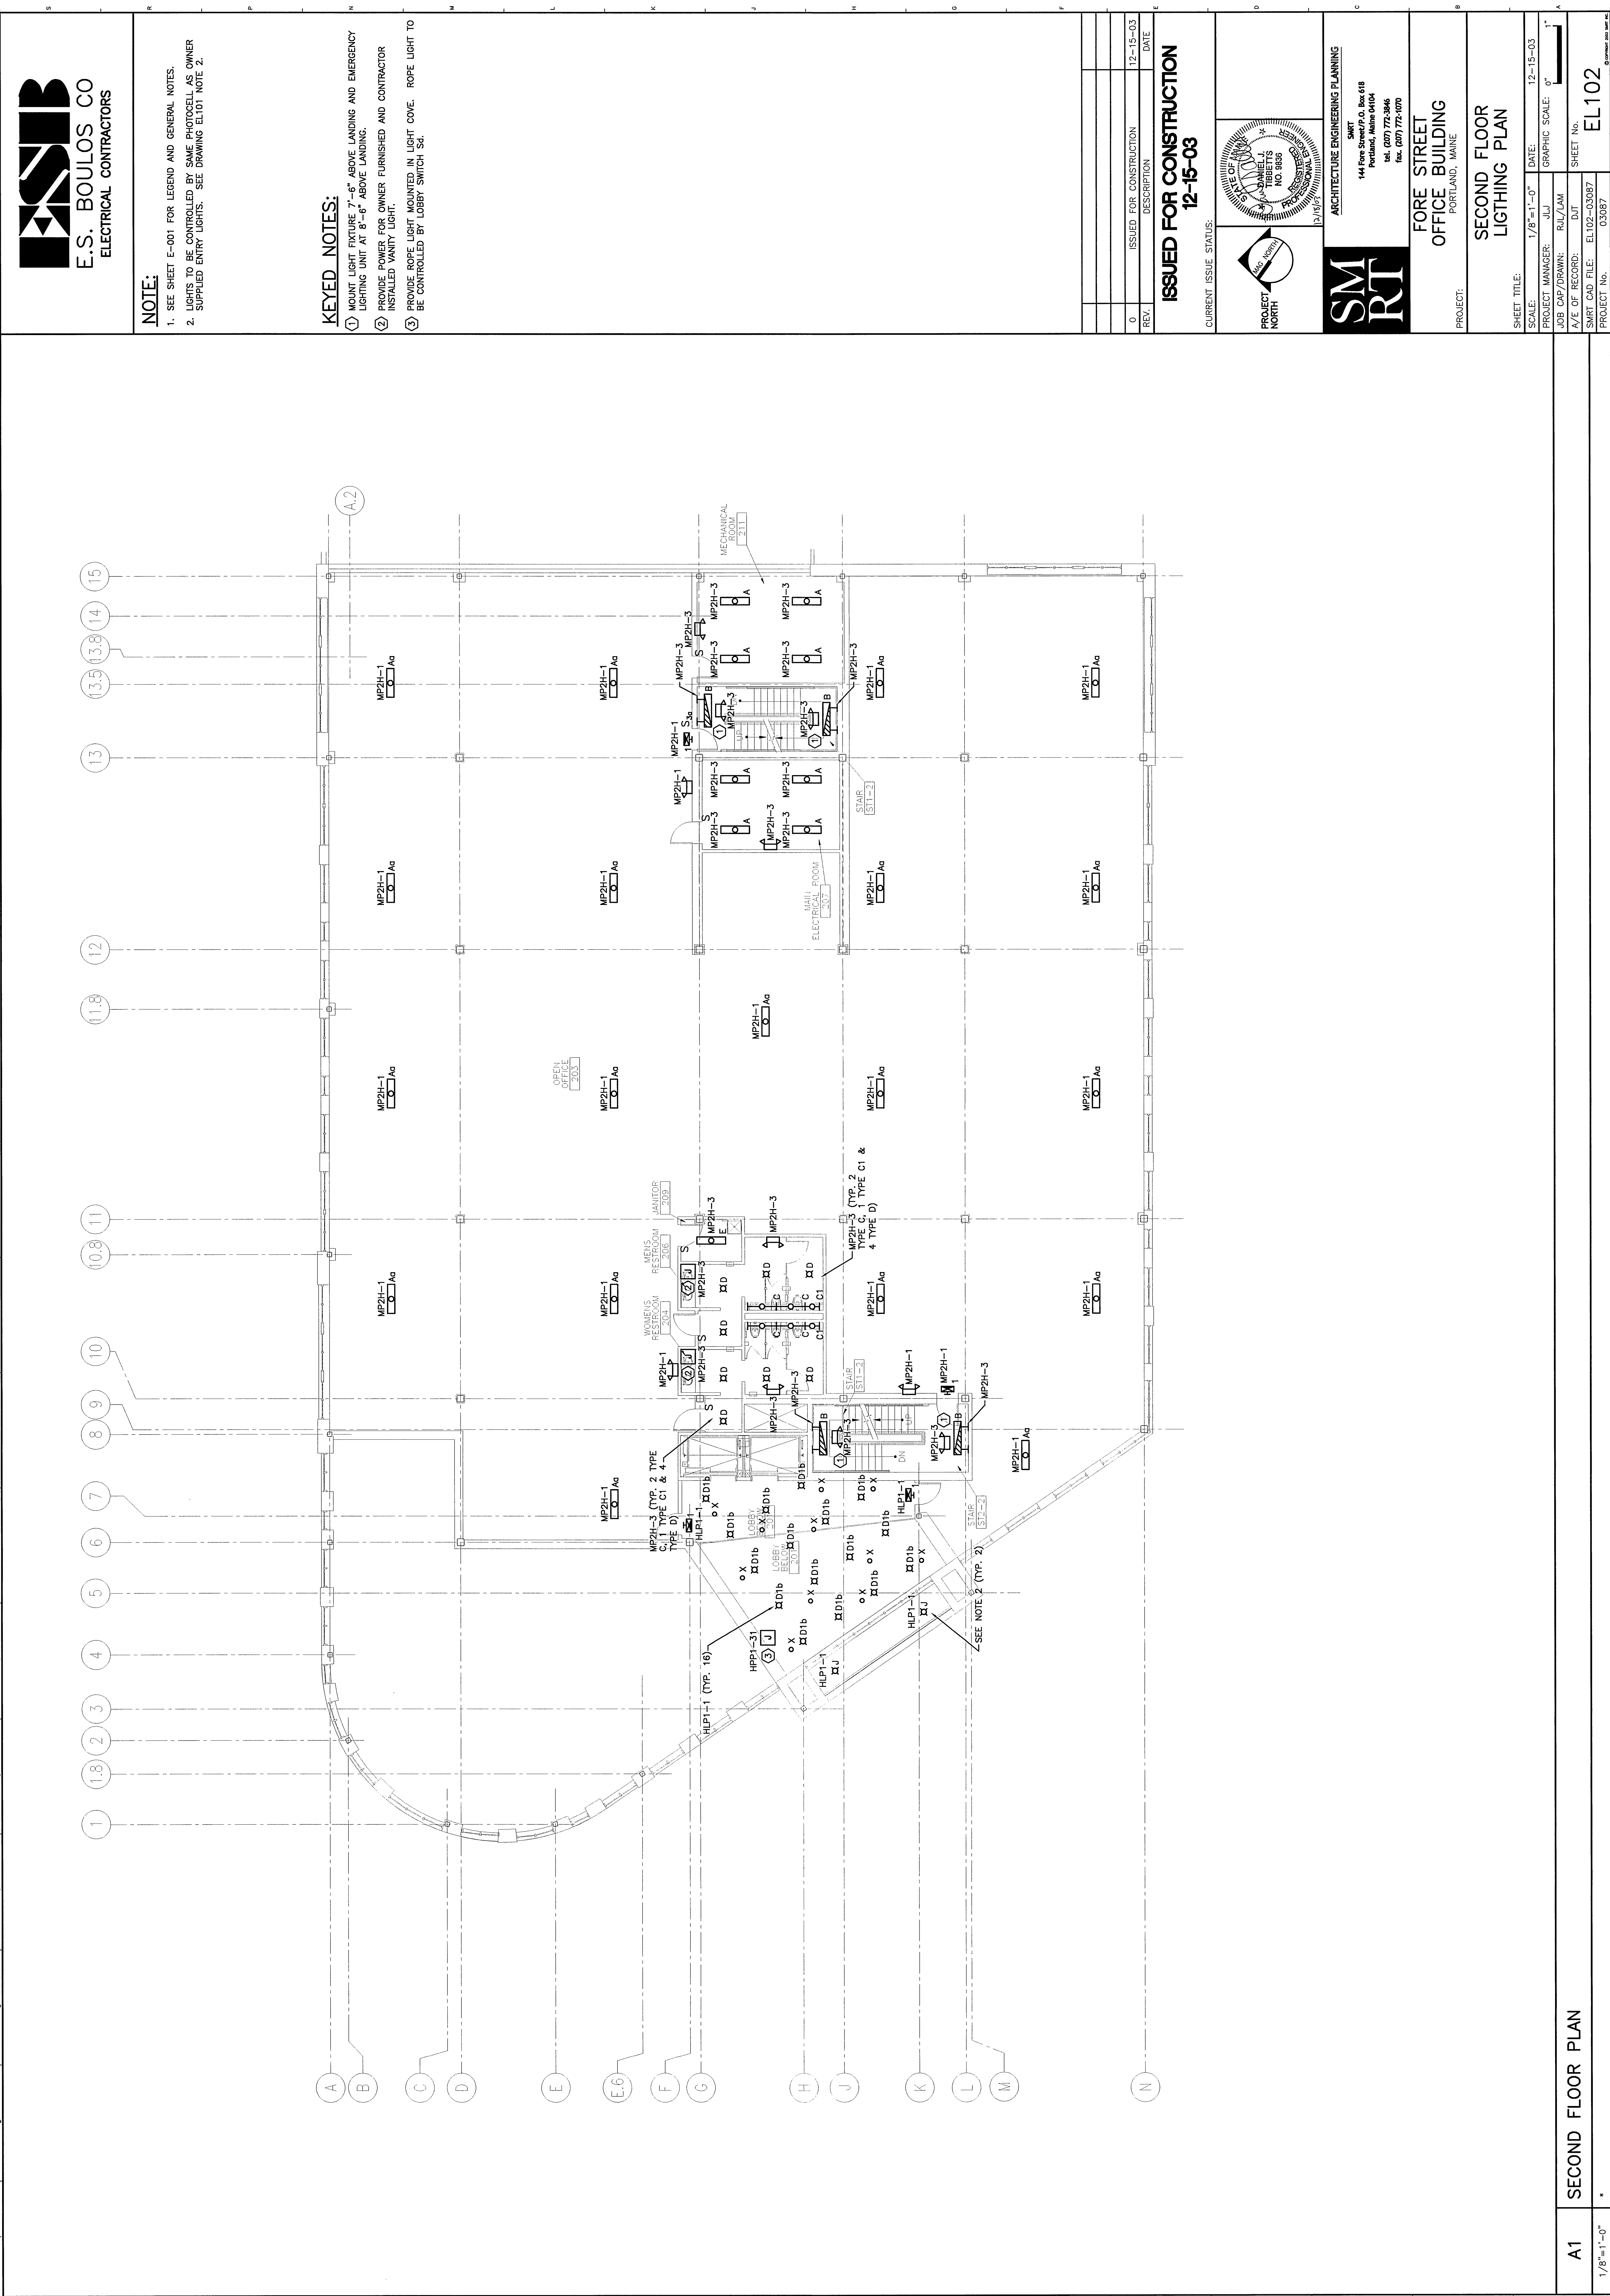

NOTE:

1. SEE SHEET E-001 FOR LEGEND AND GENERAL NOTES.

2. LIGHTS TO BE CONTROLLED BY SAME PHOTOCELL AS OWNER SUPPLIED ENTRY LIGHTS. SEE DRAWING EL101 NOTE 2.

KEYED NOTES:

① MOUNT LIGHT FIXTURE 7'-6" ABOVE LANDING AND EMERGENCY LIGHTING UNIT AT 8'-6" ABOVE LANDING.

② PROVIDE POWER FOR OWNER FURNISHED AND CONTRACTOR INSTALLED VANITY LIGHT.


③ PROVIDE ROPE LIGHT MOUNTED IN LIGHT COVE. ROPE LIGHT TO BE CONTROLLED BY LOBBY SWITCH Sd.

REV.	DESCRIPTION	DATE
0	ISSUED FOR CONSTRUCTION	12-15-03

ISSUED FOR CONSTRUCTION

12-15-03

CURRENT ISSUE STATUS:

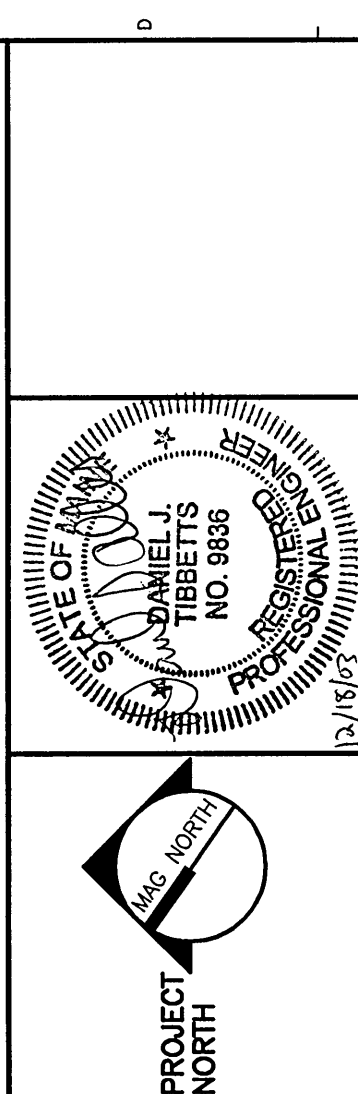

SM RT

ARCHITECTURE ENGINEERING PLANNING

144 Fore Street P.O. Box 618
Portland, Maine 04101
Tel. (603) 772-3846
Fax. (603) 772-0090

**FORE STREET
OFFICE BUILDING**

PORTLAND, MAINE

**SECOND FLOOR
LIGHING PLAN**

SHEET TITLE	1/8"=1'-0"	DATE	12-15-03
SCALE	1/8"=1'-0"	GRAPHIC SCALE	0' 1'
PROJECT MANAGER	JLJ	JOB CAP/DRAWN	RLJ/LAM
A/E OF RECORD	DJT	SHEET No.	EL102
SMART CAD FILE	EL102-03087	PROJECT No.	03087

A1 SECOND FLOOR PLAN

1/8"=1'-0"