
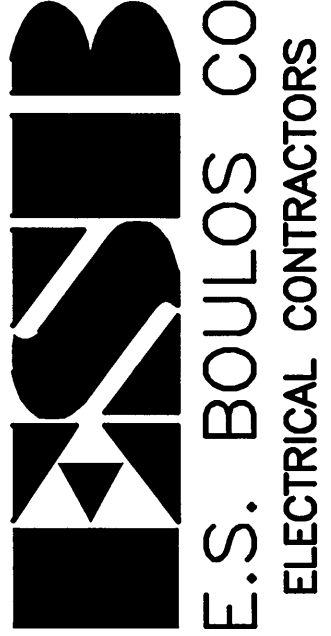


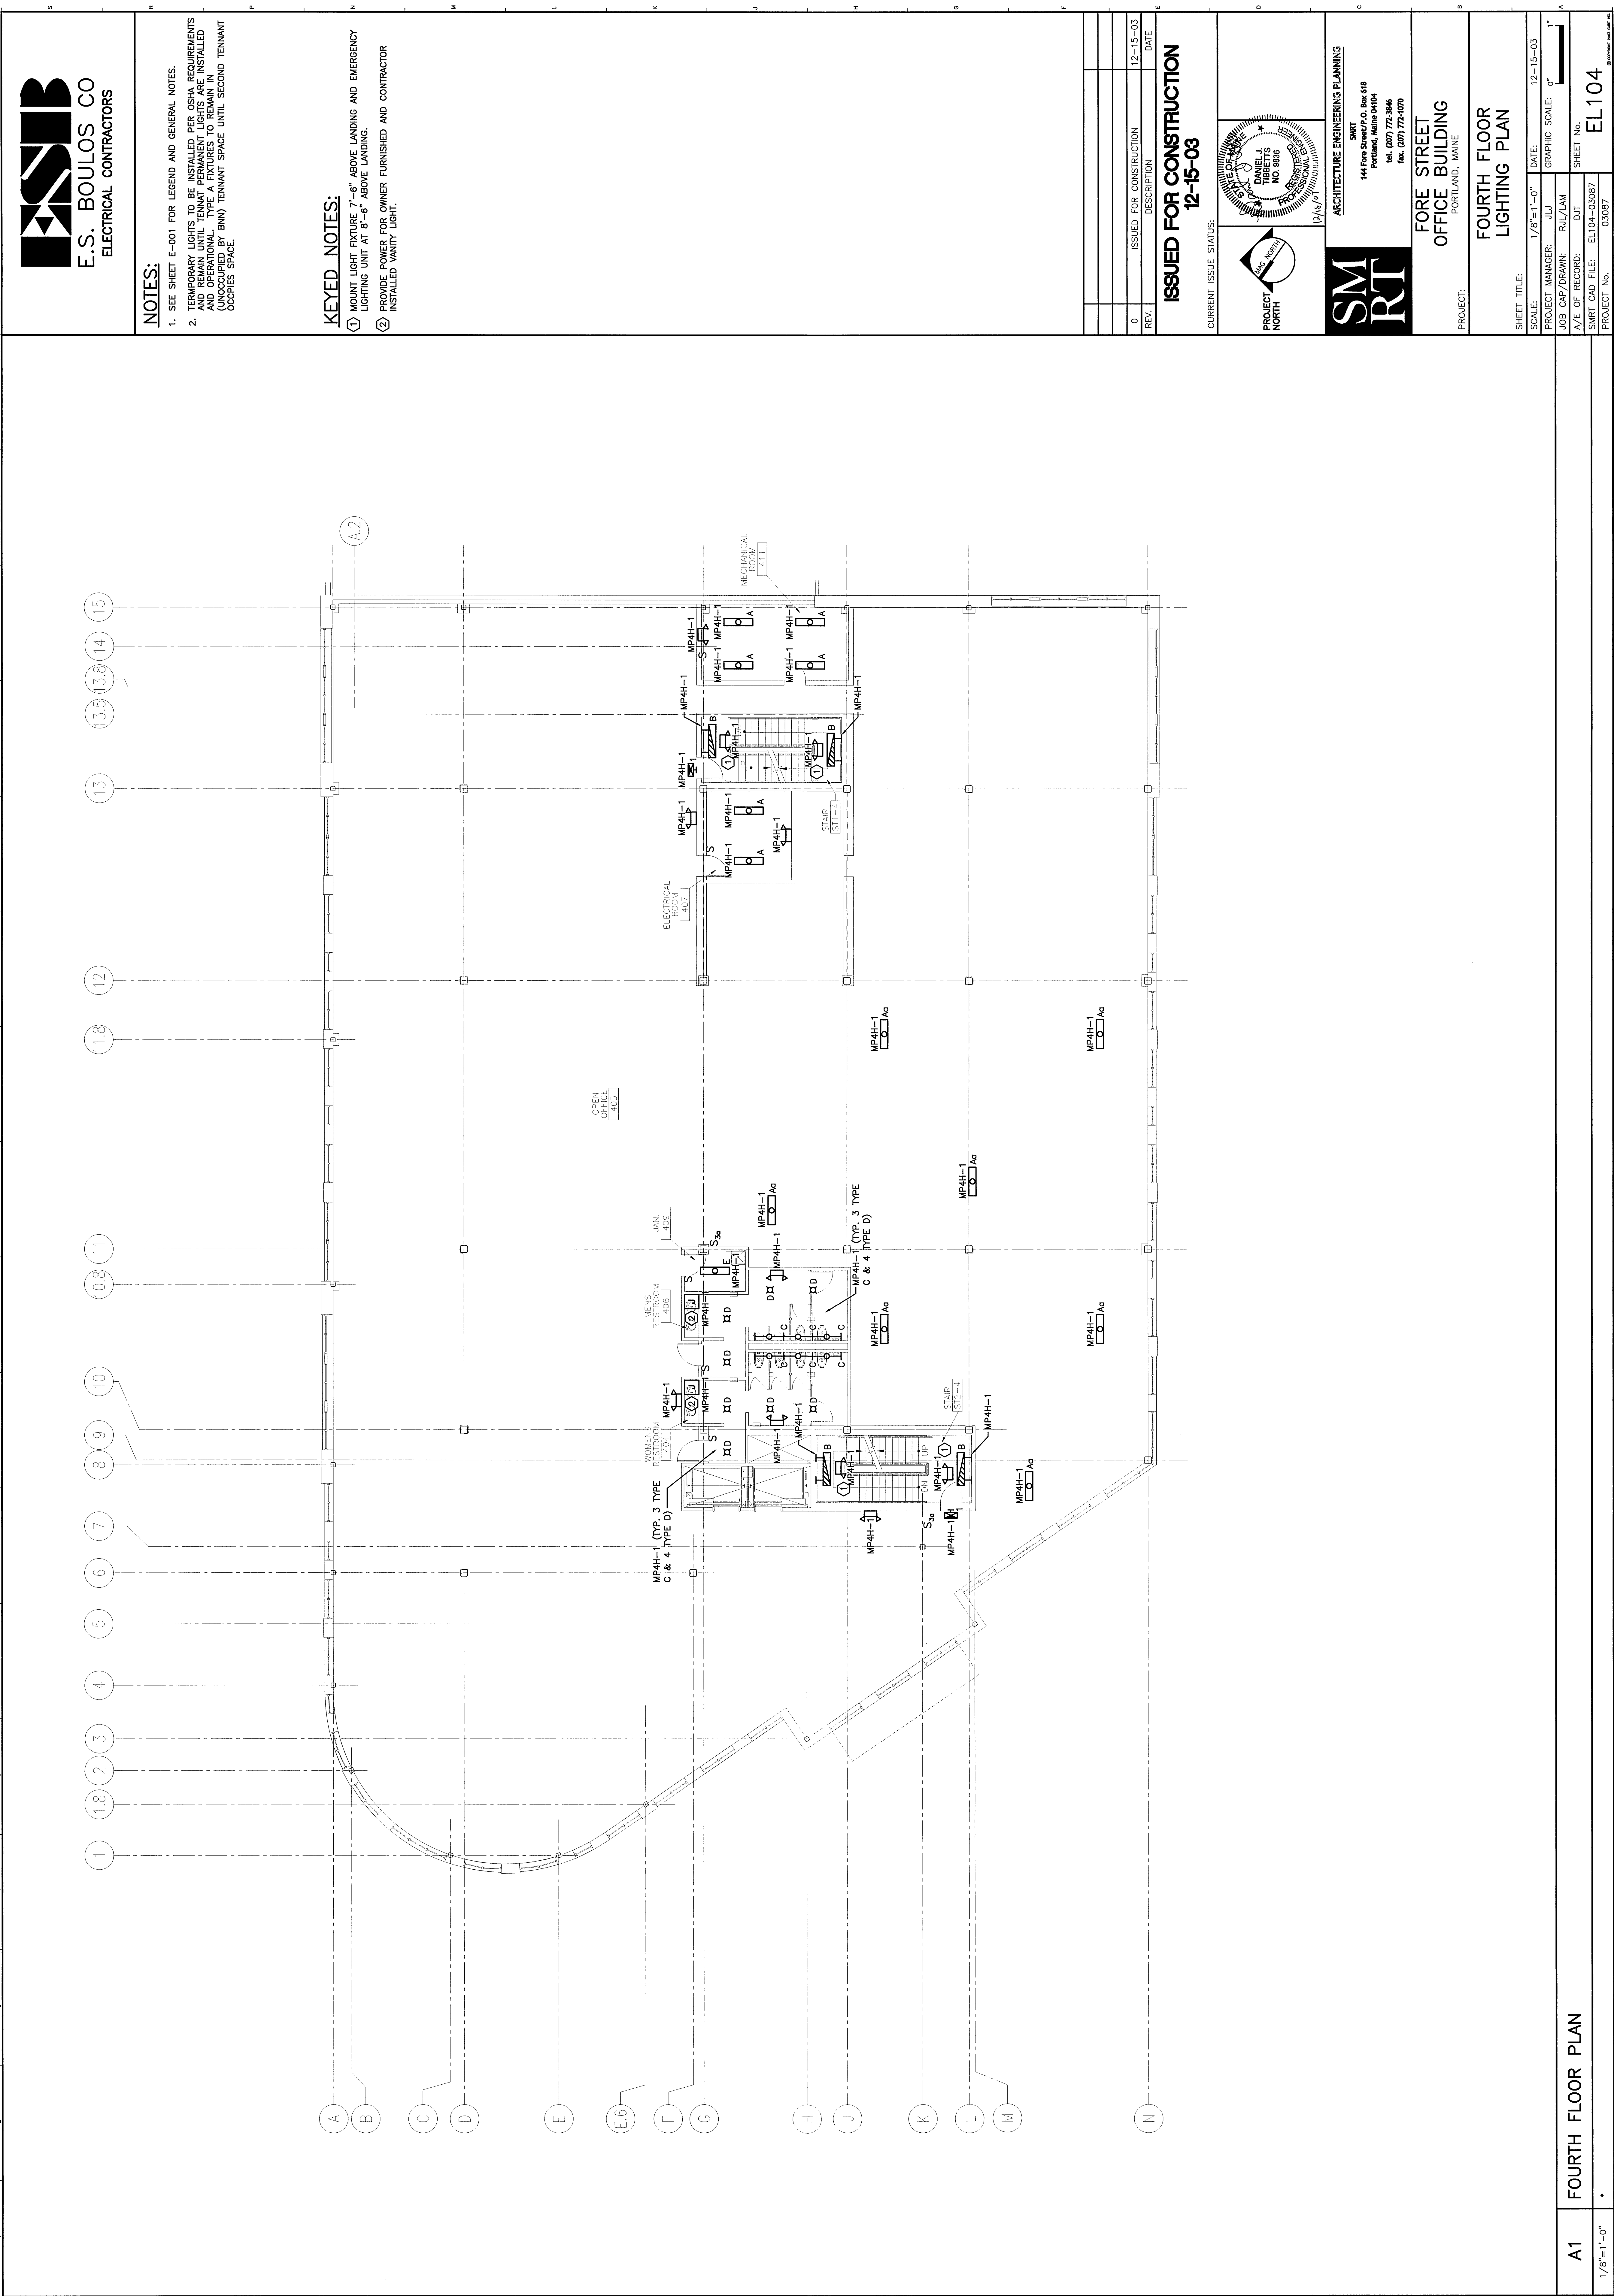

NOTES:


1. SEE SHEET E-001 FOR LEGEND AND GENERAL NOTES.
2. TEMPORARY LIGHTS TO BE INSTALLED PER OSHA REQUIREMENTS AND PERMANENT LIGHTS TO BE INSTALLED PER OSHA REQUIREMENTS AND OPERATIONAL TYPE A FIXTURES TO REMAIN IN (UNOCCUPIED BY BIN) TENANT SPACE UNTIL SECOND TENANT OCCUPES SPACE.

KEYED NOTES:

- ① MOUNT LIGHT FIXTURE 7'-6" ABOVE LANDING AND EMERGENCY LIGHTING UNIT AT 8'-6" ABOVE LANDING.
- ② PROVIDE POWER FOR OWNER FURNISHED AND CONTRACTOR INSTALLED VANITY LIGHT.

ISSUED FOR CONSTRUCTION
12-15-03

CURRENT ISSUE STATUS:

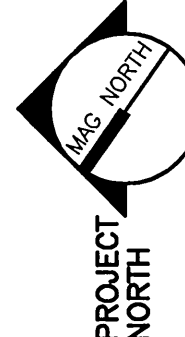

SMRT
144 Fore Street P.O. Box 618
Portland, Maine 04104
tel. (207) 772-3846
fax. (207) 772-1070

FORE STREET
OFFICE BUILDING
PORTLAND, MAINE

FOURTH FLOOR
LIGHTING PLAN

SHEET TITLE:	1/8"=1'-0"	DATE:	12-15-03
PROJECT MANAGER:	JUL	GRAPHIC SCALE:	0'
JOB CAP/DRAWN:	RL/JAM		
A/E OF RECORD:	DJT	SHEET No.	EL104
SMART CAD FILE:	EL104-03087		
PROJECT No.	03087		

A1 FOURTH FLOOR PLAN

1/8"=1'-0"