


NOTES:

1. SEE SHEET E-001 FOR LEGEND AND GENERAL NOTES.
2. TEMPORARY LIGHTS TO BE INSTALLED PER OSHA REQUIREMENTS AND PERMANENT LIGHTS TO BE INSTALLED UNTIL TENANT PERMANENT LIGHTS ARE INSTALLED AND OPERATIONAL.

KEYED NOTES:


- ① MOUNT LIGHT FIXTURE 7'-6" ABOVE LANDING AND EMERGENCY LIGHTING UNIT AT 8'-6" ABOVE LANDING.
- ② PROVIDE POWER FOR OWNER FURNISHED AND CONTRACTOR INSTALLED VANITY LIGHT.

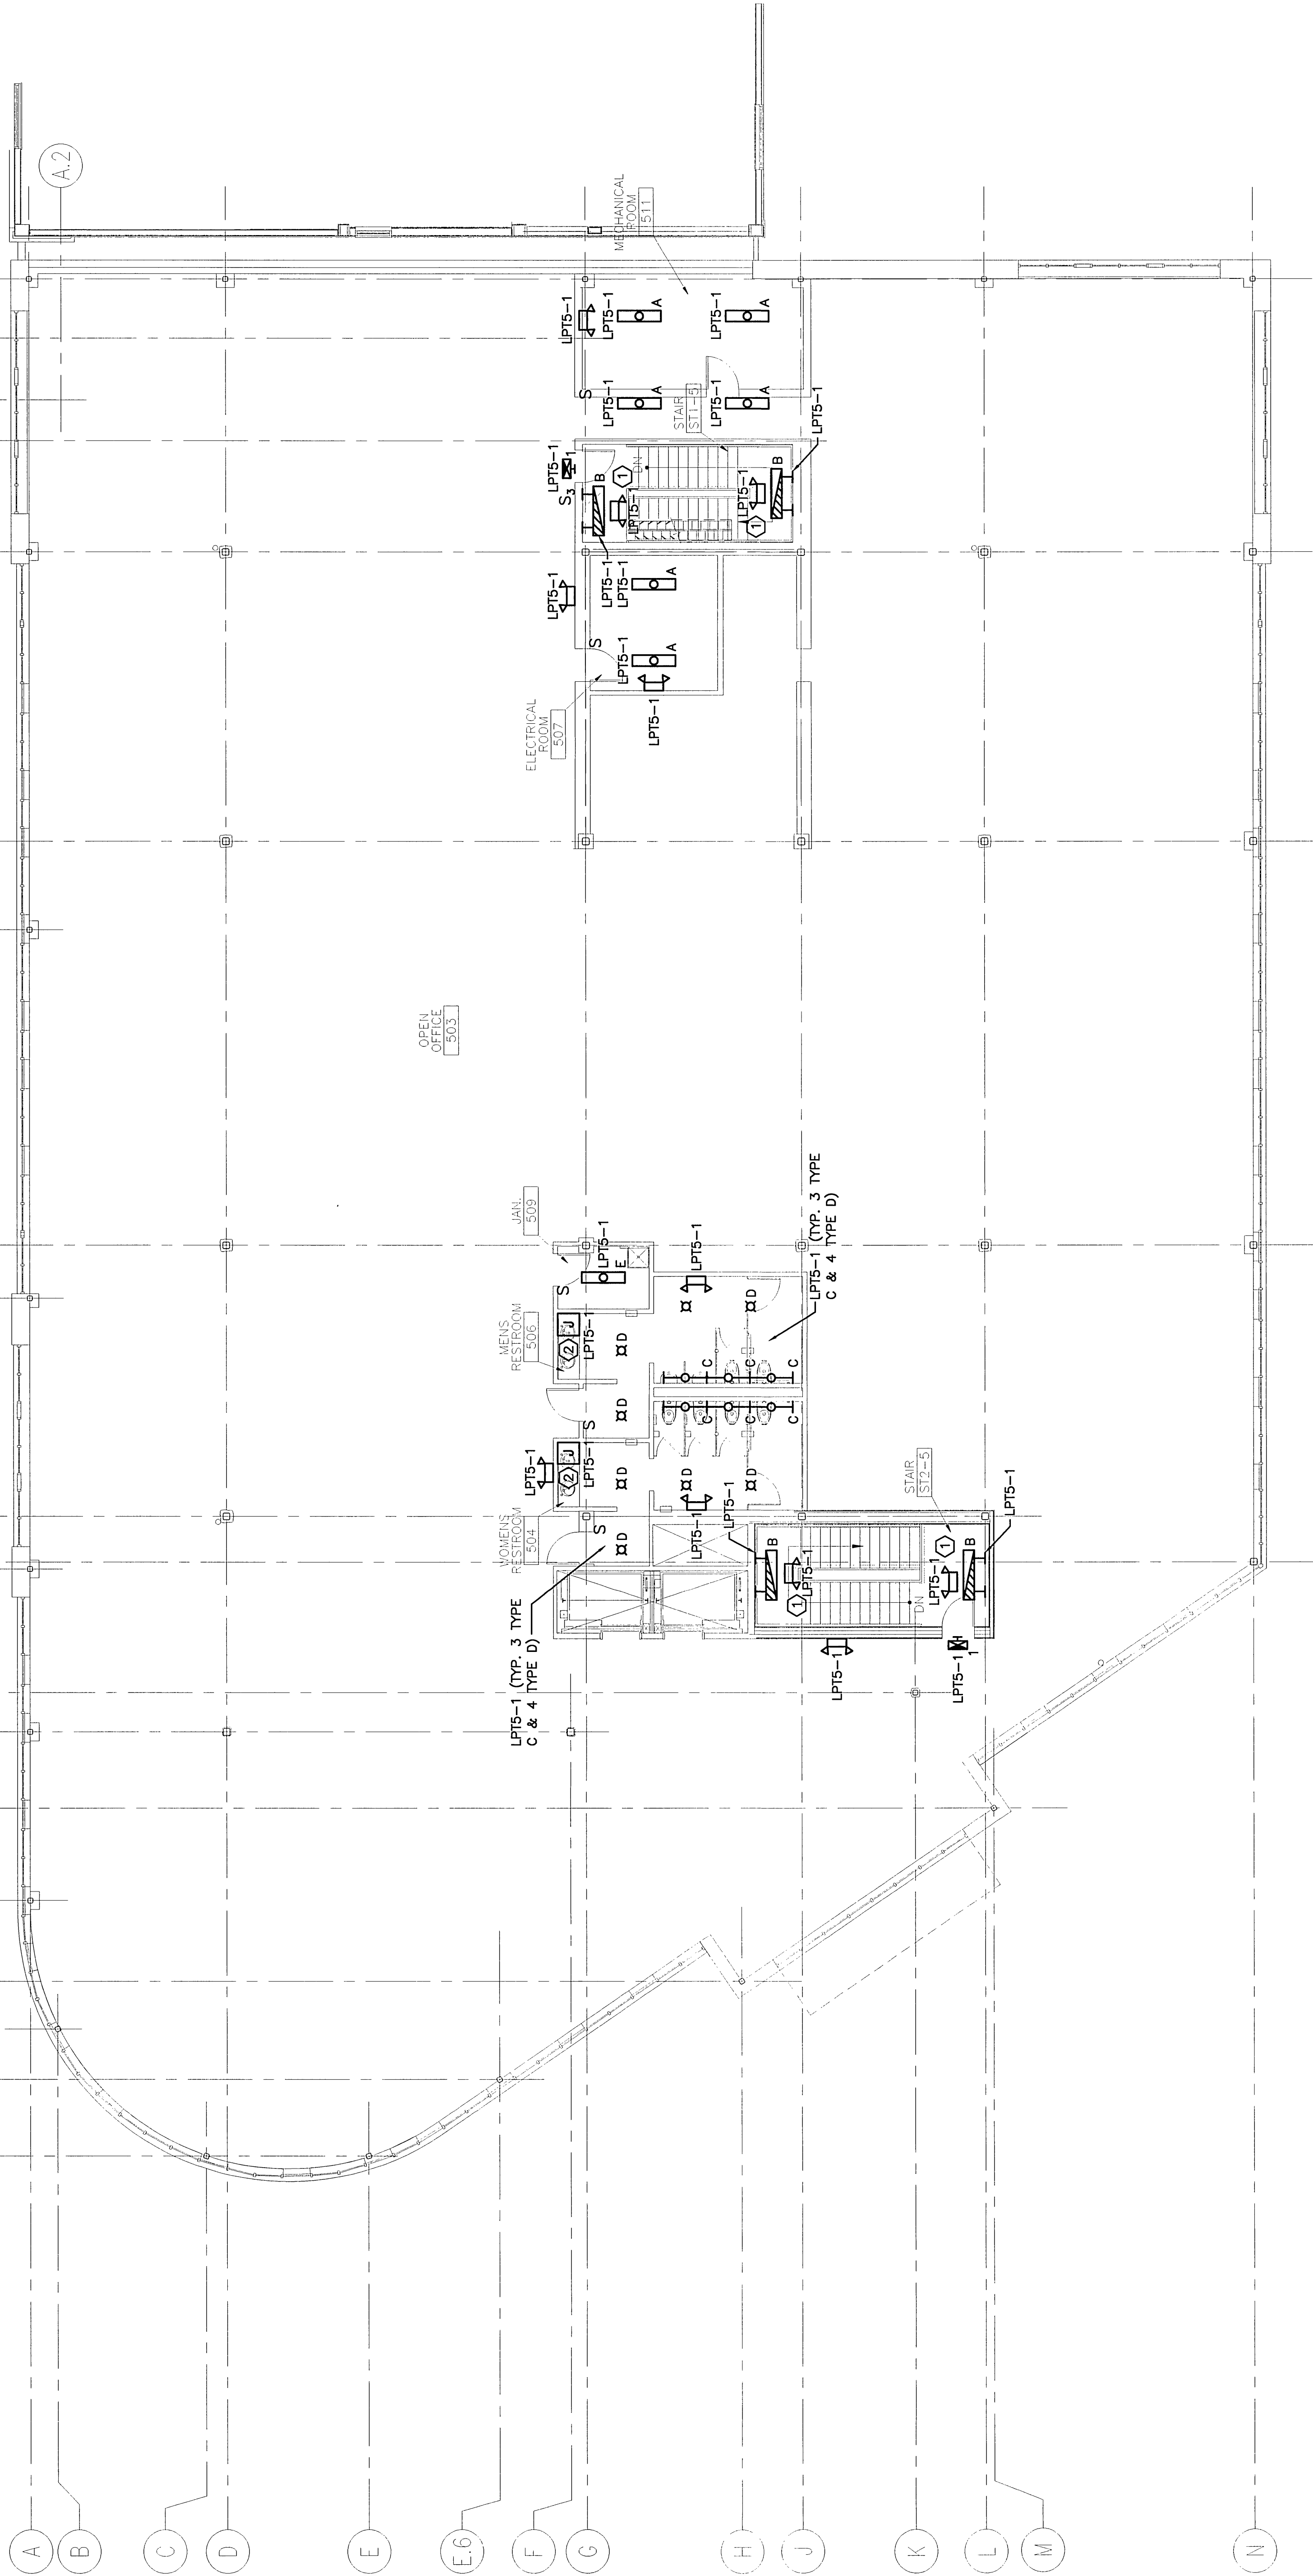

REV.	ISSUED FOR CONSTRUCTION	DESCRIPTION	DATE
0			12-15-03

ISSUED FOR CONSTRUCTION
12-15-03

CURRENT ISSUE STATUS:

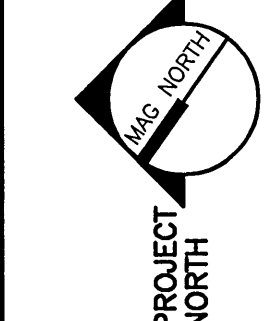

SMI
RT
ARCHITECTURE ENGINEERING PLANNING
144 Fore Street, P.O. Box 618
Portland, Maine 04104
tel. (207) 772-3846
fax. (207) 772-1070

FORE STREET
OFFICE BUILDING
PORTLAND, MAINE

FIFTH FLOOR
LIGHTING PLAN

SHEET TITLE:	1/8"=1'-0"	DATE:	12-15-03
PROJECT:	1/8"=1'-0"	GRAPHIC SCALE:	0'
PROJECT MANAGER:	JLJ	DATE:	12-15-03
USE CAP/DESIGN:	RLJ/LAM	DATE:	12-15-03
DATE OF RECORD:	DJT	DATE:	12-15-03
SMART CAD FILE:	EL105-03087	DATE:	12-15-03
PROJECT No.	03087	DATE:	12-15-03