
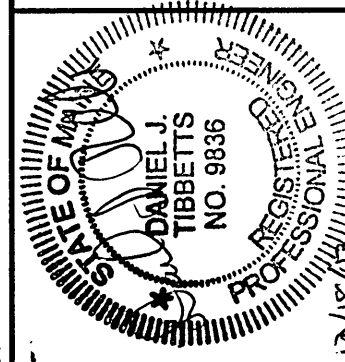


NOTE:

1. SEE SHEET E-001 FOR LEGEND AND GENERAL NOTES.

KEYED NOTE:

① EXTEND WIRING FROM EXISTING COMPACTOR DISCONNECT LOCATION SHOWN ON E5101 TO NEW LOCATION SHOWN IN DUMPSTER AREA 01D.

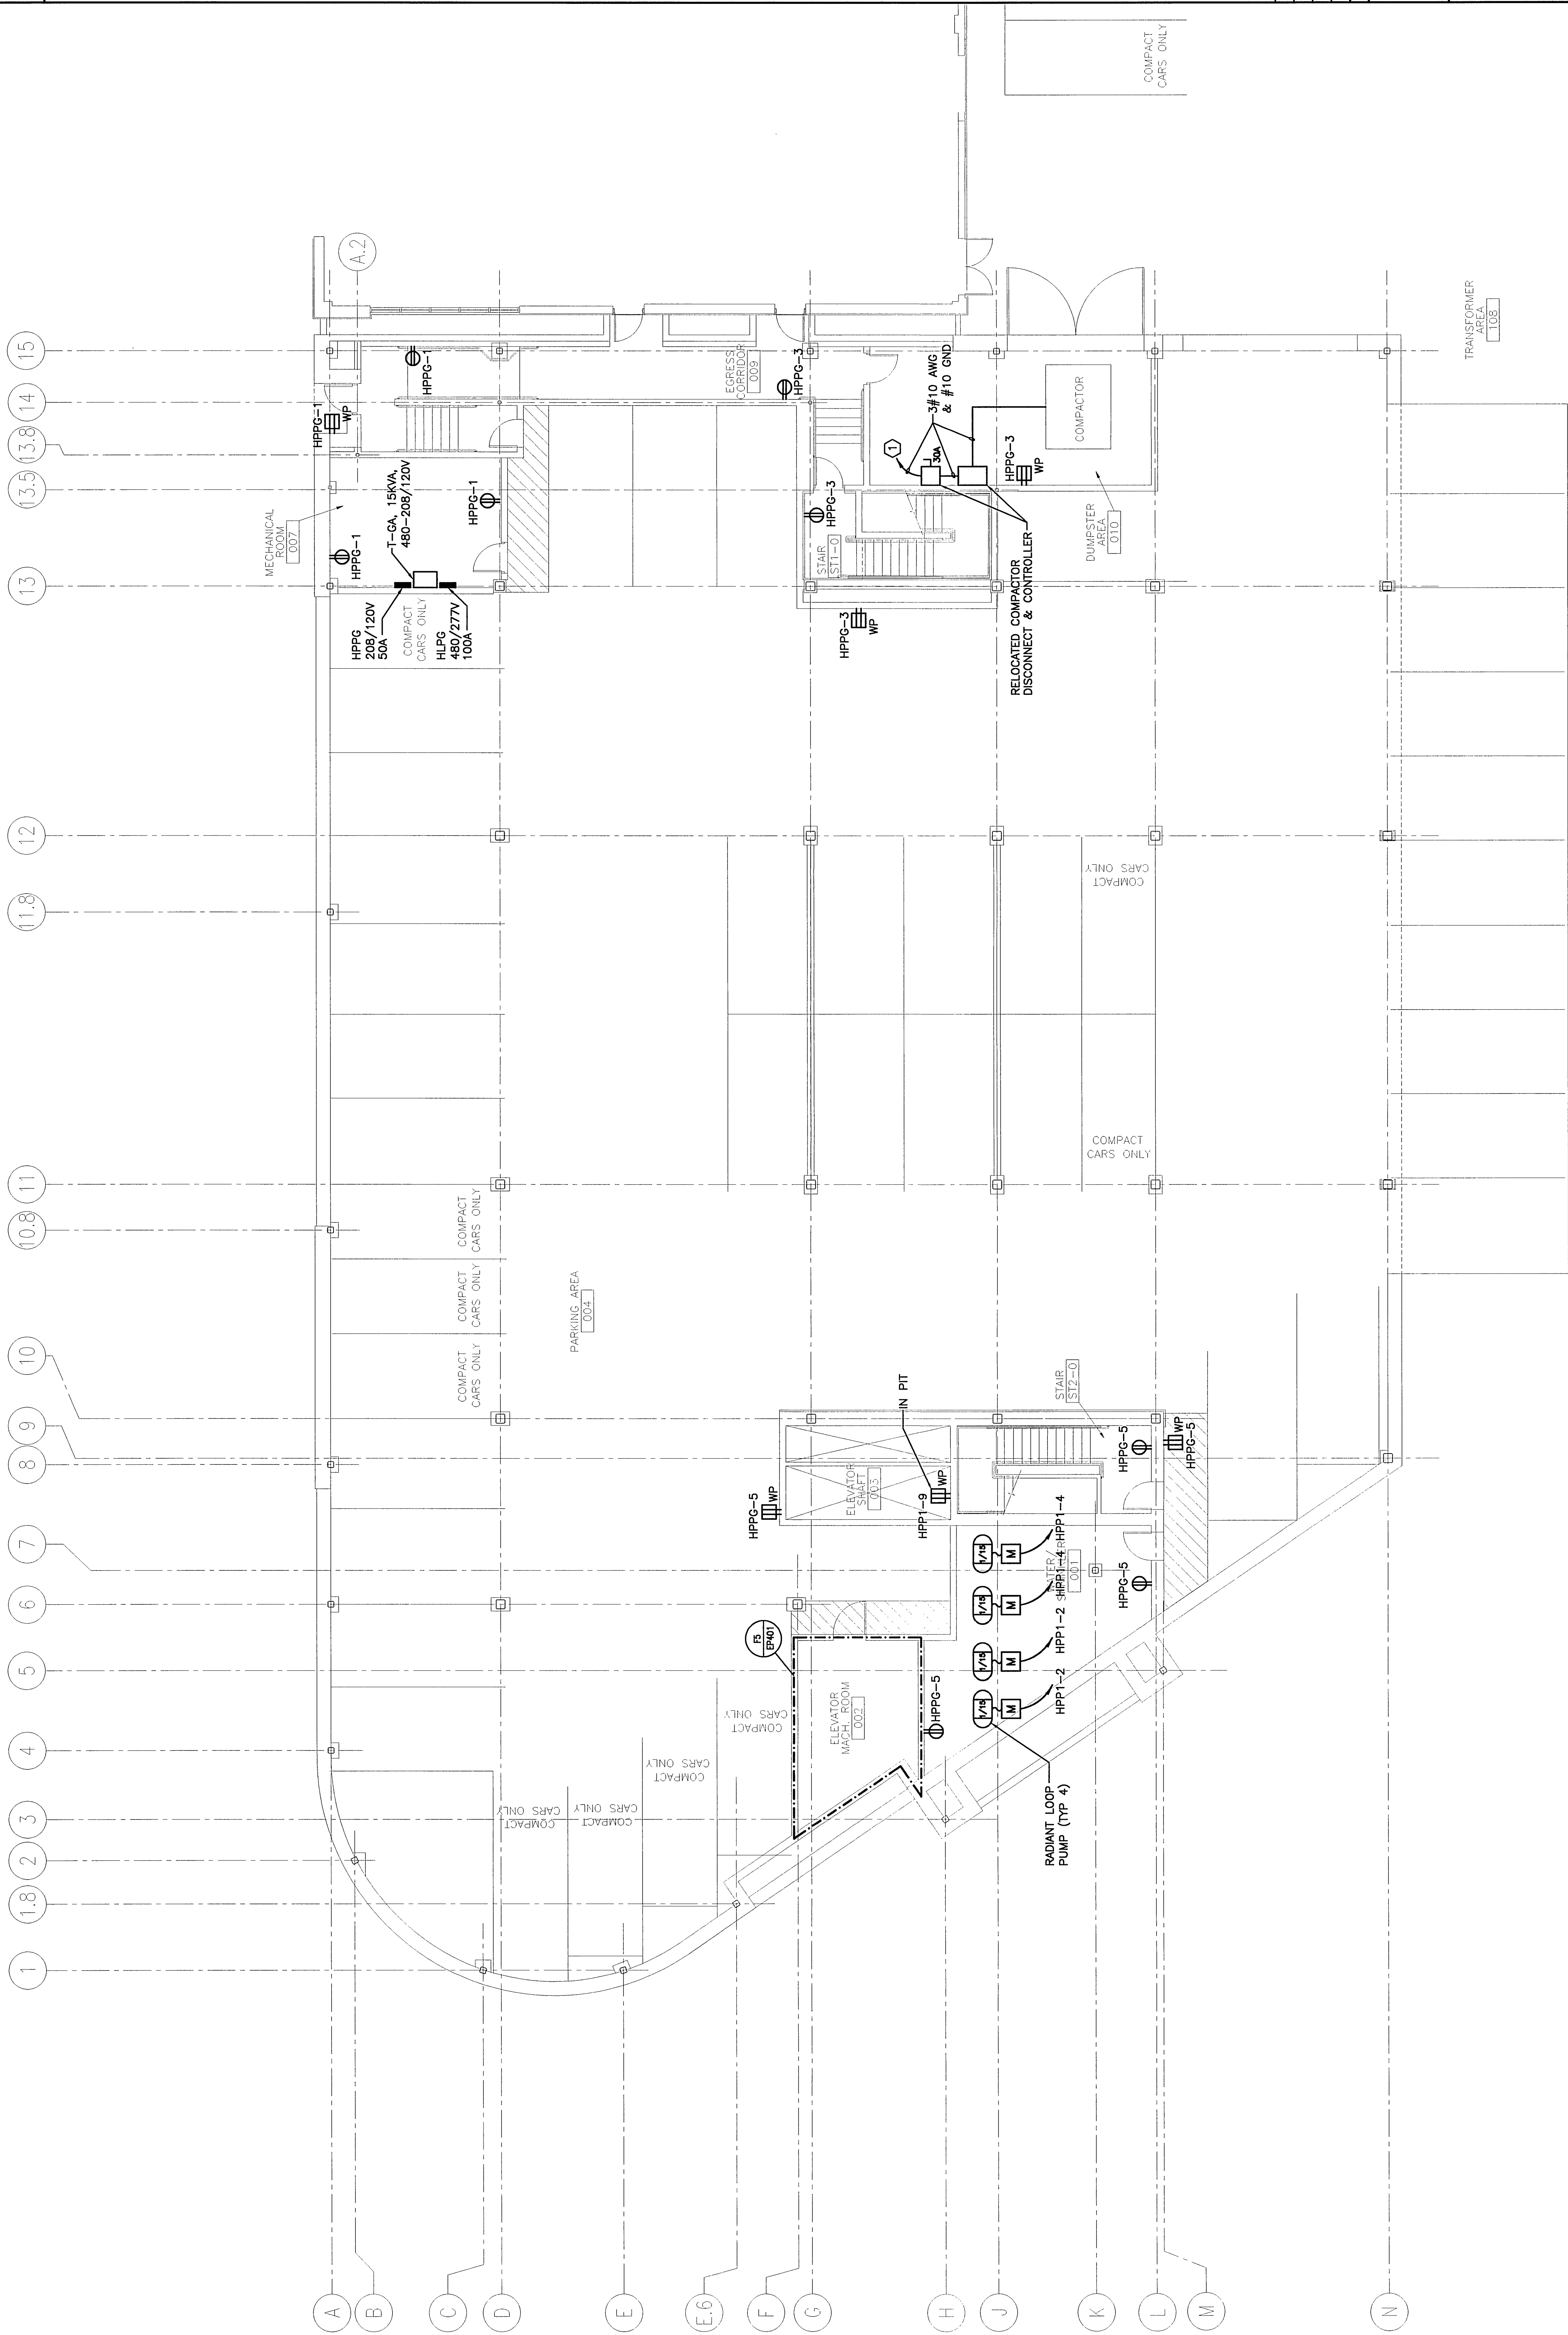

ARCHITECTURE ENGINEERING PLANNING
144 Fore Street P.O. Box 618
Portland, Maine 04104
tel. (207) 772-3646
fax. (207) 772-1070

**SM
RT**

PROJECT:
**FORE STREET
OFFICE BUILDING**
PORTLAND, MAINE

LOWER PARKING
LEVEL POWER PLAN

SHEET TITLE: 1/8"=1'-0" DATE: 12-15-03
SCALE: GRAPHIC SCALE: 1"

PROJECT MANAGER: JJJ
JOB CAP/DRAWN: RAL/JAM
A/E OF RECORD: DJT
SMART CAD FILE: EP100-03087
PROJECT No.: 03087

SHEET No.: EP100
PROJECT No.: 03087

A1 LOWER PARKING LEVEL PLAN

1/8"=1'-0"