


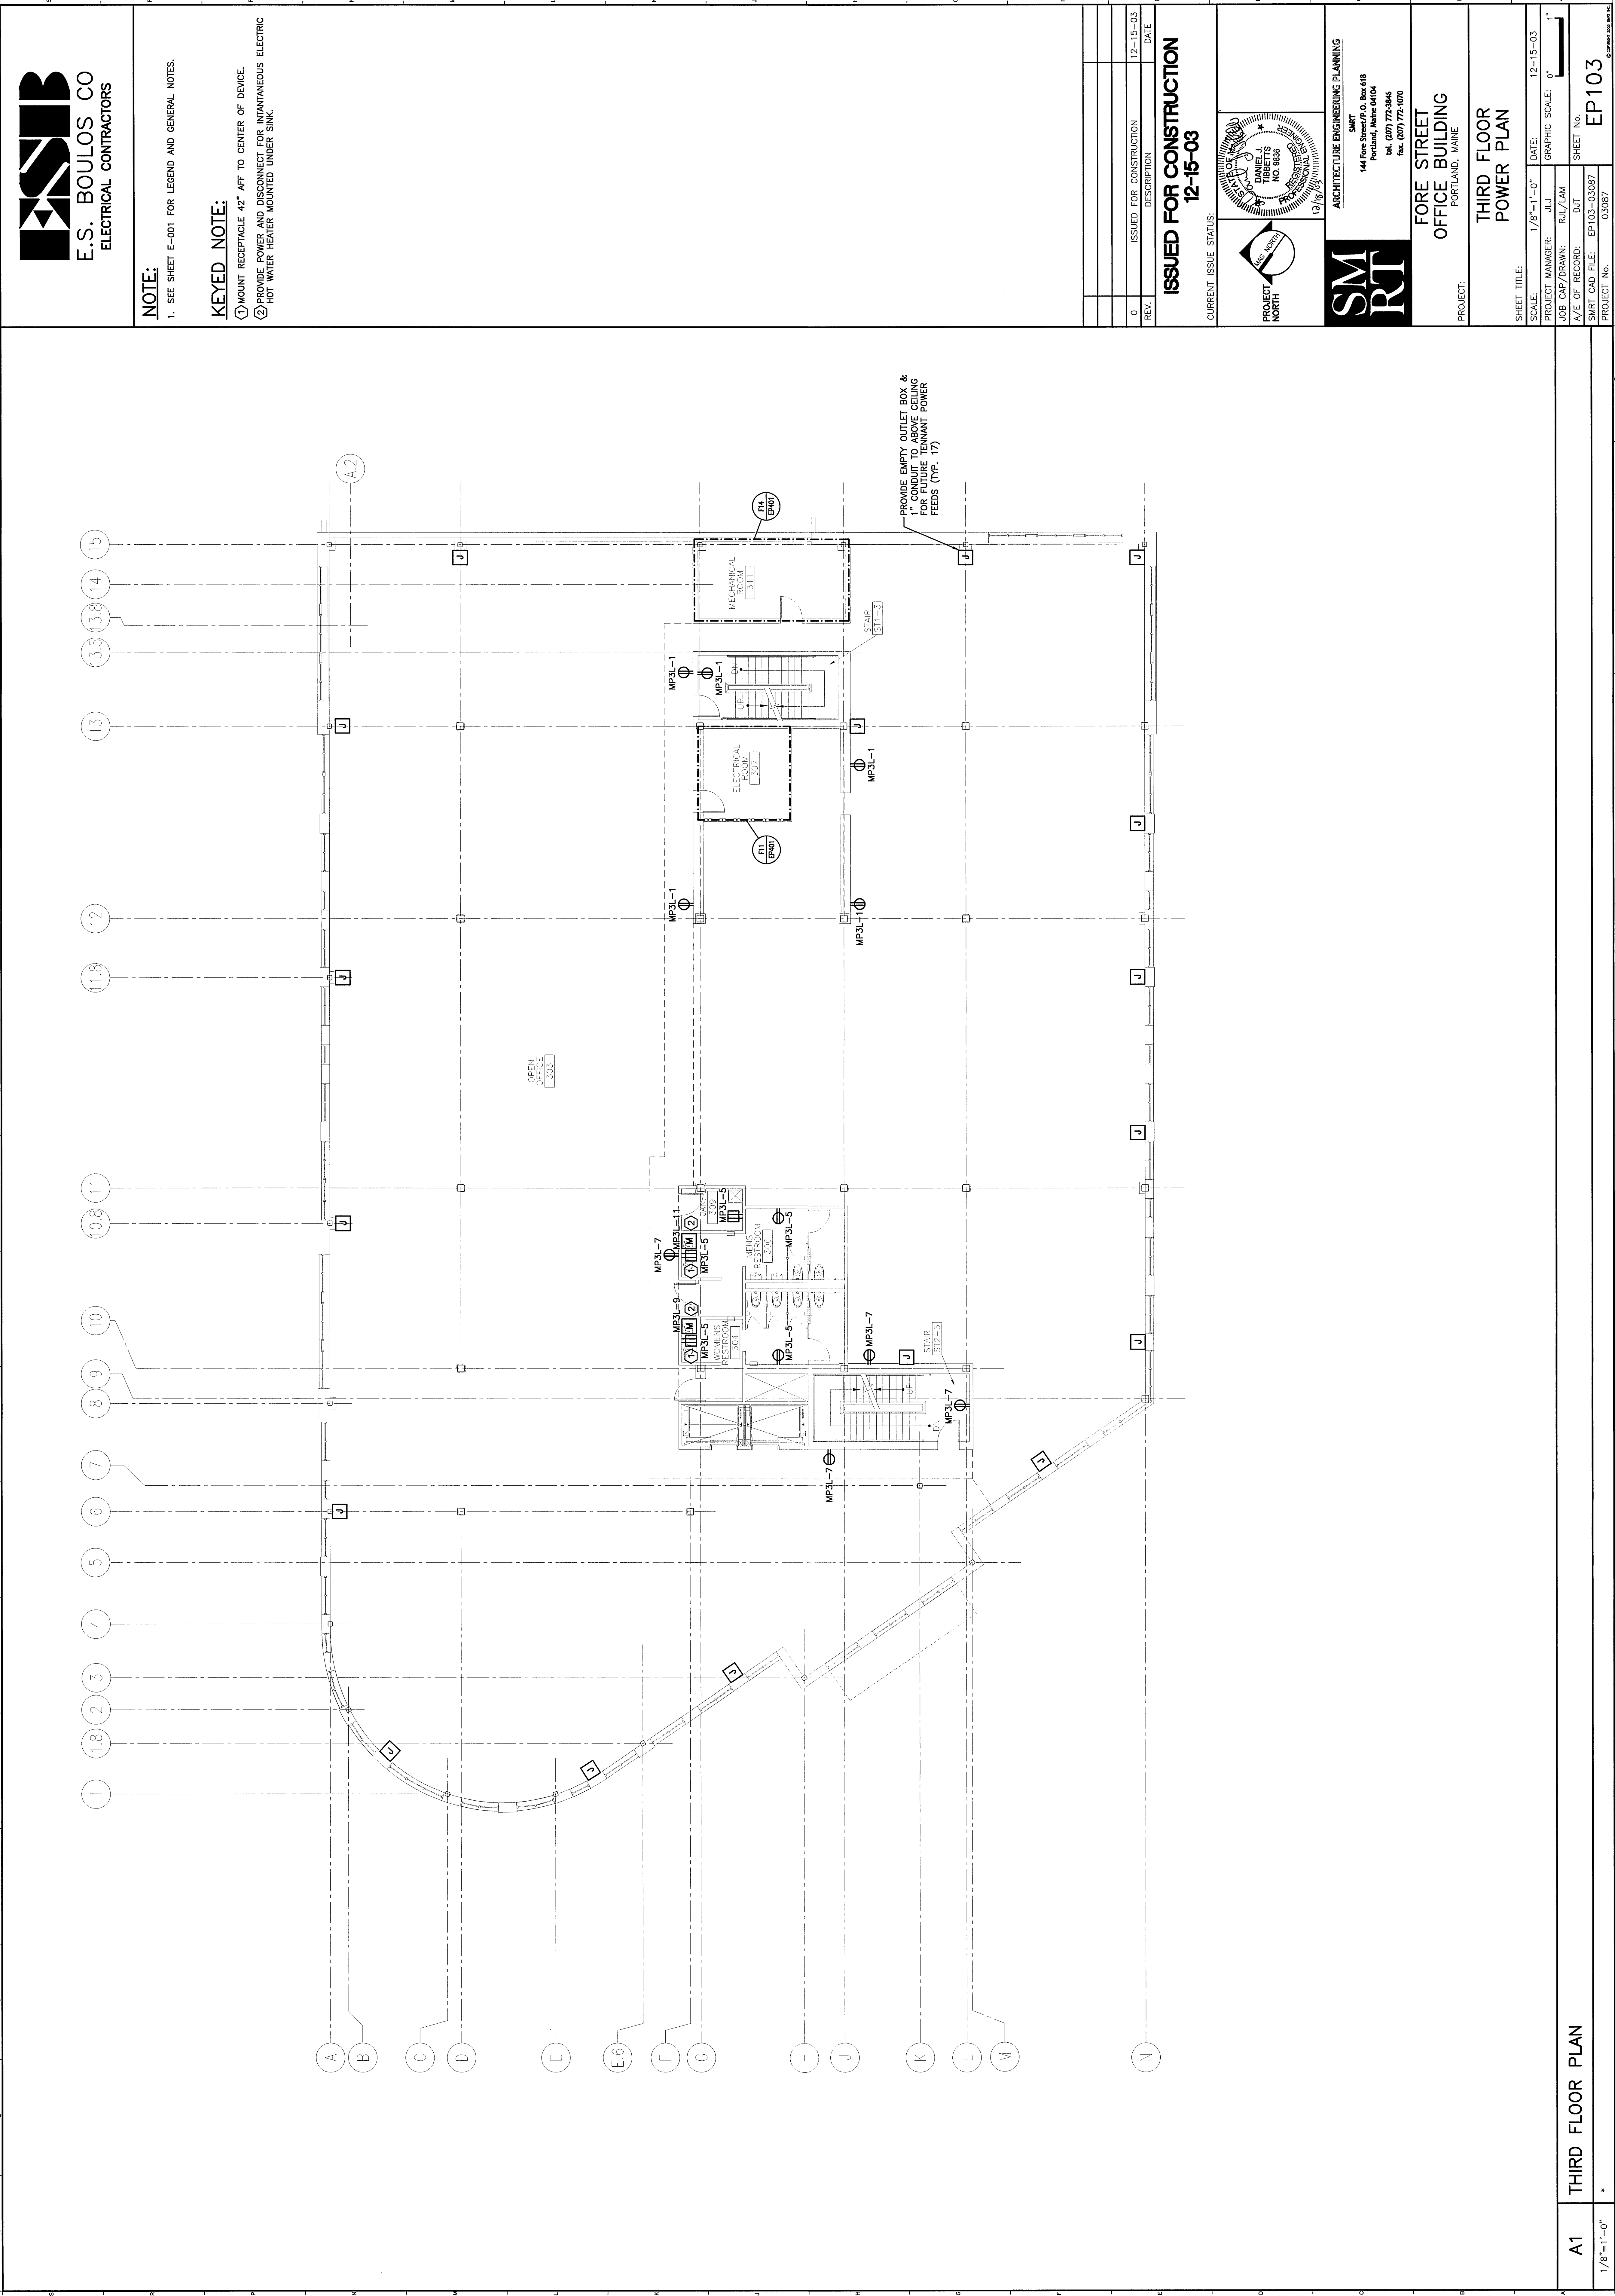

E.S. BOULOS CO
ELECTRICAL CONTRACTORS

NOTE:

1. SEE SHEET E-001 FOR LEGEND AND GENERAL NOTES.

KEYED NOTE:

- ① MOUNT RECEPTACLE 42" AFT TO CENTER OF DEVICE.
- ② PROVIDE POWER AND DISCONNECT FOR INSTANTANEOUS ELECTRIC HOT WATER HEATER MOUNTED UNDER SINK.

REV.	ISSUED FOR CONSTRUCTION	DESCRIPTION	DATE
0	12-15-03		

ISSUED FOR CONSTRUCTION
12-15-03

CURRENT ISSUE STATUS:



PROJECT NORTH



ARCHITECTURE ENGINEERING PLANNING
SM RT
144 Fore Street P.O. Box 618
Portland, Maine 04104
tel. (207) 772-3846
fax. (207) 772-1070

FORE STREET
OFFICE BUILDING
PORTLAND, MAINE

THIRD FLOOR
POWER PLAN

SHEET TITLE:	1/8"=1'-0"	DATE:	12-15-03
SCALE:	1/8"=1'-0"	GRAPHIC SCALE:	0'
PROJECT MANAGER:	JLL	JOB CAP/DRAWN:	RLL/JAM
A/E OF RECORD:	DJT	SHEET No.	EP103
PROJECT No.	03087	SHEET CAD FILE:	EP103-03087