
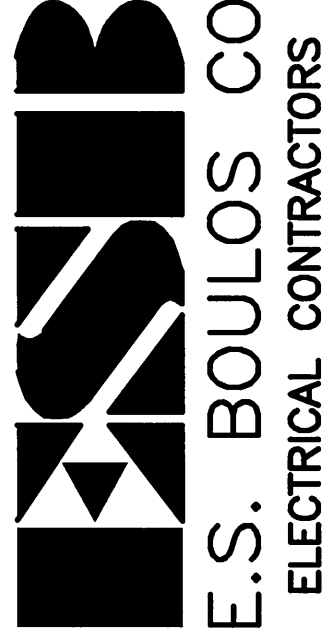


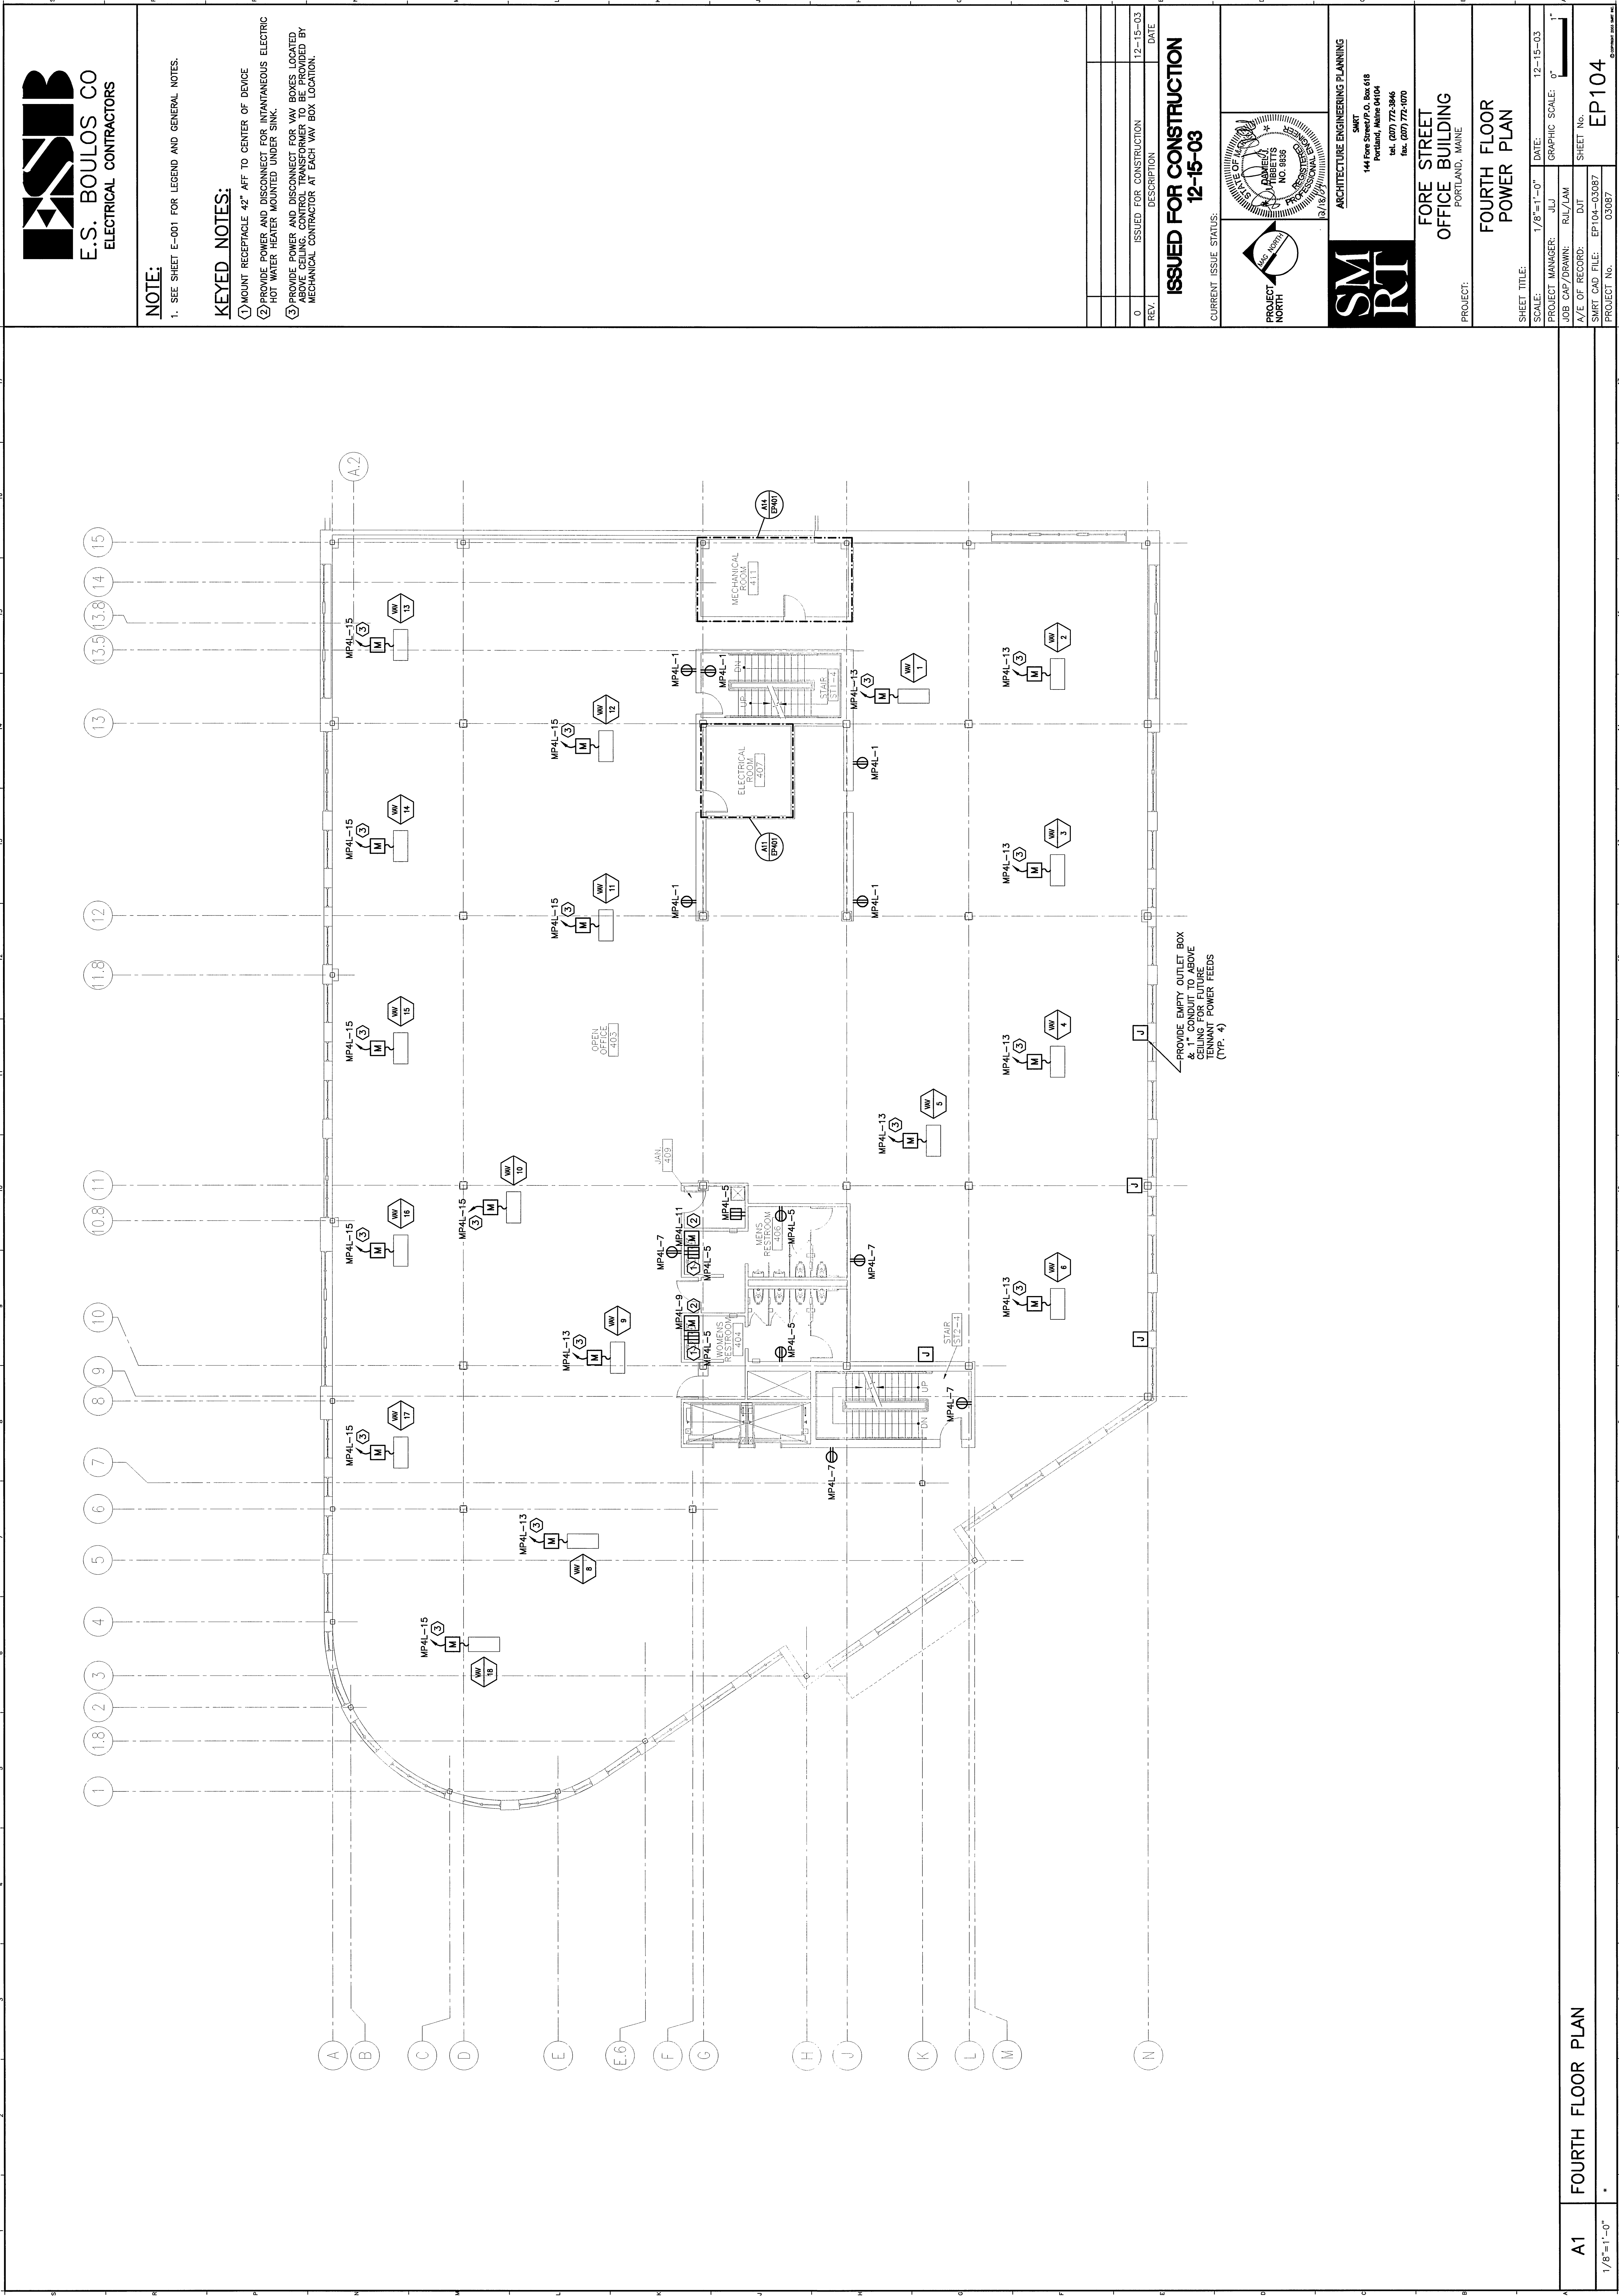

E.S. BOULOS CO
ELECTRICAL CONTRACTORS

NOTE:

1. SEE SHEET E-001 FOR LEGEND AND GENERAL NOTES.


KEYED NOTES:

- ① MOUNT RECEPTACLE 42" AFF TO CENTER OF DEVICE
- ② PROVIDE POWER AND DISCONNECT FOR INSTANTANEOUS ELECTRIC HOT WATER HEATER MOUNTED UNDER SINK
- ③ PROVIDE POWER AND DISCONNECT FOR VAV BOXES LOCATED IN MECHANICAL ROOMS. DISCONNECTS TO BE PROVIDED BY MECHANICAL CONTRACTOR AT EACH VAV BOX LOCATION.

REV.	DESCRIPTION	DATE
0	ISSUED FOR CONSTRUCTION	12-15-03

ISSUED FOR CONSTRUCTION
12-15-03

CURRENT ISSUE STATUS:

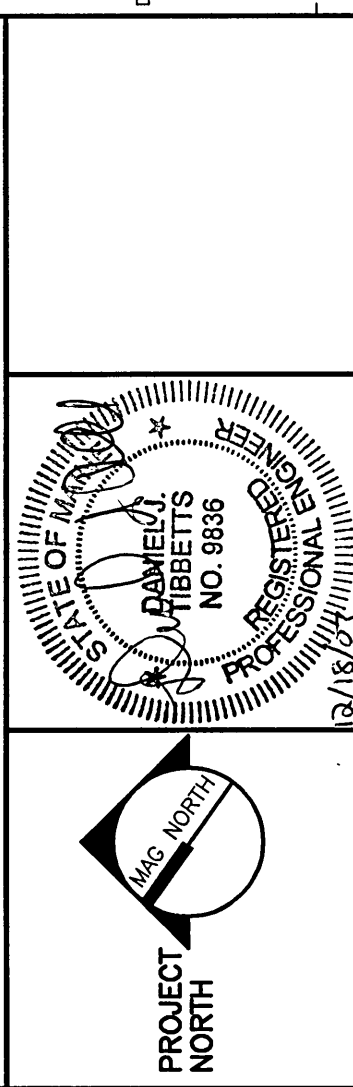

ARCHITECTURE ENGINEERING PLANNING
SMRT
144 Fore Street, 5th Fl., Box 618
Portland, ME 04101
Tel: (207) 772-3846
Fax: (207) 772-1070

FORE STREET
OFFICE BUILDING
PORTLAND, MAINE

FOURTH FLOOR
POWER PLAN

SHEET TITLE:	1/8"=1'-0"	DATE:	12-15-03
SCALE:	1/8"=1'-0"	GRAPHIC SCALE:	0' 1"
PROJECT MANAGER:	JJJ	JOB CAP/DRAWN:	RLL/LAM
A/E OF RECORD:	DIT	SHEET No.	EP104
SMART CAD FILE:	EP104-03087	PROJECT No.	03087

A1 FOURTH FLOOR PLAN

1/8"=1'-0"