
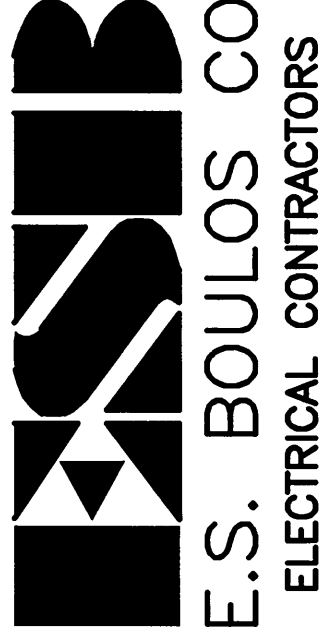


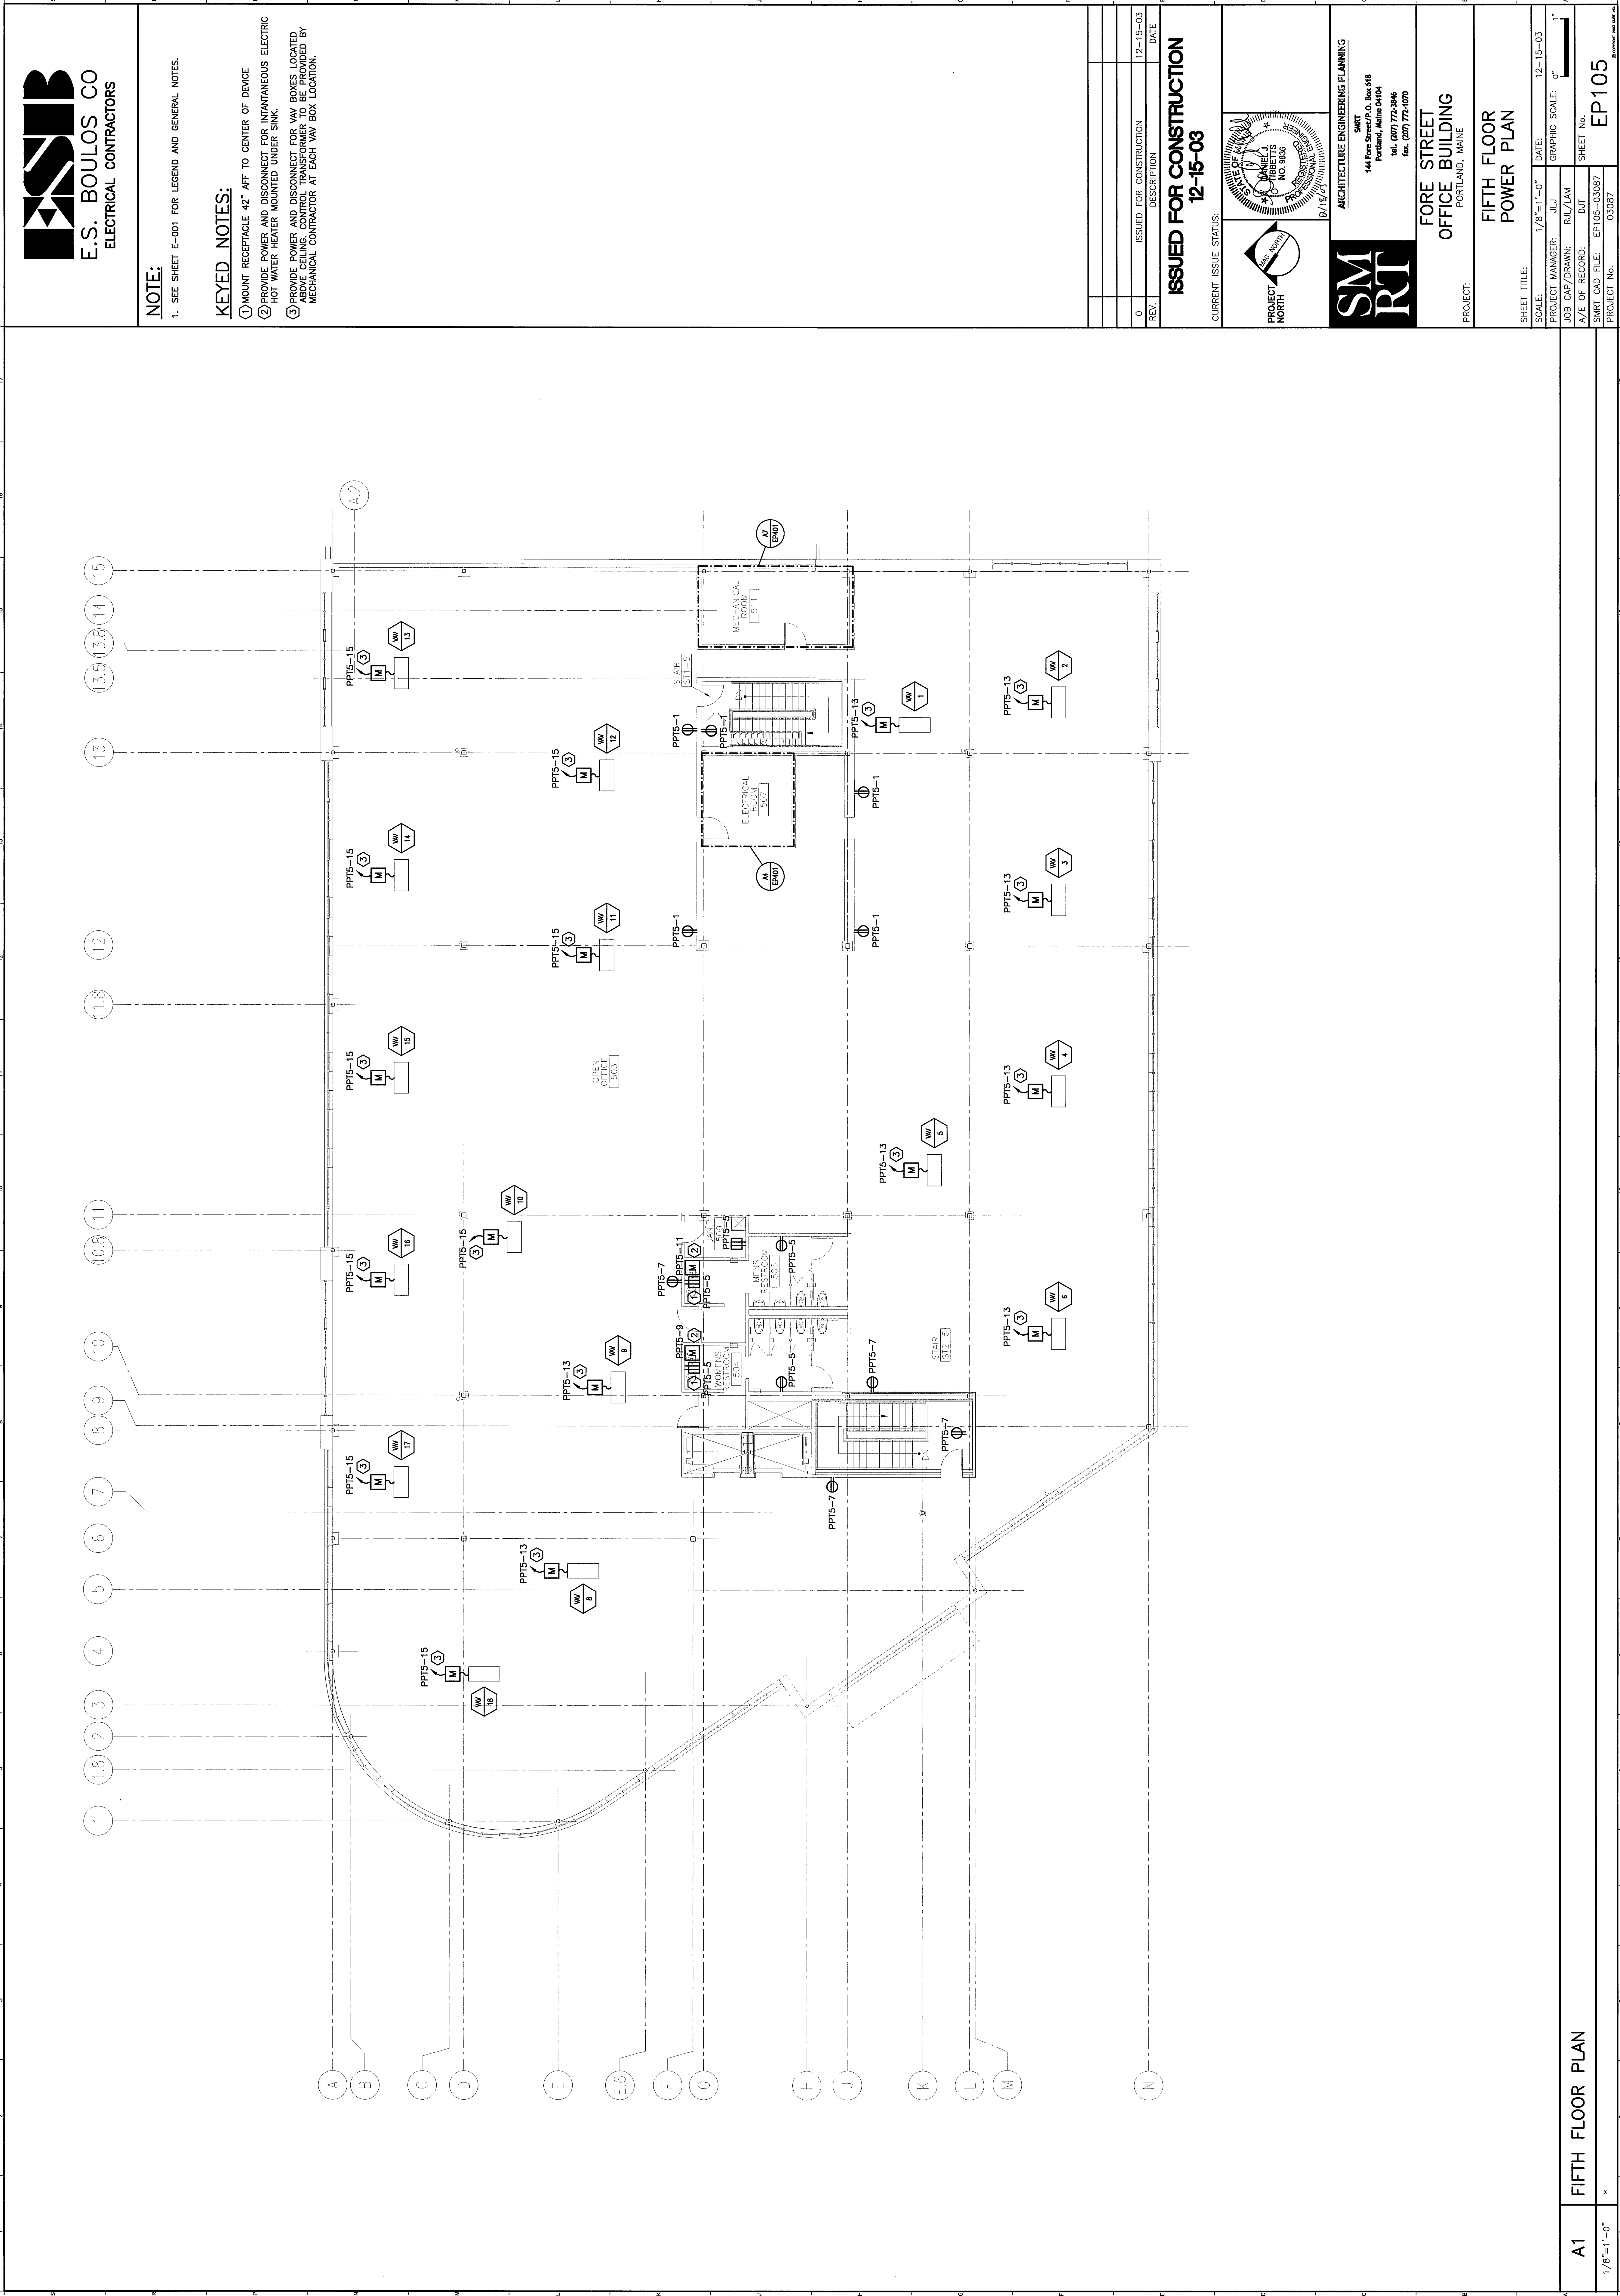

E.S. BOULOS CO
ELECTRICAL CONTRACTORS

NOTE:

1. SEE SHEET E-001 FOR LEGEND AND GENERAL NOTES.



KEYED NOTES:

- ① MOUNT RECEPTACLE 42" AFF TO CENTER OF DEVICE
- ② PROVIDE POWER AND DISCONNECT FOR INSTANTANEOUS ELECTRIC HOT WATER HEATER MOUNTED UNDER SINK.
- ③ PROVIDE POWER AND DISCONNECT FOR VAV BOXES LOCATED UNDER RECEPTION AREA. RECEPTACLES TO BE PROVIDED BY MECHANICAL CONTRACTOR AT EACH VAV BOX LOCATION.

REV.	DESCRIPTION	DATE
0	ISSUED FOR CONSTRUCTION	12-15-03

ISSUED FOR CONSTRUCTION
12-15-03

CURRENT ISSUE STATUS:

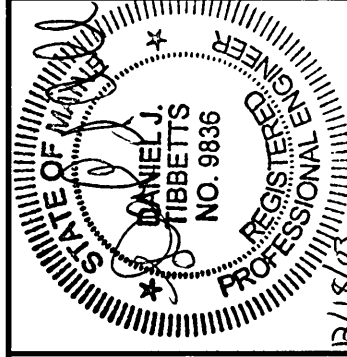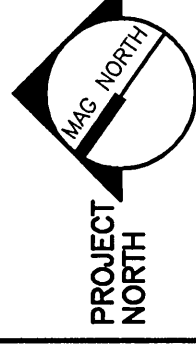

ARCHITECTURE ENGINEERING PLANNING
SMART
144 Fore Street P.O. Box 618
Portland, Maine 04101
Tel: (207) 772-3846
Fax: (207) 772-0070

FORE STREET
OFFICE BUILDING
PORTLAND, MAINE

FIFTH FLOOR
POWER PLAN

SHEET TITLE:	1/8"=1'-0"	DATE:	12-15-03
SCALE:	1/8"=1'-0"	GRAPHIC SCALE:	0' 1'
PROJECT MANAGER:	JLJ	JOB CAP/DRAWN:	RLJ/LAM
A/E OF RECORD:	DJT	SHEET No.	EP105
SMART CAD FILE:	EP105-03087	PROJECT No.	03087

A1 FIFTH FLOOR PLAN

1/8"=1'-0"