
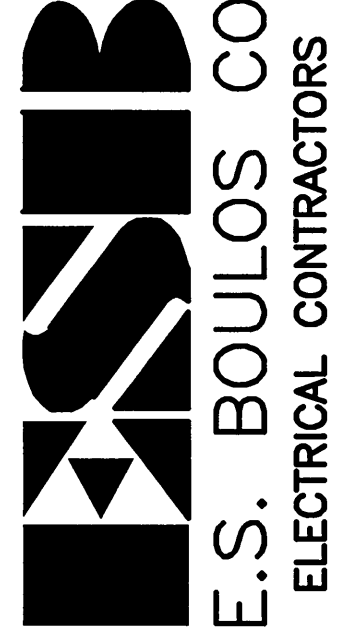


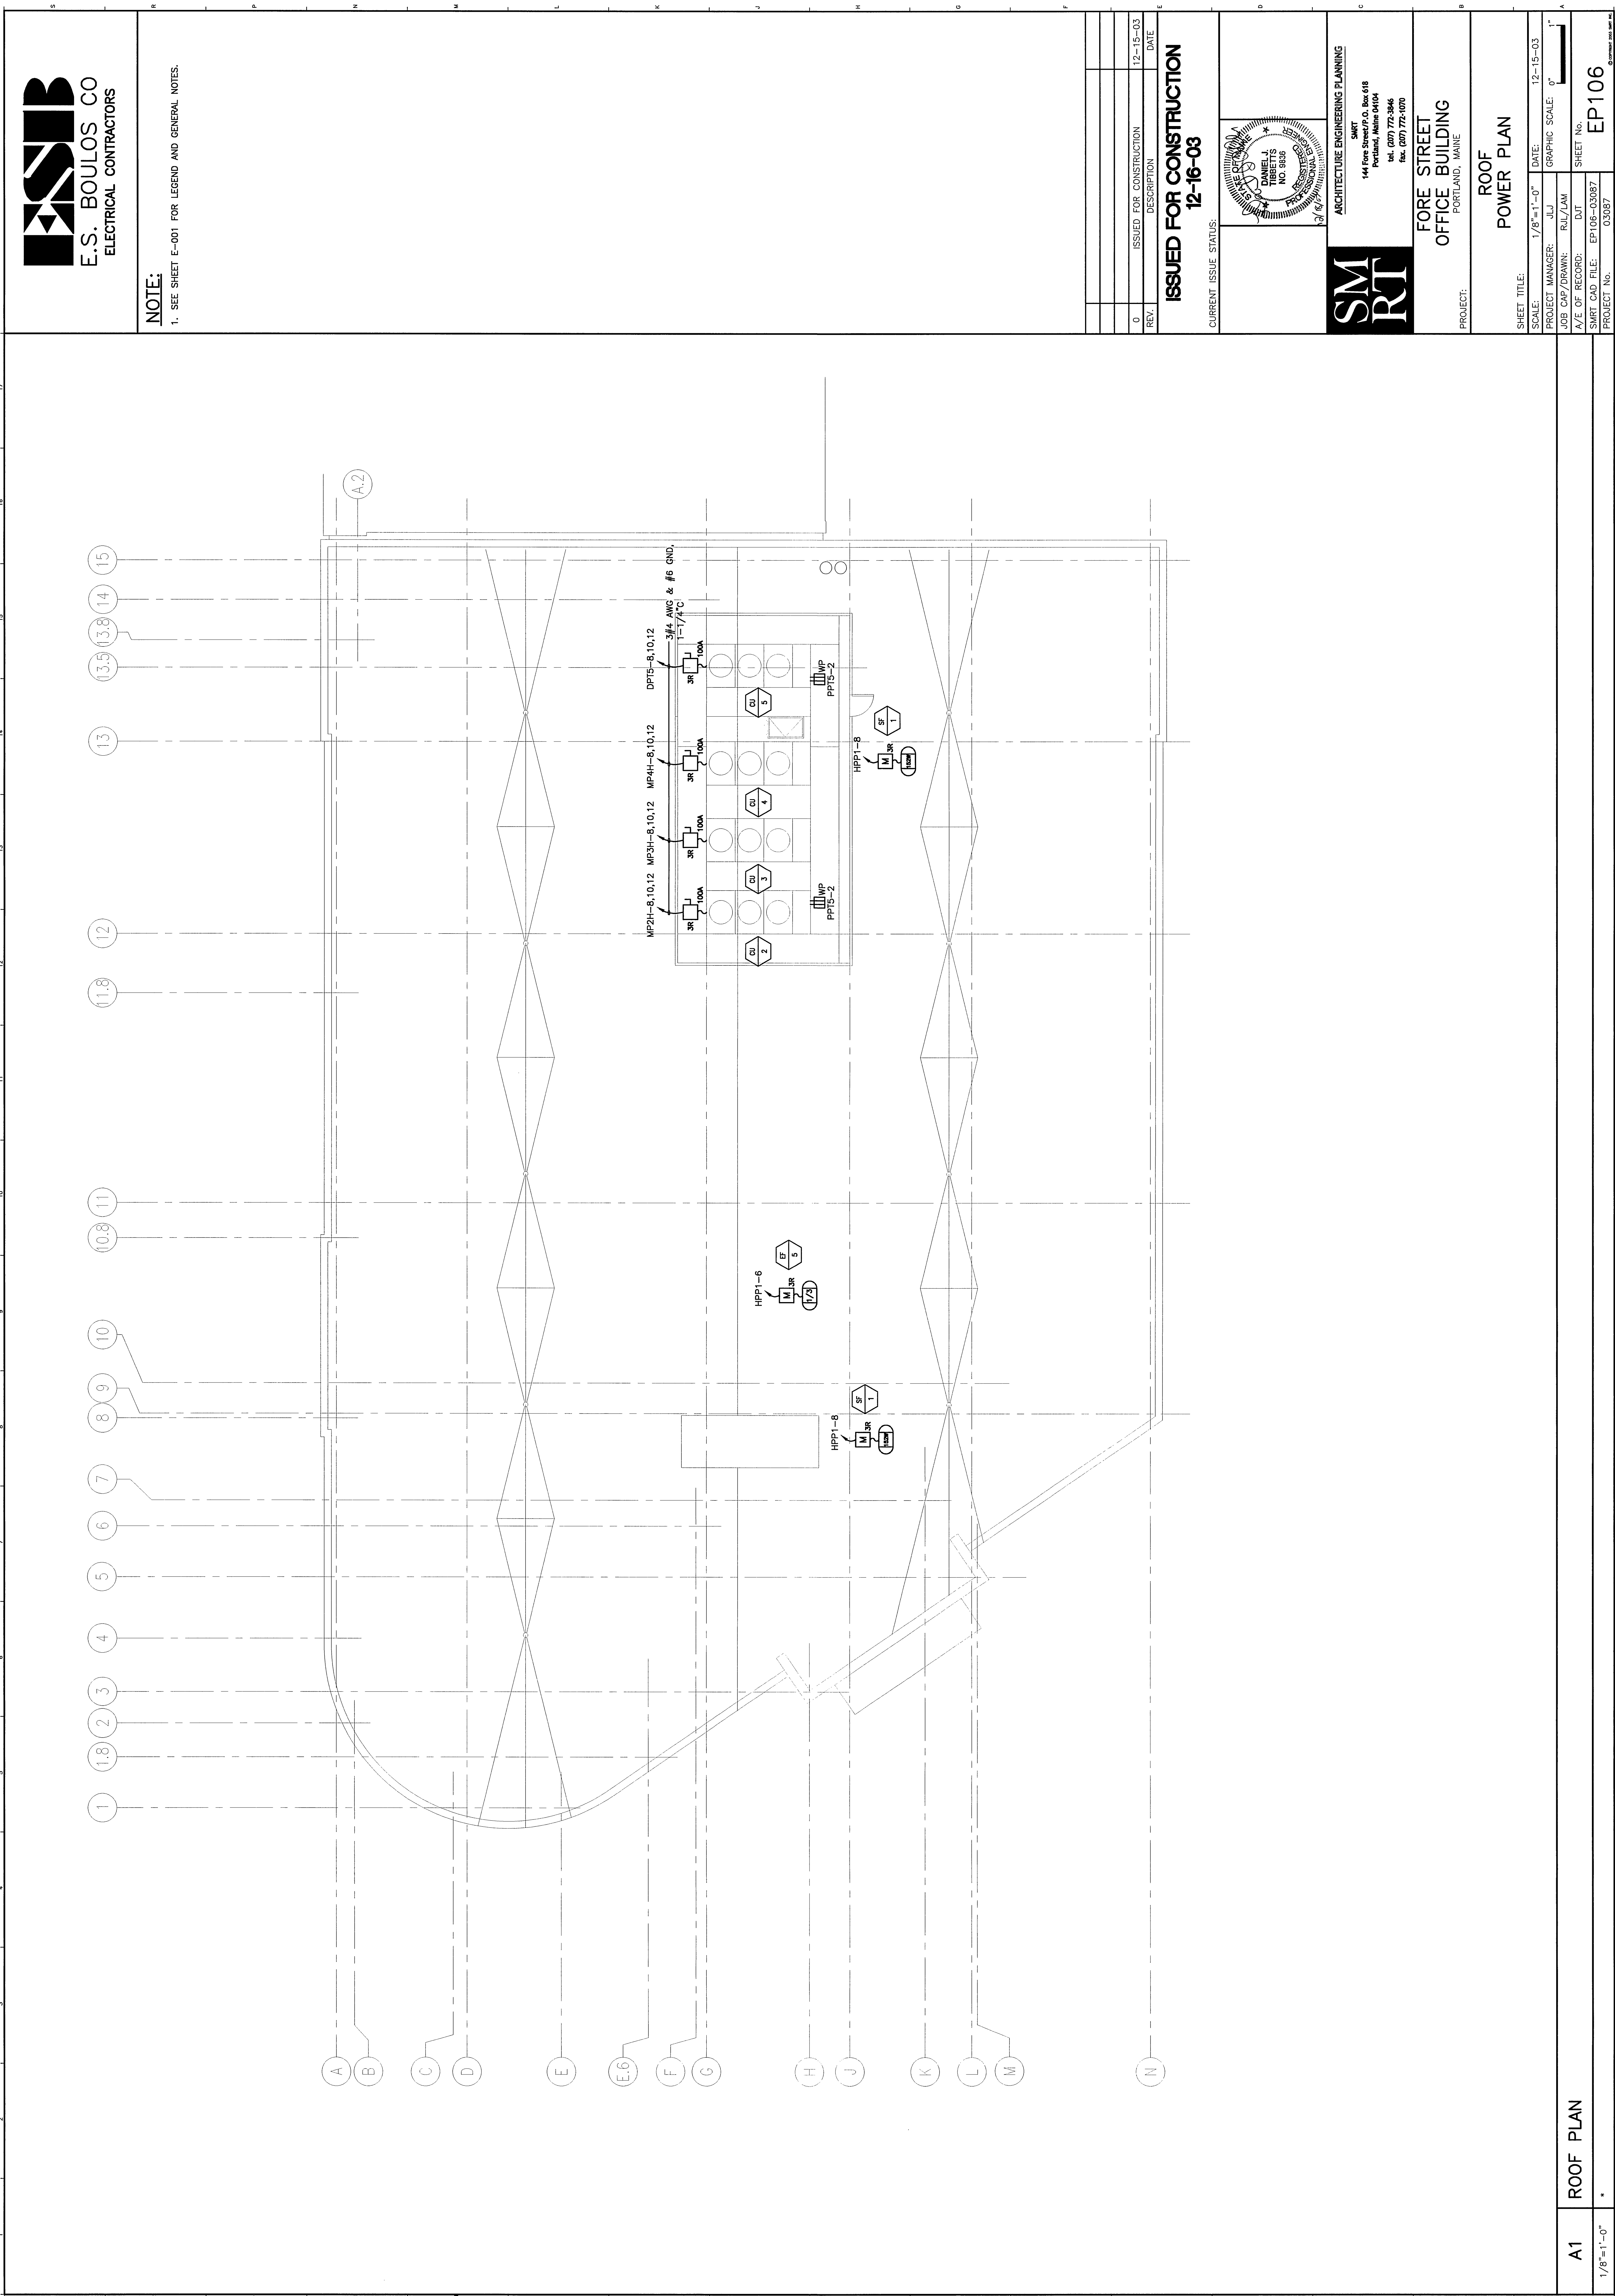


NOTE:
1. SEE SHEET E-001 FOR LEGEND AND GENERAL NOTES.

REV.	ISSUED FOR CONSTRUCTION	DESCRIPTION	DATE
0	ISSUED FOR CONSTRUCTION		12-15-03

ISSUED FOR CONSTRUCTION
12-16-03

CURRENT ISSUE STATUS:

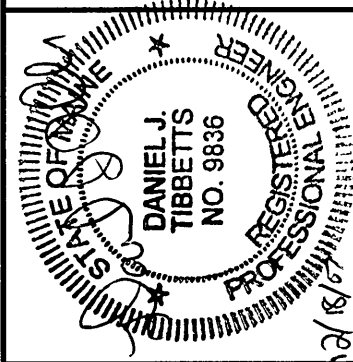

SM
RT
ARCHITECTURE ENGINEERING PLANNING
144 Elm Street, 3rd Floor
Portland, Maine 04104
Tel: (207) 775-3846
Fax: (207) 775-1070

FORE STREET
OFFICE BUILDING
PORTLAND, MAINE

ROOF
POWER PLAN

SHEET TITLE:	1/8"=1'-0"	DATE:	12-15-03
SCALE:	1/8"=1'-0"	GRAPHIC SCALE:	0' 1'
PROJECT MANAGER:	JLJ	JOB CAP/DRAWN:	RLJ/LAM
A/E OF RECORD:	DJT		
SNRT CAD FILE:	EP106-03087	SHEET No.	EP106
PROJECT No.	03087		

A1 ROOF PLAN

1/8"=1'-0"

*