


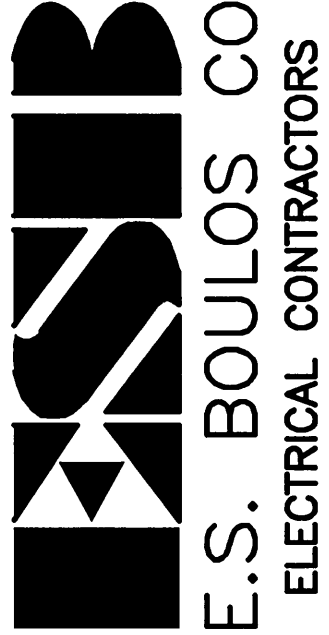


NOTE:

1. SEE SHEET E-001 FOR LEGEND AND GENERAL NOTES.

CABLE SCHEDULE:


- 1 > 4#4/0 AWG & #4 GND, 2-1/2°C
- 2 > 3#8 AWG & #10 GND, 3/4°C
- 3 > 4#2 AWG & #8 GND, 1-1/2°C
- 4 > 3#2 AWG & #8 GND, 1-1/2°C
- 5 NOT USED
- 6 > 3#4 AWG & #8 GND, 1°C
- 7 > 4#1/0 AWG & #6 GND, 2°C
- 8 > 4#350 MCM & #4 GND, 2-1/2°C
- 9 > 4#600 MCM/ft, 4#600 MCM NEUTRALS, 4-4°C
- 10 > 2#350 MCM/ft, 2#350 MCM NEUTRALS & 2#ft GND, 2-3°C
- 11 > 3#10 AWG & #10 GND, 3/4°C
- 12 > 4#8 AWG & #10 GND, 3/4°C

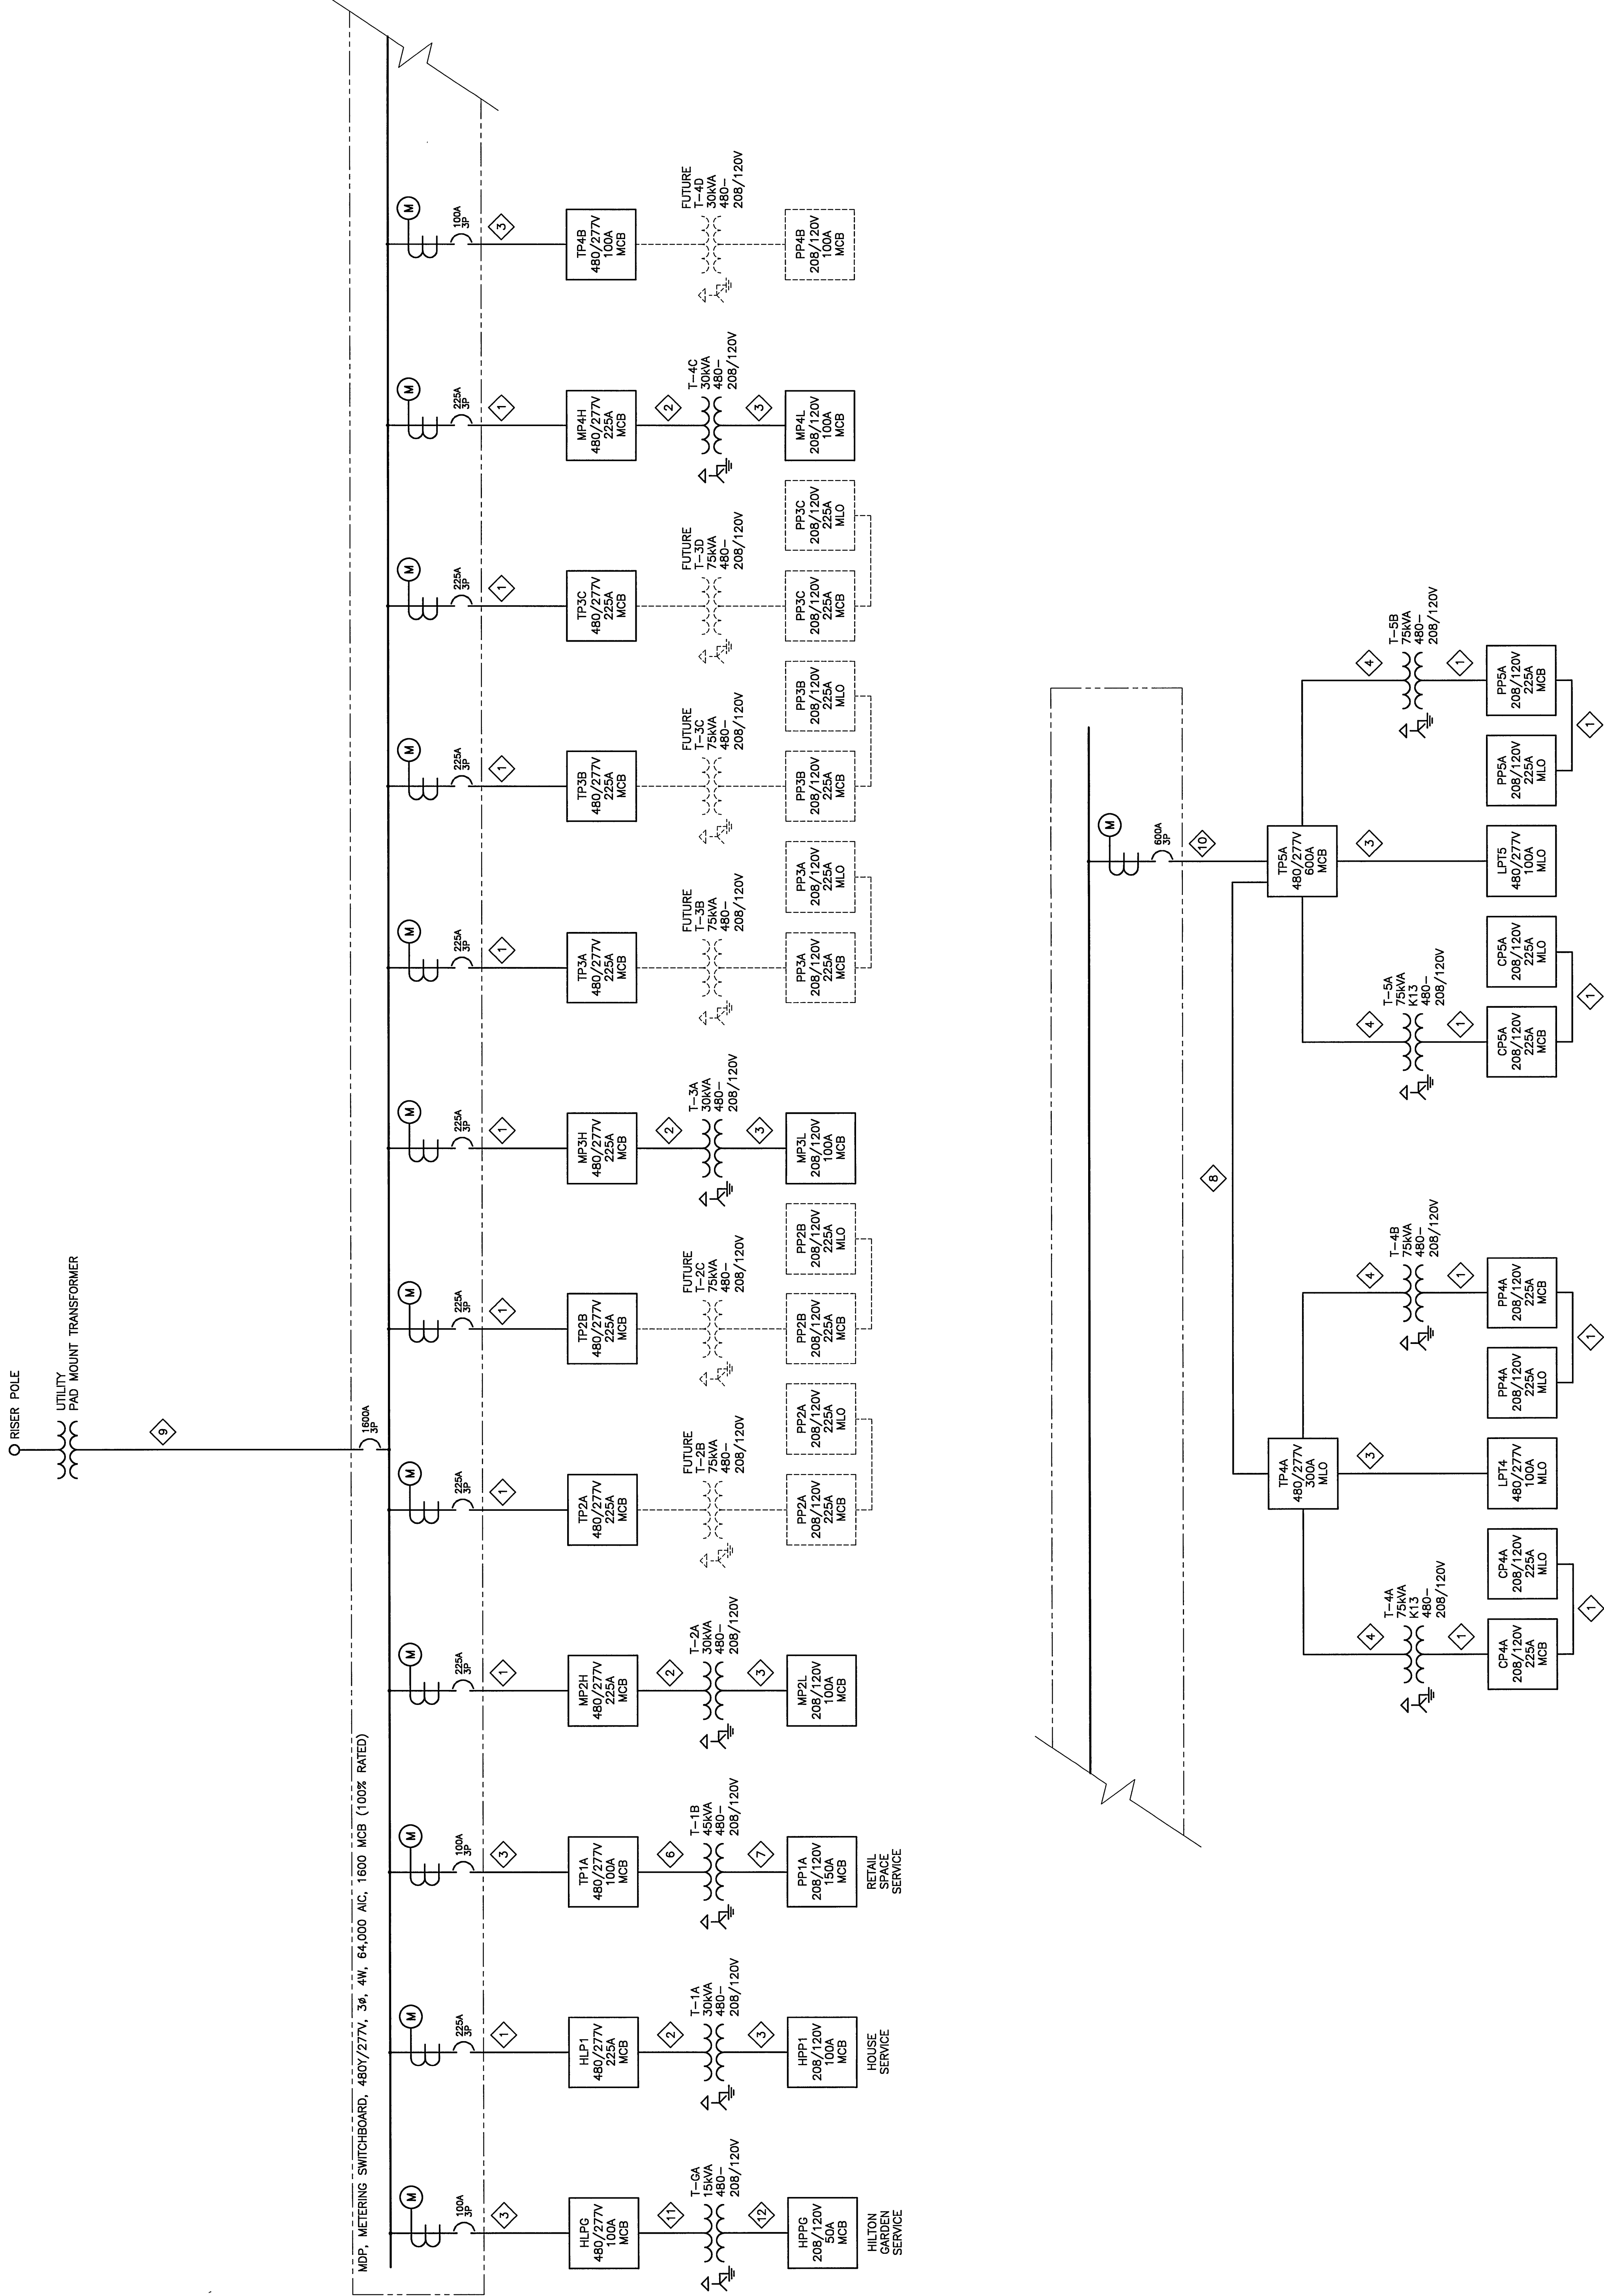

REV.	ISSUED FOR CONSTRUCTION	DATE
0	12-15-03	12-15-03

ISSUED FOR CONSTRUCTION
12-15-03

CURRENT ISSUE STATUS:

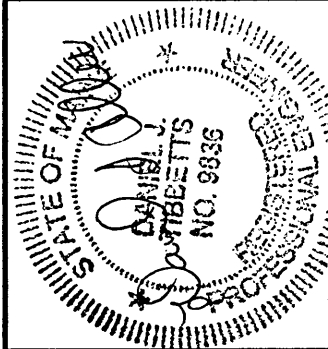

144 Fore Street P.O. Box 618
Portland, Maine 04104
tel. (207) 772-3846
fax. (207) 772-1070

FORE STREET
OFFICE BUILDING
PORTLAND, MAINE

ONE-LINE DIAGRAM

SHEET TITLE:	NONE	DATE:	12-15-03
SCALE:		GRAPHIC SCALE:	0"
PROJECT MANAGER:	JLJ	JOB CAP/DRAWN:	RJL/LAM
A/E OF RECORD:	DJT	SHEET No.	EP651
SMART CAD FILE:	EP651-03087	PROJECT No.	03087