


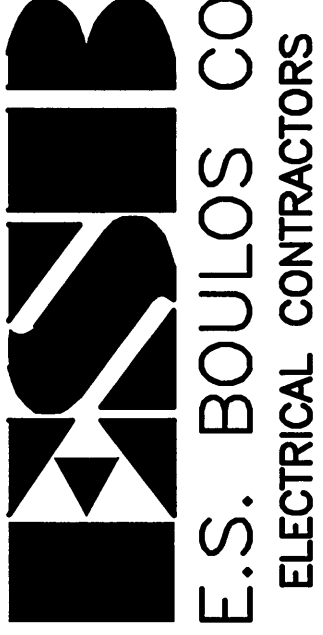

E.S. BOULOS CO  
ELECTRICAL CONTRACTORS

NOTES:

1. SEE SHEET E-001 FOR LEGEND AND GENERAL NOTES.
2. PROVIDE TRANSFORMER PAD (BY SITE CONTRACTOR) FOR NEW WITH 100% OVERTRANSFORMER. GROUND IN ACCORDANCE WITH CMP STANDARDS.
3. ESB TO FURNISH NEW LIGHT POLES AND WIRE FIXTURES (FIXTURE TO BE DETERMINED BY OWNER) AND ALL NECESSARY CABLES AND FITTINGS FROM CMP. CITY OF PORTLAND TO ASSUME ENERGY COST OR LEASE OF


KEYED NOTES:

- ① EXTEND FOUR 4" CONDUITS INTO VERIZON MANHOLE ON COMMERCIAL STREET. COORDINATE WORK WITH VERIZON.
- ② NEW UTILITY TRANSFORMER WIRING TO BE CONNECTED BY CMP. COORDINATE ANY REQUIRED OUTAGES W/OWNER.
- ③ EXTEND GROUNDING CONDUCTOR UP TO MDP AND BOND TO METERING SWITCHBOARD GROUND BUS. IN ADDITION FOR FLOORS 2-5 BOND TO COLUMN J13 AND LEAVE 5" PIG TAIL FOR TENANTS TO USE FOR TELECOMMUNICATIONS BONDING.

| REV. | DESCRIPTION             | DATE     |
|------|-------------------------|----------|
| 0    | ISSUED FOR CONSTRUCTION | 12-15-03 |

ISSUED FOR CONSTRUCTION  
12-15-03

CURRENT ISSUE STATUS:

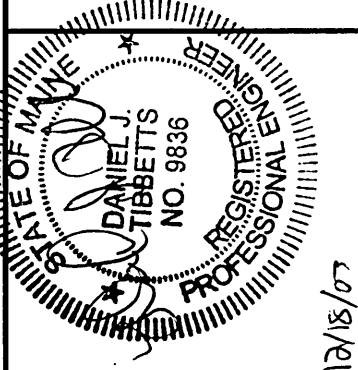

SMI  
RT  
ARCHITECTURE ENGINEERING PLANNING  
SMART  
144 Fore Street/P.O. Box 618  
Portland, Maine 04104  
tel. (207) 772-3846  
fax. (207) 772-1070

FORE STREET  
OFFICE BUILDING  
PORTLAND, MAINE

SITE PLAN

|                 |                  |             |                                                                                                         |       |          |
|-----------------|------------------|-------------|---------------------------------------------------------------------------------------------------------|-------|----------|
| SHEET TITLE:    |                  | 1"=20'      |                                                                                                         | DATE: | 12-15-03 |
| SCALE:          | PROJECT MANAGER: | JUL         | GRAPHIC SCALE: 0"  1" |       |          |
| JOB CAP/DRAWN:  | LAM              | SHEET No.   |                                                                                                         |       |          |
| A/E OF RECORD:  | DJT              | ES102       |                                                                                                         |       |          |
| SMART CAD FILE: | ES102-03087      | PROJECT No. |                                                                                                         |       |          |
| PROJECT No.     | 03087            | 03087       |                                                                                                         |       |          |

