

NOTE:

1. SEE SHEET E-001 FOR LEGEND AND GENERAL NOTES.


KEYED NOTE:

Ⓢ PROVIDE EMPTY OUTLET BOX & 3/4" CONDUIT TO ABOVE CEILING FOR FUTURE TENANT CARD READER. MOUNT BOX 48" AFF TO CENTER OF DEVICE.

REV.	ISSUED FOR CONSTRUCTION	DESCRIPTION	DATE
0			12-15-03

ISSUED FOR CONSTRUCTION
12-15-03

CURRENT ISSUE STATUS:

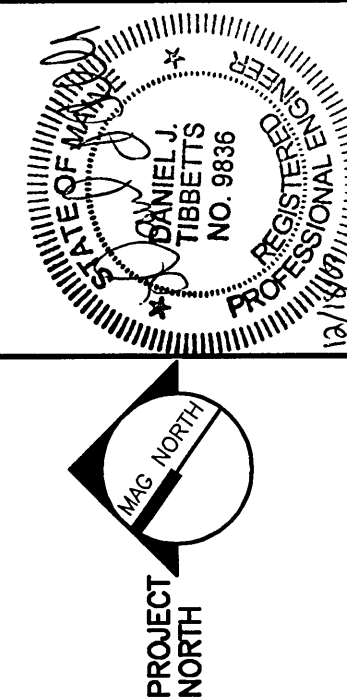

SM
RT
ARCHITECTURE ENGINEERING PLANNING
144 Fore Street, P.O. Box 618
Portland, Maine 04104
tel. (207) 772-3846
fax. (207) 772-1070

**FORE STREET
OFFICE BUILDING**
PORTLAND, MAINE

**FIRST FLOOR
SYSTEMS PLAN**

SHEET TITLE:	DATE:	12-15-03
SCALE:	1/8"=1'-0"	GRAPHIC SCALE: 0'
PROJECT MANAGER:	JULI	
JOB CAP/DESIGN:	RLJ/LAM	
DATE OF RECORD:	DDT	
SMART CAD FILE:	EY101-03087	
PROJECT No.	03087	
SHEET No.	EY101	

A1 FIRST FLOOR PLAN

1/8"=1'-0"

