



KEYED NOTE:


1 PROVIDE EMPTY OUTLET BOX & 3/4" CONDUIT TO ABOVE CEILING FOR FUTURE TENNANT CARD READER. MOUNT BOX 48" AFF TO CENTER OF DEVICE.

[illegible]

ISSUED FOR CONSTRUCTION
12-15-03



PROJECT NORTH

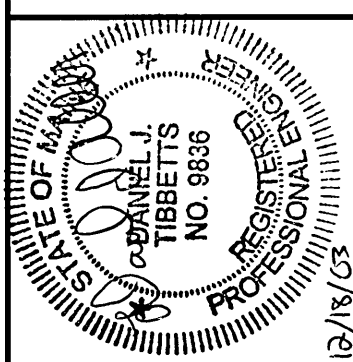

SM


ARCHITECTURE ENGINEERING PLANNING

SWKI
144 Fore Street/P.O. Box 618
Portland, Maine 04104
tel. (207) 772-3846
fax. (207) 772-1070

**FORE STREET
OFFICE BUILDING**
PORTLAND, MAINE

THIRD FLOOR
SYSTEMS PLAN

SHEET TITLE:		1/8" = 1' - 0"		DATE:	12-15-03
PROJECT:		JLJ/LAM		GRAPHIC SCALE:	0"  1"
JOB CAP/DRAWN:		DJT		SHEET No.	
A/E OF RECORD:		DJT		EY103	
SHEET CAD FILE:		EY103-03087		PROJECT No.	
DRAWN FILE:		03087		© 2004 EY 103	

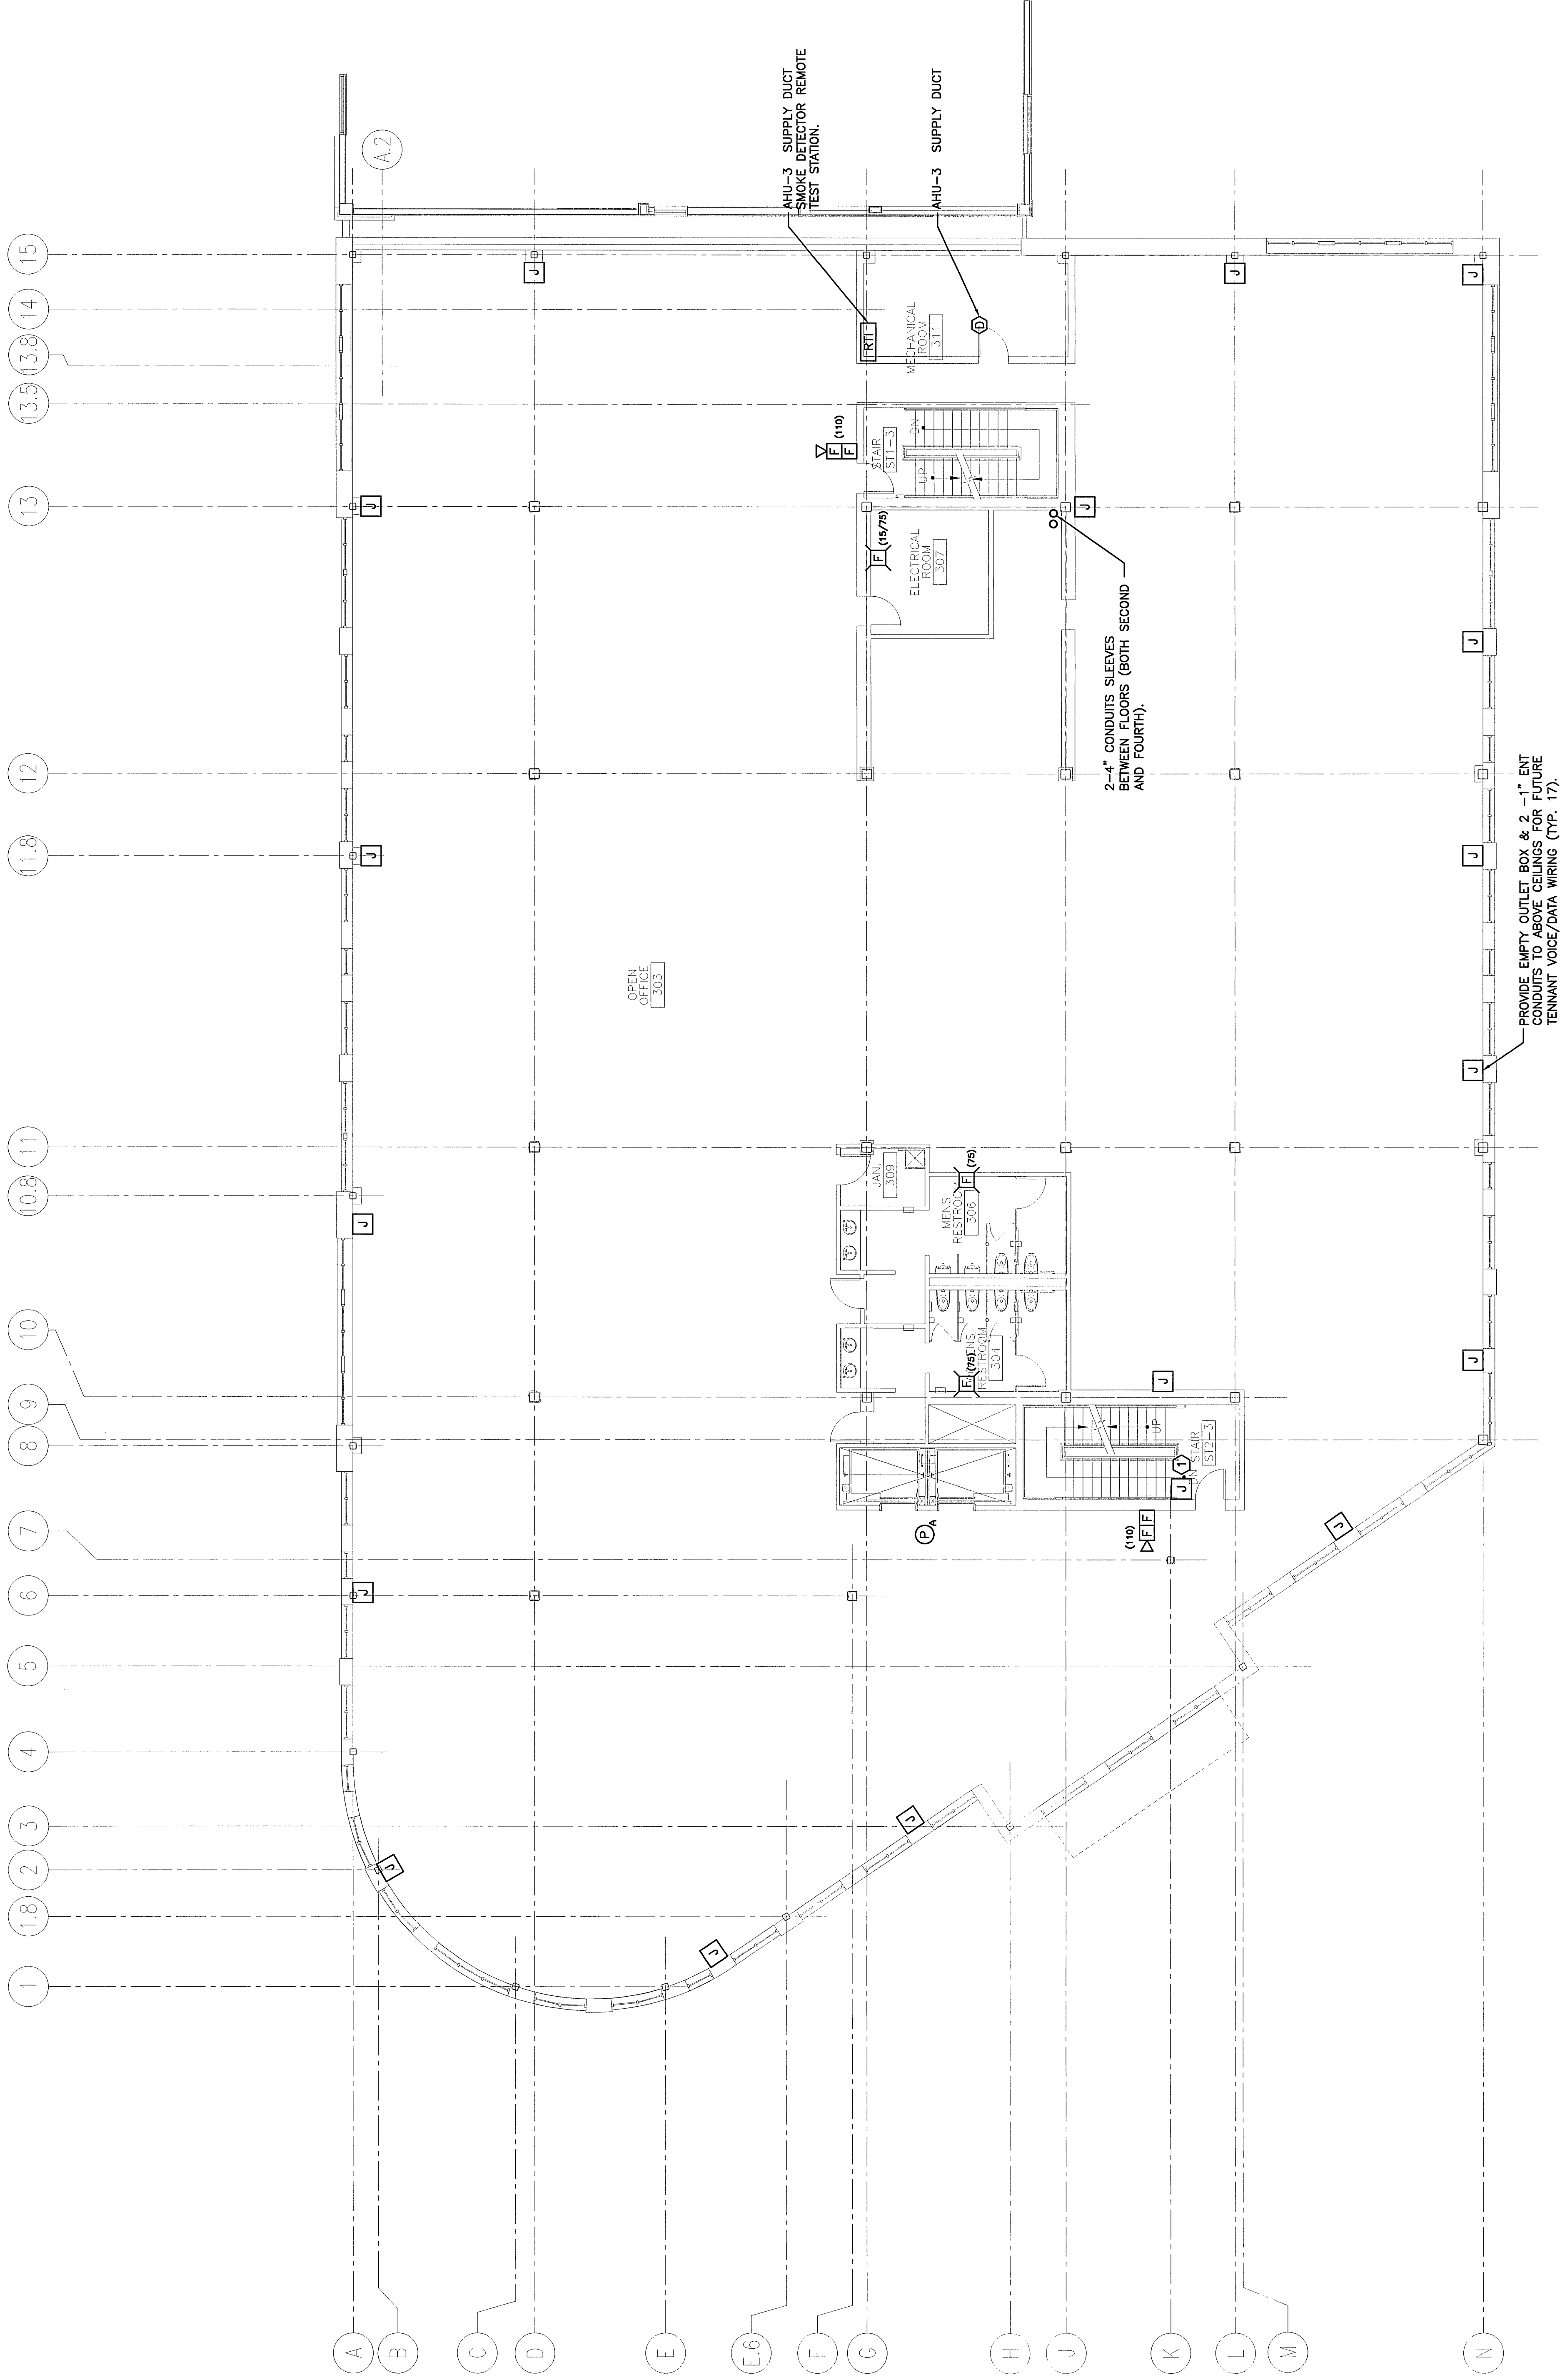

THIRD FLOOR PLAN

 $1/8''=1'-0''$