



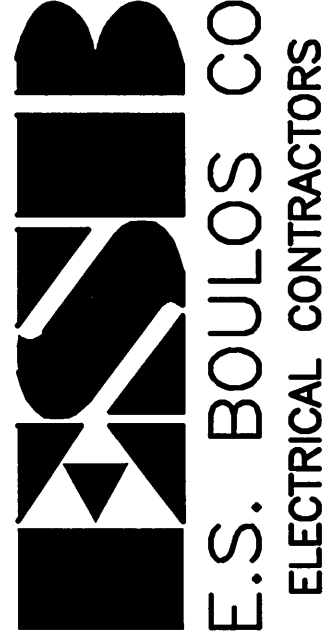

NOTE:
1. SEE SHEET E-001 FOR LEGEND AND GENERAL NOTES.

KEYED NOTE:
① PROVIDE EMPTY OUTLET BOX AND 3/4" CONDUIT TO ABOVE CEILING FOR CADD READER SYSTEM. MOUNT JUNCTION BOX 48" AFF TO CENTER OF DEVICE.

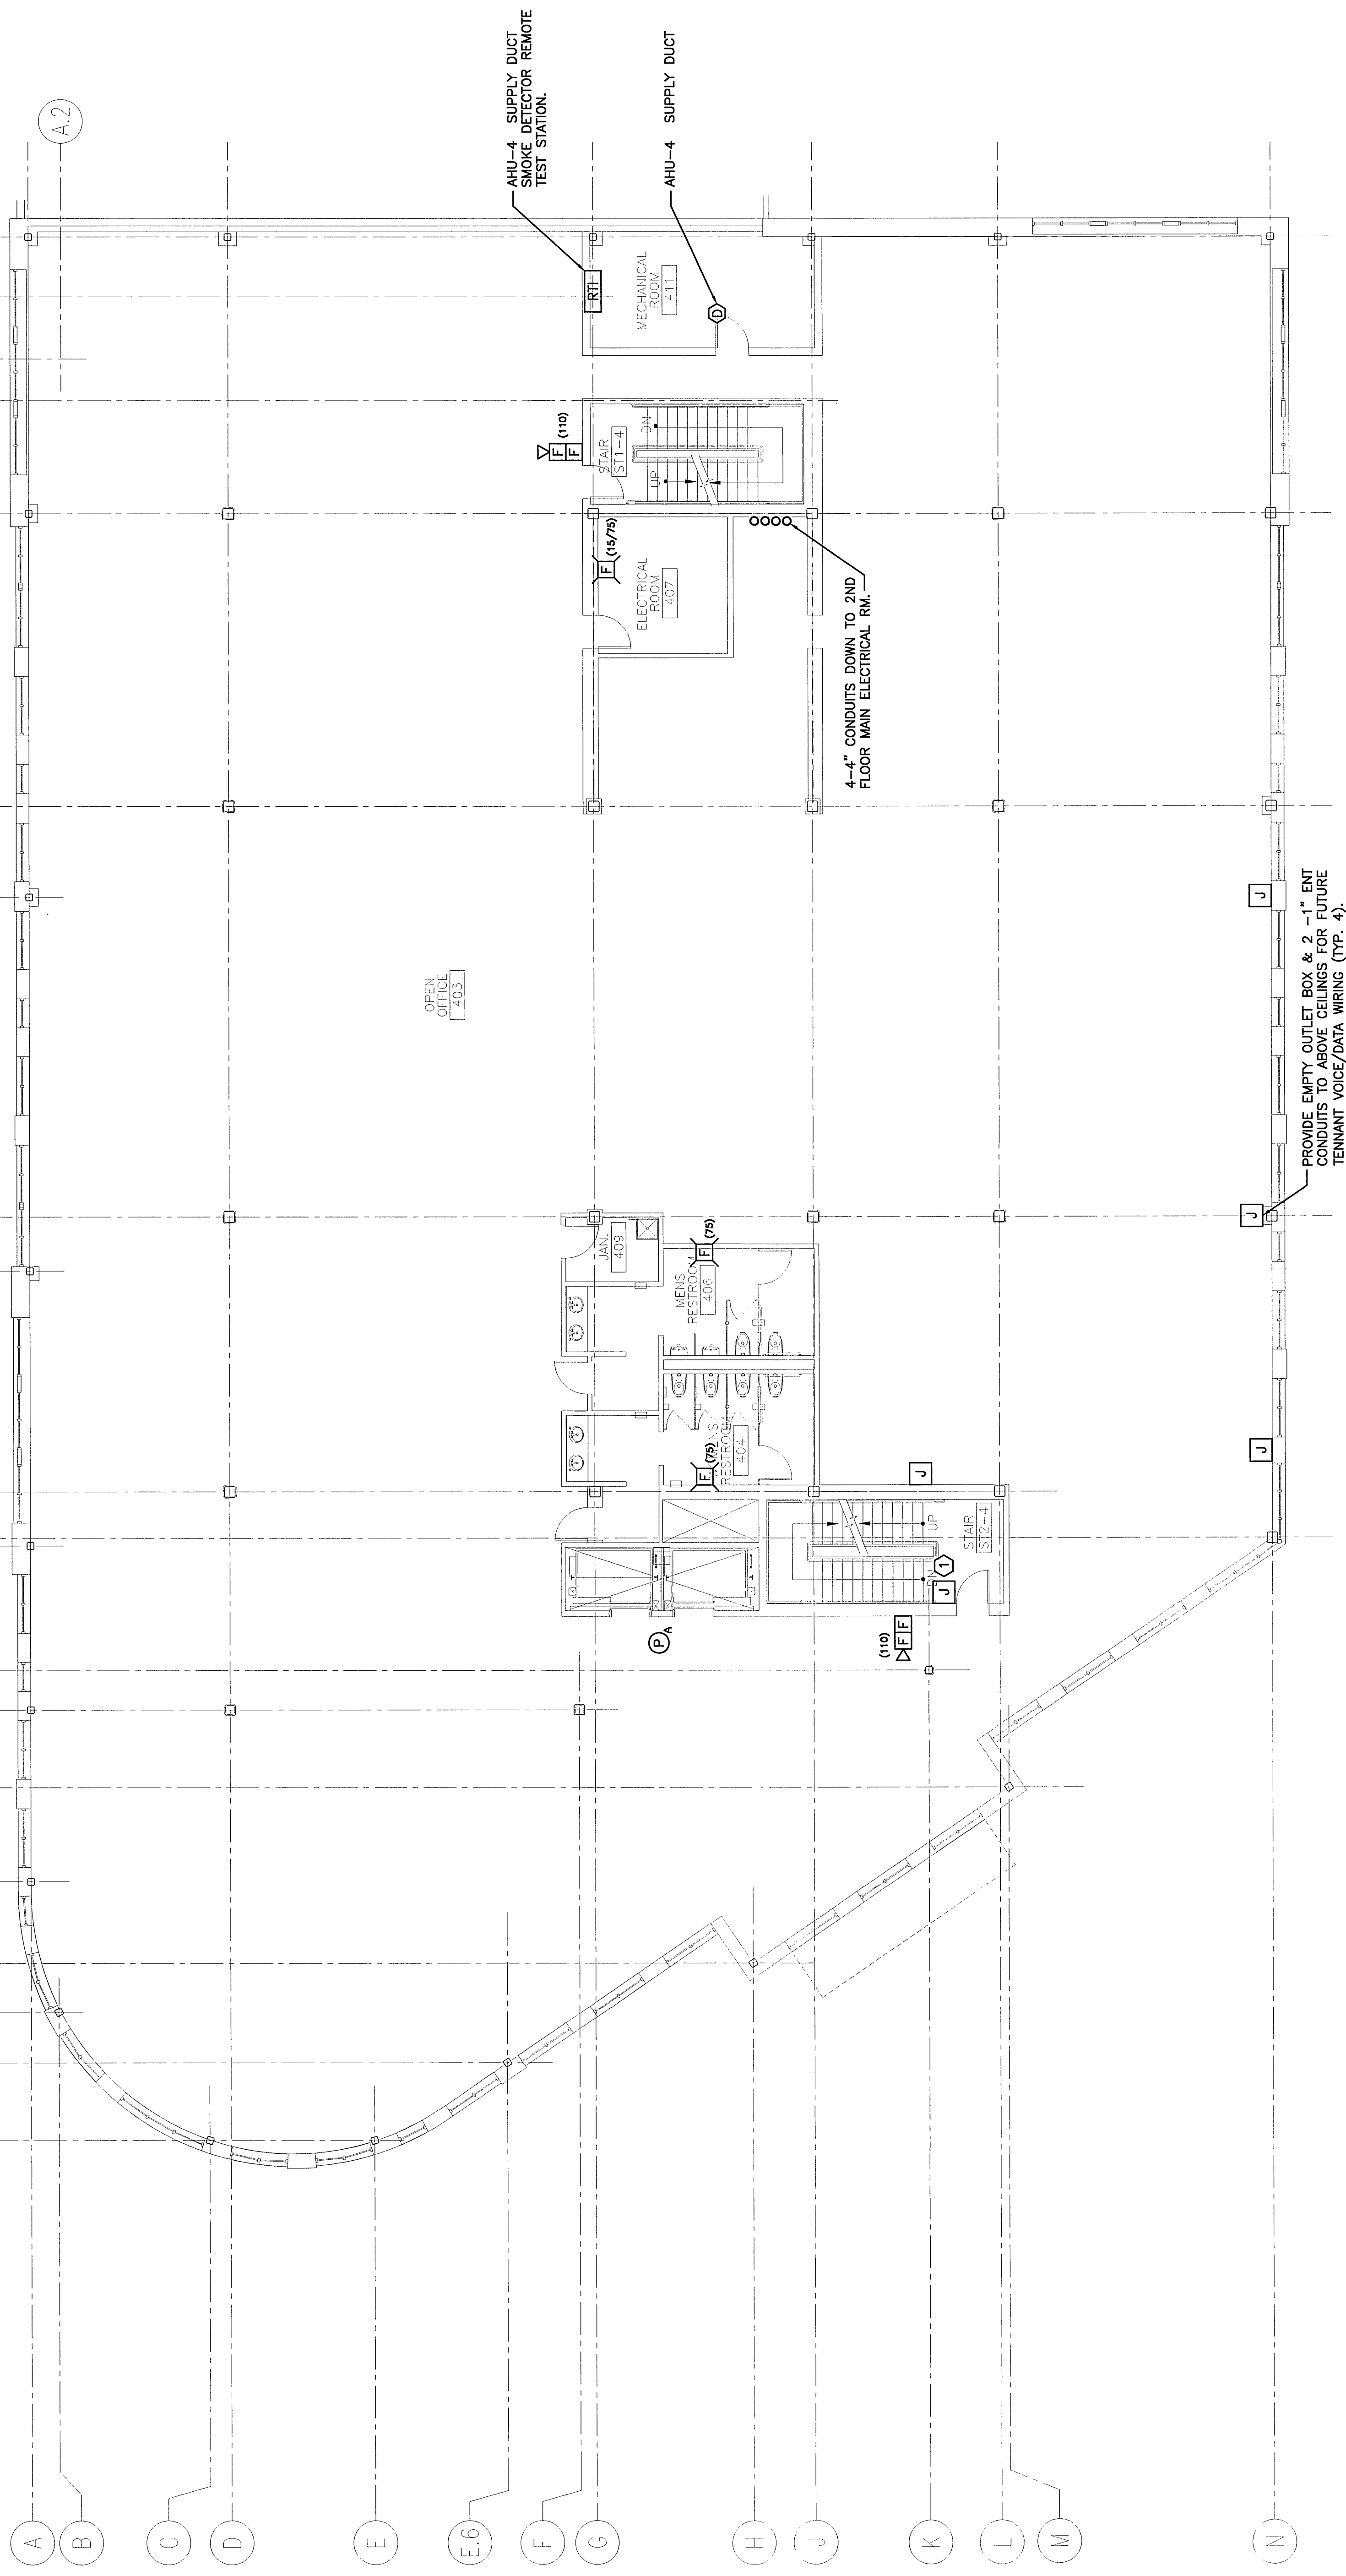

REV.	ISSUED FOR CONSTRUCTION	DESCRIPTION	DATE
0			12-15-03

ISSUED FOR CONSTRUCTION
12-15-03

CURRENT ISSUE STATUS:

PROJECT NORTH

ARCHITECTURE ENGINEERING PLANNING
SM RT
144 Elm Street, 8th Fl., Box 618
Portland, Maine 04104
tel. (207) 772-3846
fax. (207) 772-1070

PROJECT:
FORE STREET
OFFICE BUILDING
PORTLAND, MAINE

PROJECT TITLE:
FOURTH FLOOR
SYSTEMS PLAN

SHEET TITLE:	SCALE:	DATE:	GRAPHIC SCALE:
FOURTH FLOOR SYSTEMS PLAN	1/8"=1'-0"	12-15-03	0"
PROJECT MANAGER:	JUL		
DES. CAPT/DRAWN:	RL/LAM		
DATE OF RECORD:	DJT		
SMART CAD FILE:	EY104-03087		
PROJECT No.	03087		

A1 FOURTH FLOOR PLAN

1/8"=1'-0"

SHEET No.

EY104