


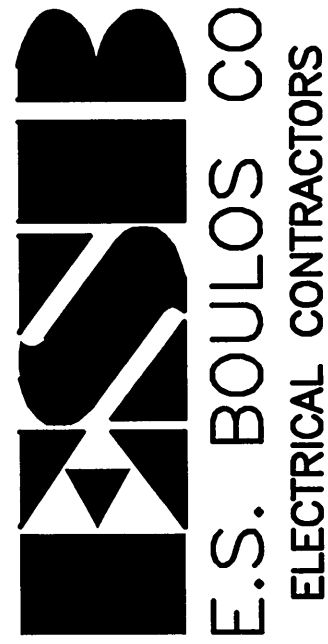


NOTE:


1. SEE SHEET E-001 FOR LEGEND AND GENERAL NOTES.

KEYED NOTES:

- ① DUCT SMOKE DETECTORS TO SHUT DOWN FAN OR MECHANICAL EQUIPMENT SHOWN AND REPORT A TROUBLE SIGNAL TO THE FIRE ALARM CONTROL PANEL. DUCT SMOKE DETECTORS SHALL WORK WITH MECHANICAL CONTRACTOR.
- ② SPRINKLER TAMPER SWITCH LOCATIONS SHOWN ON FIRE ALARM CONTROL PANEL. TAMPER SWITCH ACTIVATION SHALL REPORT A TROUBLE SIGNAL TO THE FIRE ALARM CONTROL PANEL. TAMPER SWITCHES SHALL NOT INITIATE EVACUATION ALARMS.
- ③ SPRINKLER PRESSURE SWITCH LOCATIONS SHOWN ON FIRE ALARM CONTROL PANEL. PRESSURE SWITCH INDICATES SPRINKLER SYSTEM CONTRACTOR. PRESSURE SWITCH INDICATES SPRINKLER FLOW AND SHALL REPORT AN ALARM CONDITION TO THE FIRE ALARM CONTROL PANEL AND ACTIVATE EVACUATION ALARMS.
- ④ HEAT DETECTORS TO BE TIED INTO ELEVATOR CONTROL PANEL AND ENERGIZE ELEVATOR SHUNT TRIP CIRCUIT BREAKER COIL. HEAT DETECTORS SHALL WORK WITH ELEVATOR INSTALLER AND ELEVATOR INSPECTOR.
- ⑤ SMOKE DETECTORS TO BE TIED INTO ELEVATOR CONTROL PANEL FOR ELEVATOR RECALL FUNCTION. COORDINATE ALL WORK WITH ELEVATOR INSTALLER AND ELEVATOR INSPECTOR.
- ⑥ NOT USED
- ⑦ NOTIFICATION DEVICES SHALL BE PROVIDED WITH SEPARATE POWER SUPPLY. NOTIFICATION DEVICES SHALL BE TIED INTO ELEVATOR CONTROL PANEL. AFTER HORNS ARE SILENCED UNTIL FIRE ALARM CONTROL PANEL IS RESET.
- ⑧ COORDINATE WITH OWNER FOR CONTACT INFORMATION ON OWNERS FIRE ALARM SYSTEM MONITORING SERVICE.

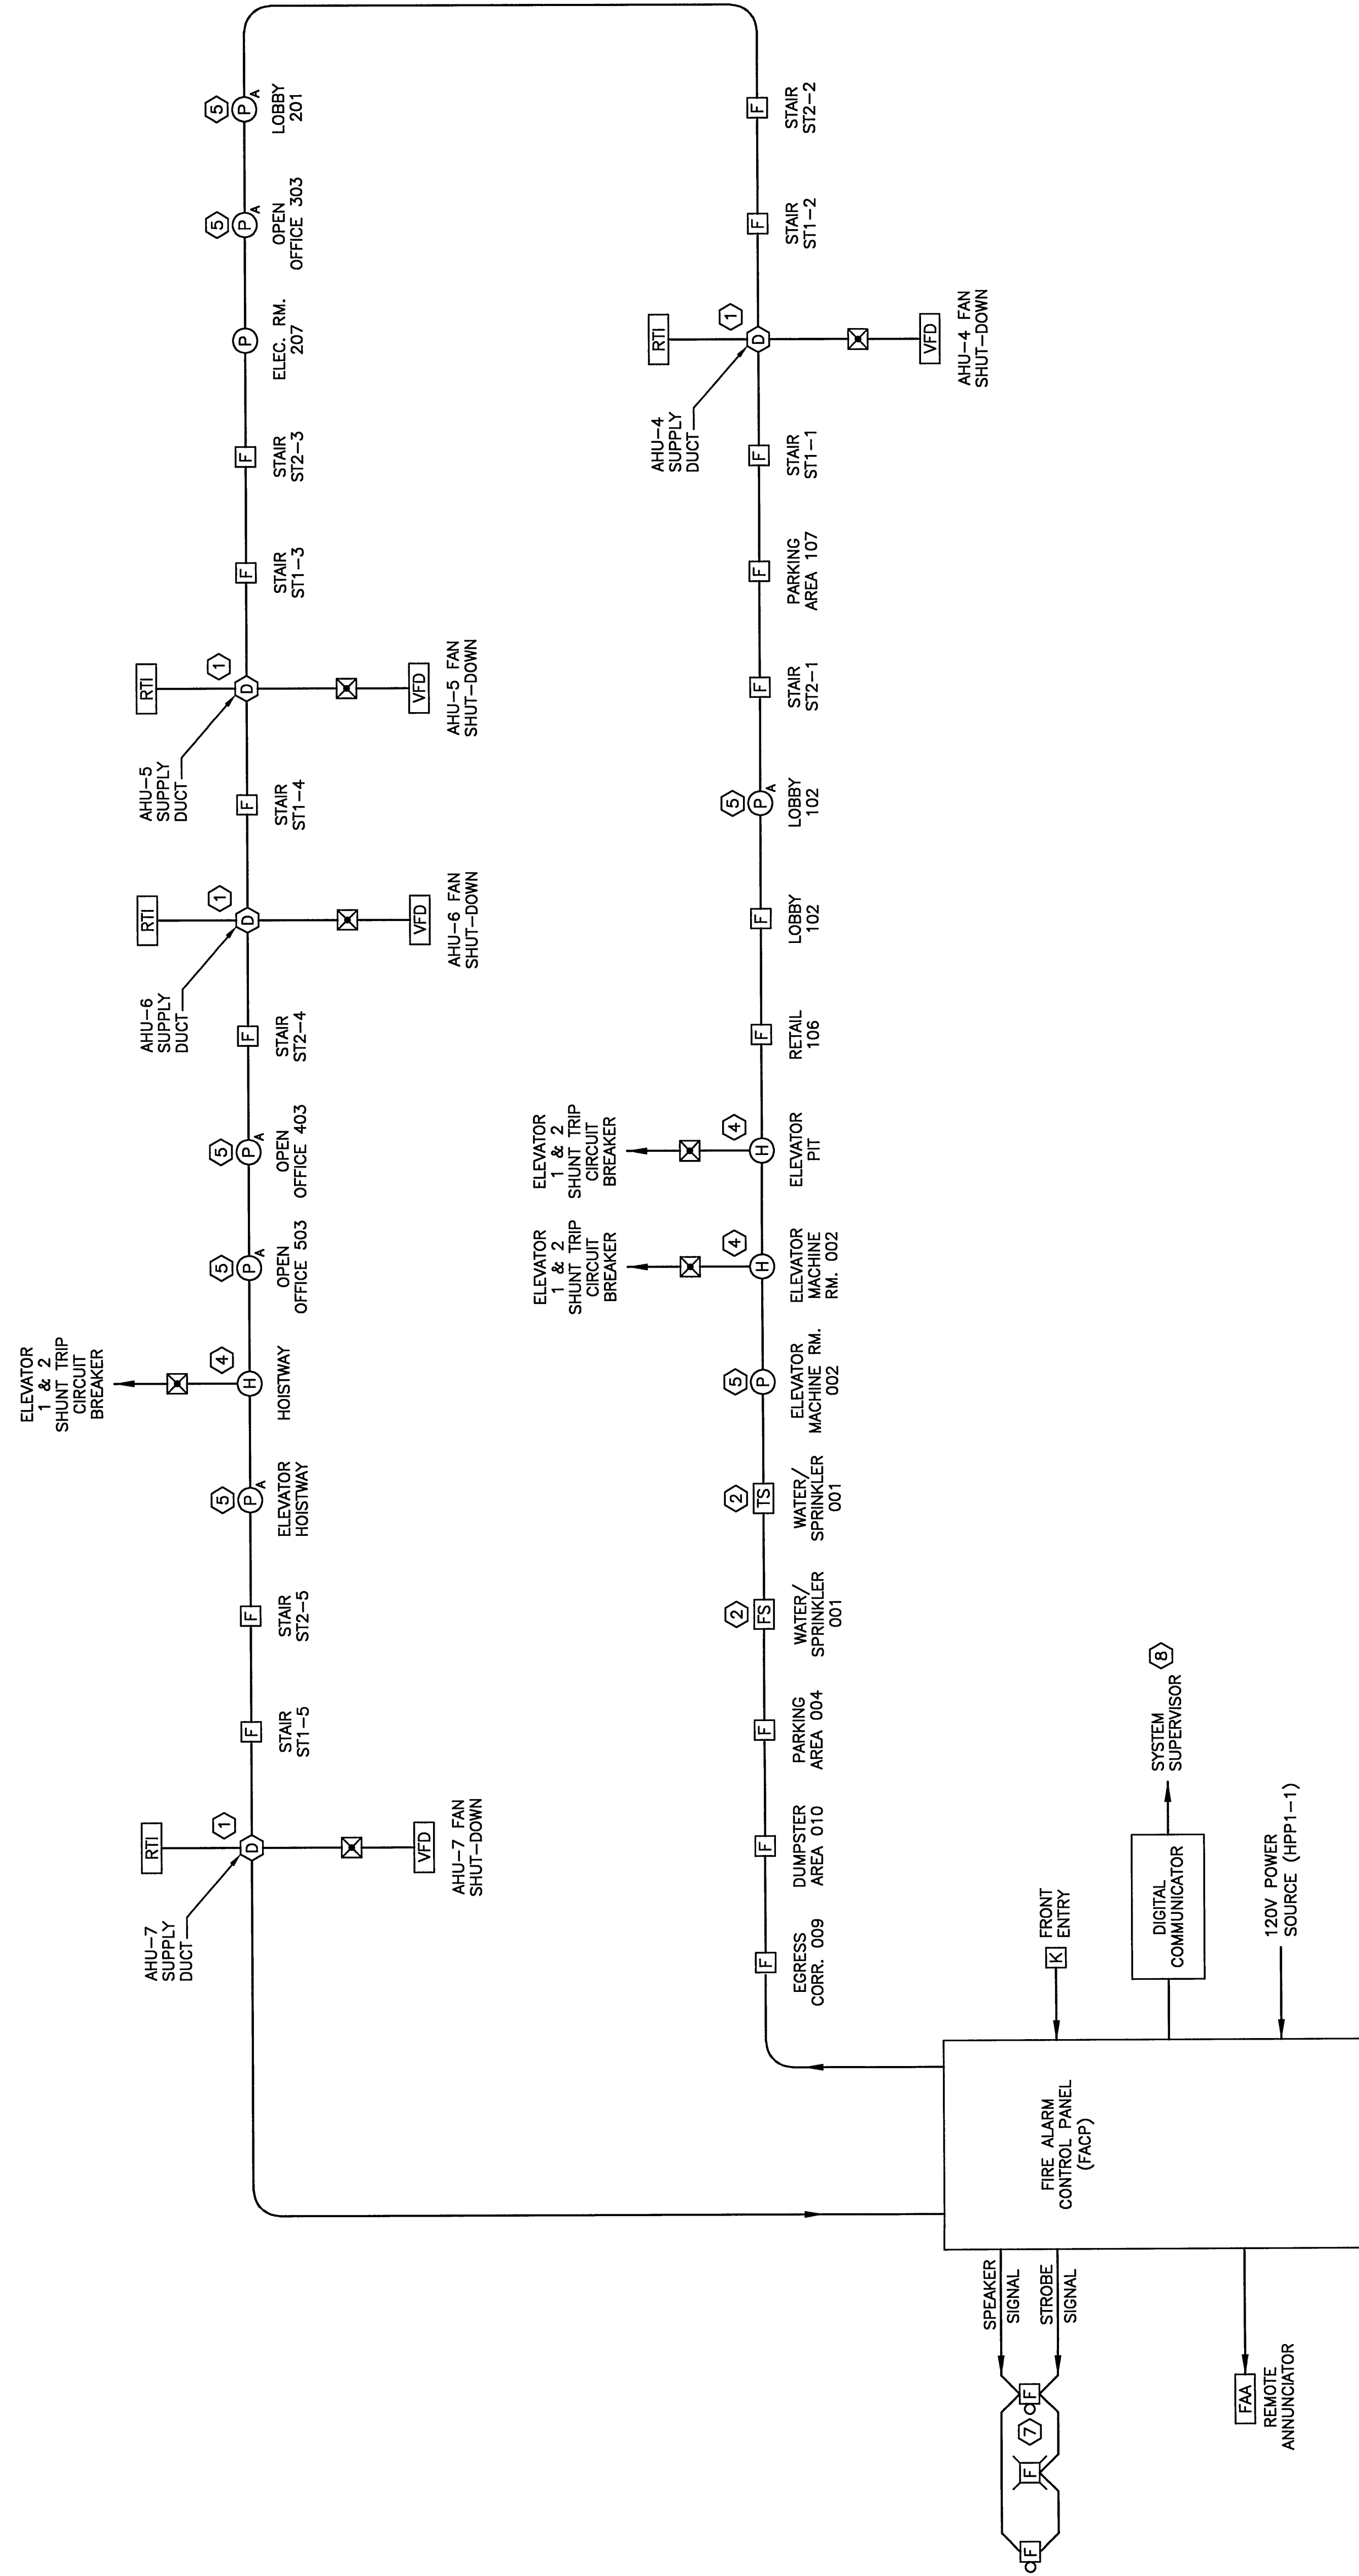[illegible]

CURRENT ISSUE STATUS:

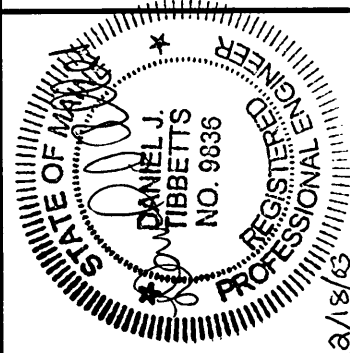

ARCHITECTURE ENGINEERING PLANNING

SMART
144 Fore Street/P.O. Box 618
Portland, Maine 04104
tel. (207) 772-3846
fax. (207) 772-1070

**FORE STREET
OFFICE BUILDING**
PORTLAND, MAINE

PORTLAND, MAINE
FIRE ALARM
RISER DIAGRAM

SHEET TITLE:		DATE: 12-15-03	
SCALE:	NONE	GRAPHIC SCALE: 0" = 1"	
PROJECT MANAGER:	JIJ	FA601 SHEET No.	
JOB CAP/DRAWN:	RUL/AM		
A/E OF RECORD:	DIT		
SMART CARD FILE:	FA601-03087		
PROJECT NO.	03087		