


**FIRST FLOOR PLAN**

**A1**

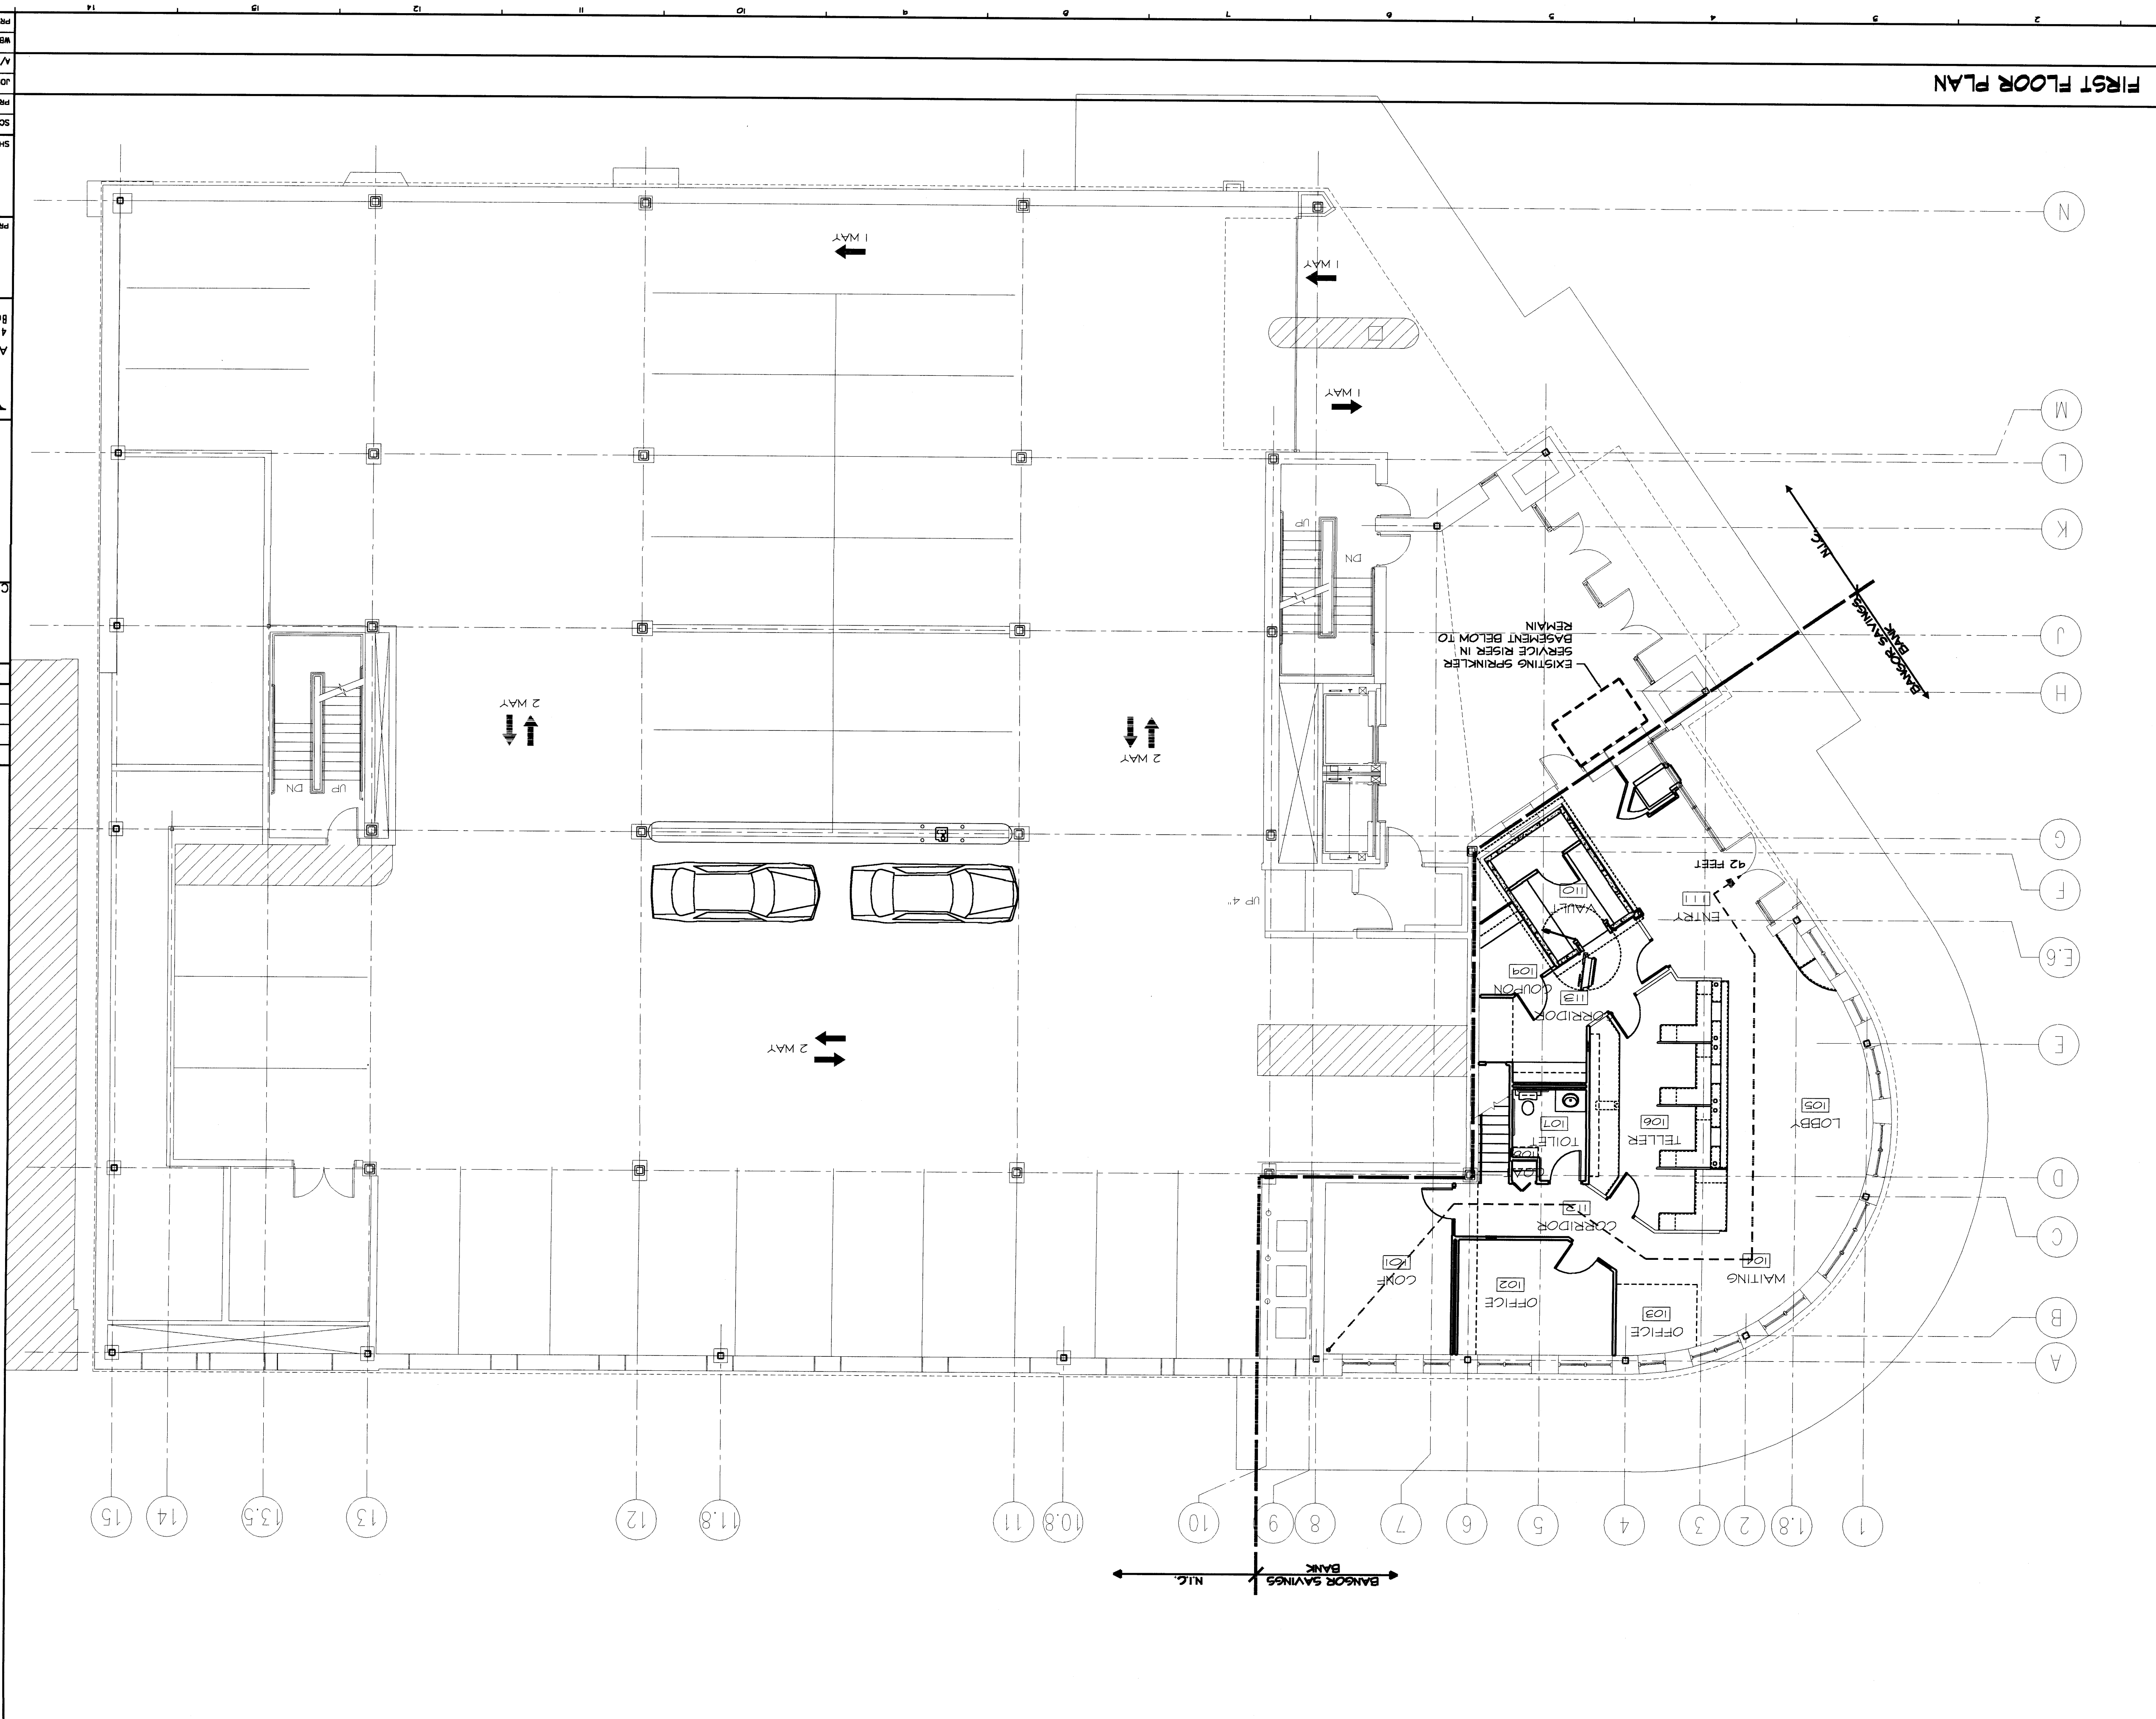

**WBRC ARCHITECTS • ENGINEERS**  
 44 Central Street  
 Bangor, Maine 04401  
 Tel: (207) 942-4511  
 Fax: (207) 942-4828

**BANGOR SAVINGS BANK**  
 FORE STREET  
 PORTLAND, MAINE

**COMPLIANCE PLAN**

PROJECT: AS NOTED  
 DATE: \_\_\_\_\_  
 GRAPHIC SCALE: 0' = 1"  
 PROJECT MANAGER: DCM  
 JOB CAP/DRAWN: JDL  
 MFC OF RECORD: MLC  
 PROJECT NO.: 2747.69  
 WBRC CAD #274769-61003

PROJECT: BANGOR SAVINGS BANK  
 LOCATION: FORE STREET  
 PORTLAND, MAINE

ISSUED FOR CONSTRUCTION  
 06-11-04  
 CURRENT ISSUE STATUS

| REV. | DESCRIPTION | DATE |
|------|-------------|------|
| 0    |             |      |

**NOTE:**  
 1. EXISTING NFPA 13, "WET" AUTOMATIC SPRINKLER FIRE SUPPRESSION SYSTEM, TO BE MODIFIED TO PROVIDE COVERAGE FOR NEW SPACE FIT-OUTS. ALL NEW WORK TO BE IN COMPLIANCE WITH NFPA 13.