


SECOND FLOOR PLAN

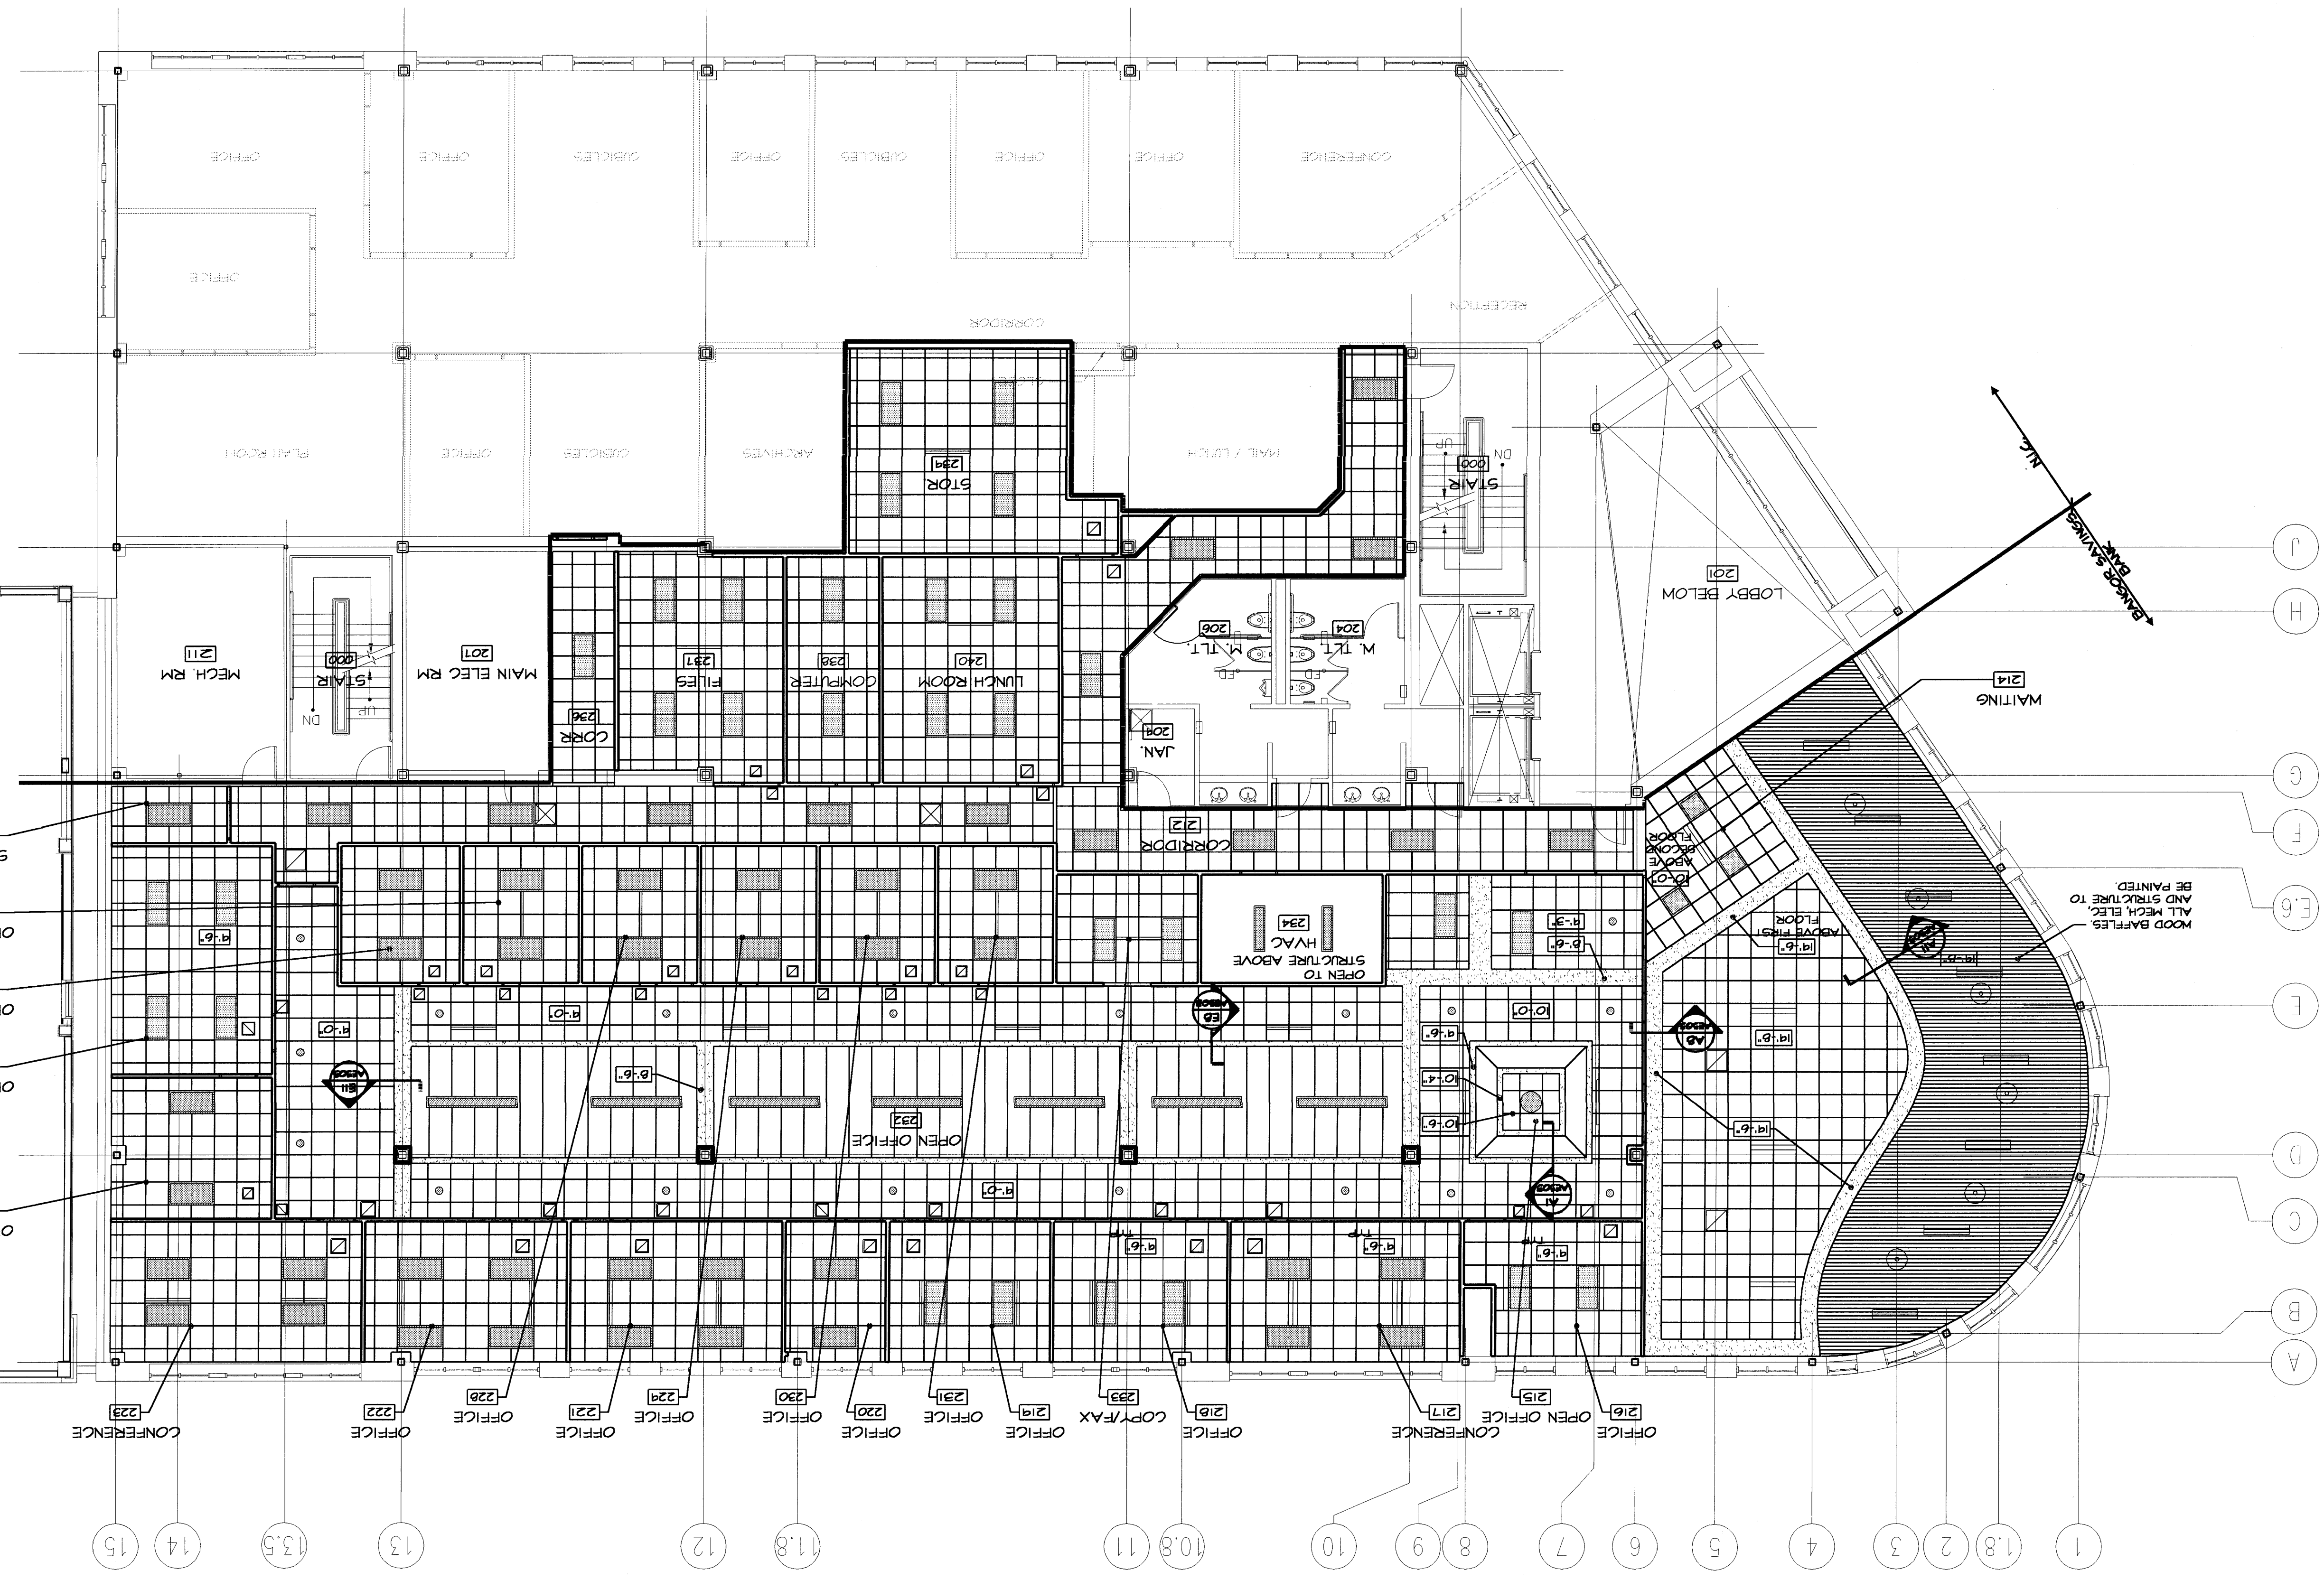

PROJECT TITLE: REFLECTED CEILING PLAN
 SECOND FLOOR
 BANGOR SAVINGS BANK
 FORE STREET
 PORTLAND, MAINE

PROJECT MANAGER: MLC
 GRAPHIC SCALE: 0"
 JOB CH/DR/AM: JDL
 A/E OF RECORD: MLC
 SHEET NO.: AE104

SCALE: AS NOTED
 DATE: --

WBRC ARCHITECTS • ENGINEERS
 44 Central Street
 Bangor, Maine 04401
 Tel: (207) 942-4511
 Fax: (207) 942-4628

PROJECT NORTH
 REGISTERED ARCHITECT
 STATE OF MAINE
 NO. 937
 W. MANICKI

CURRENT ISSUE STATUS:
 ISSUED FOR CONSTRUCTION
 06-11-04

REV.	DESCRIPTION	DATE
0		

LEGEND

- GYPSUM WALL BOARD
- CEILING OR SOFFIT
- SUSPENDED ACOUSTICAL TILE CEILING
- RECESSED FLUORESCENT LIGHT FIXTURE - SEE FOR TYPE
- PENDANT MOUNTED LIGHT FIXTURE
- PENDANT MOUNTED LIGHT FIXTURE BELOW
- RECESSED LIGHT FIXTURE
- RETURN GRILLE
- LINEAR SUPPLY DIFFUSER
- SUPPLY DIFFUSER
- SUSPENDED ACOUSTICAL TILE CEILING
- RECESSED FLUORESCENT LIGHT FIXTURE - SEE FOR TYPE
- PENDANT MOUNTED LIGHT FIXTURE
- PENDANT MOUNTED LIGHT FIXTURE BELOW
- RECESSED LIGHT FIXTURE

J
 H
 G
 F
 E.6
 E
 D
 C
 B
 A

15 14 13.5 13 12 11.8 11 10.8 10 9 8 7 6 5 4 3 2 1.8 1

WOOD BARRIERS, ALL MECH. ELEC. AND STRUCTURE TO BE PAINTED