


SECOND FLOOR PLUMBING PLAN

AI

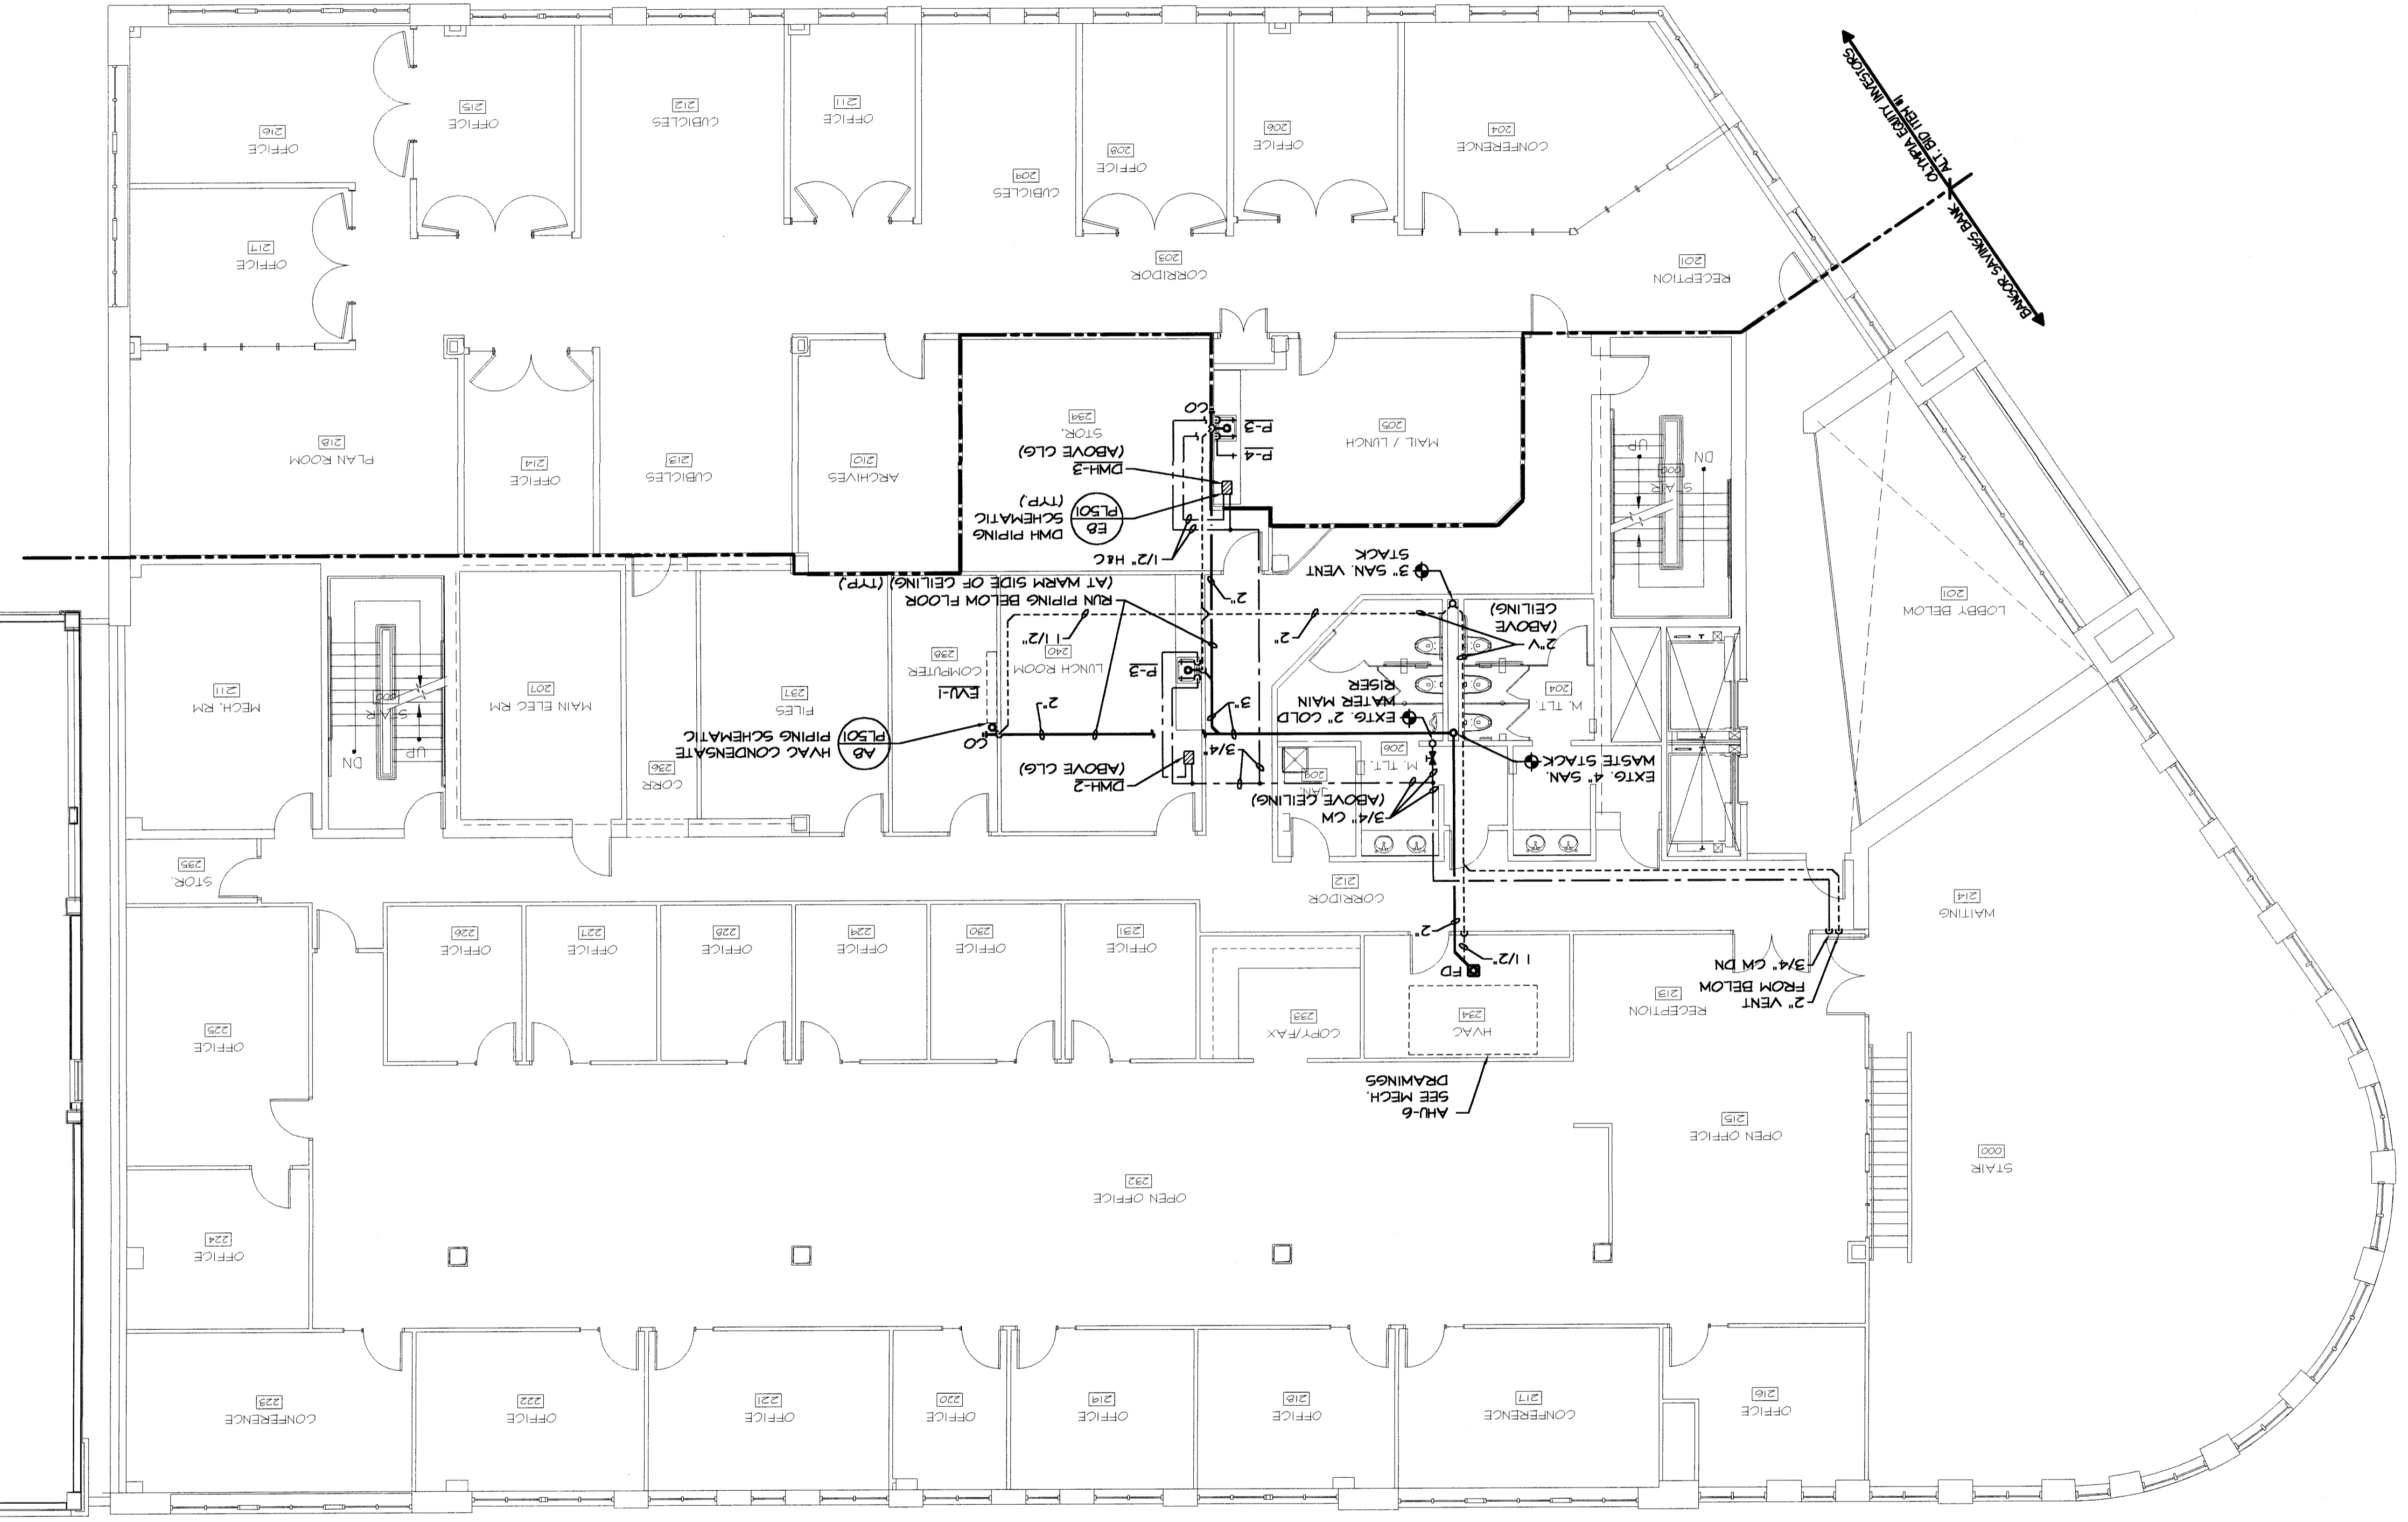


PROJECT NO. 2747.69  
 WBRC CAD FILE: 274769-PL102  
 M/E OF RECORD: RLR  
 JOB CDP/DRAWN: MAC/LAC  
 PROJECT MANAGER: MLC  
 GRAPHIC SCALE: 0'  
 SCALE: 1/8"=1'-0"  
 DATE: --

SECOND FLOOR PLUMBING PLAN

PROJECT: PORTLAND, MAINE  
 BANGOR SAVINGS BANK  
 FORE STREET

ARCHITECTS • ENGINEERS  
 44 Central Street  
 Bangor, Maine 04401  
 Tel (207) 947-4511  
 Fax (207) 947-4628

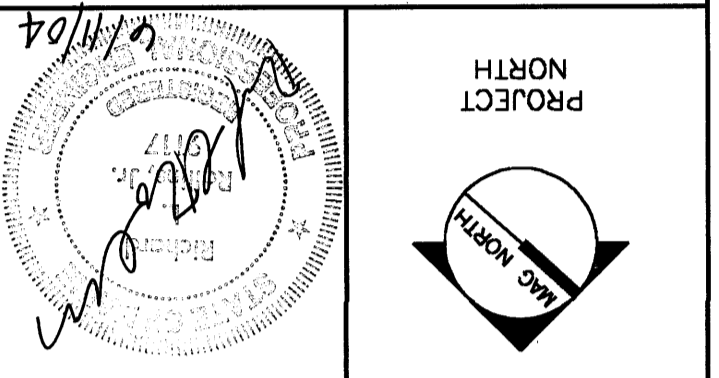

CURRENT ISSUE STATUS:  
 ISSUED FOR CONSTRUCTION  
 06-11-04

REV.	DESCRIPTION	DATE
0		