


FIRST FLOOR MECHANICAL PIPING PLAN

A1

1/8"=1'-0"

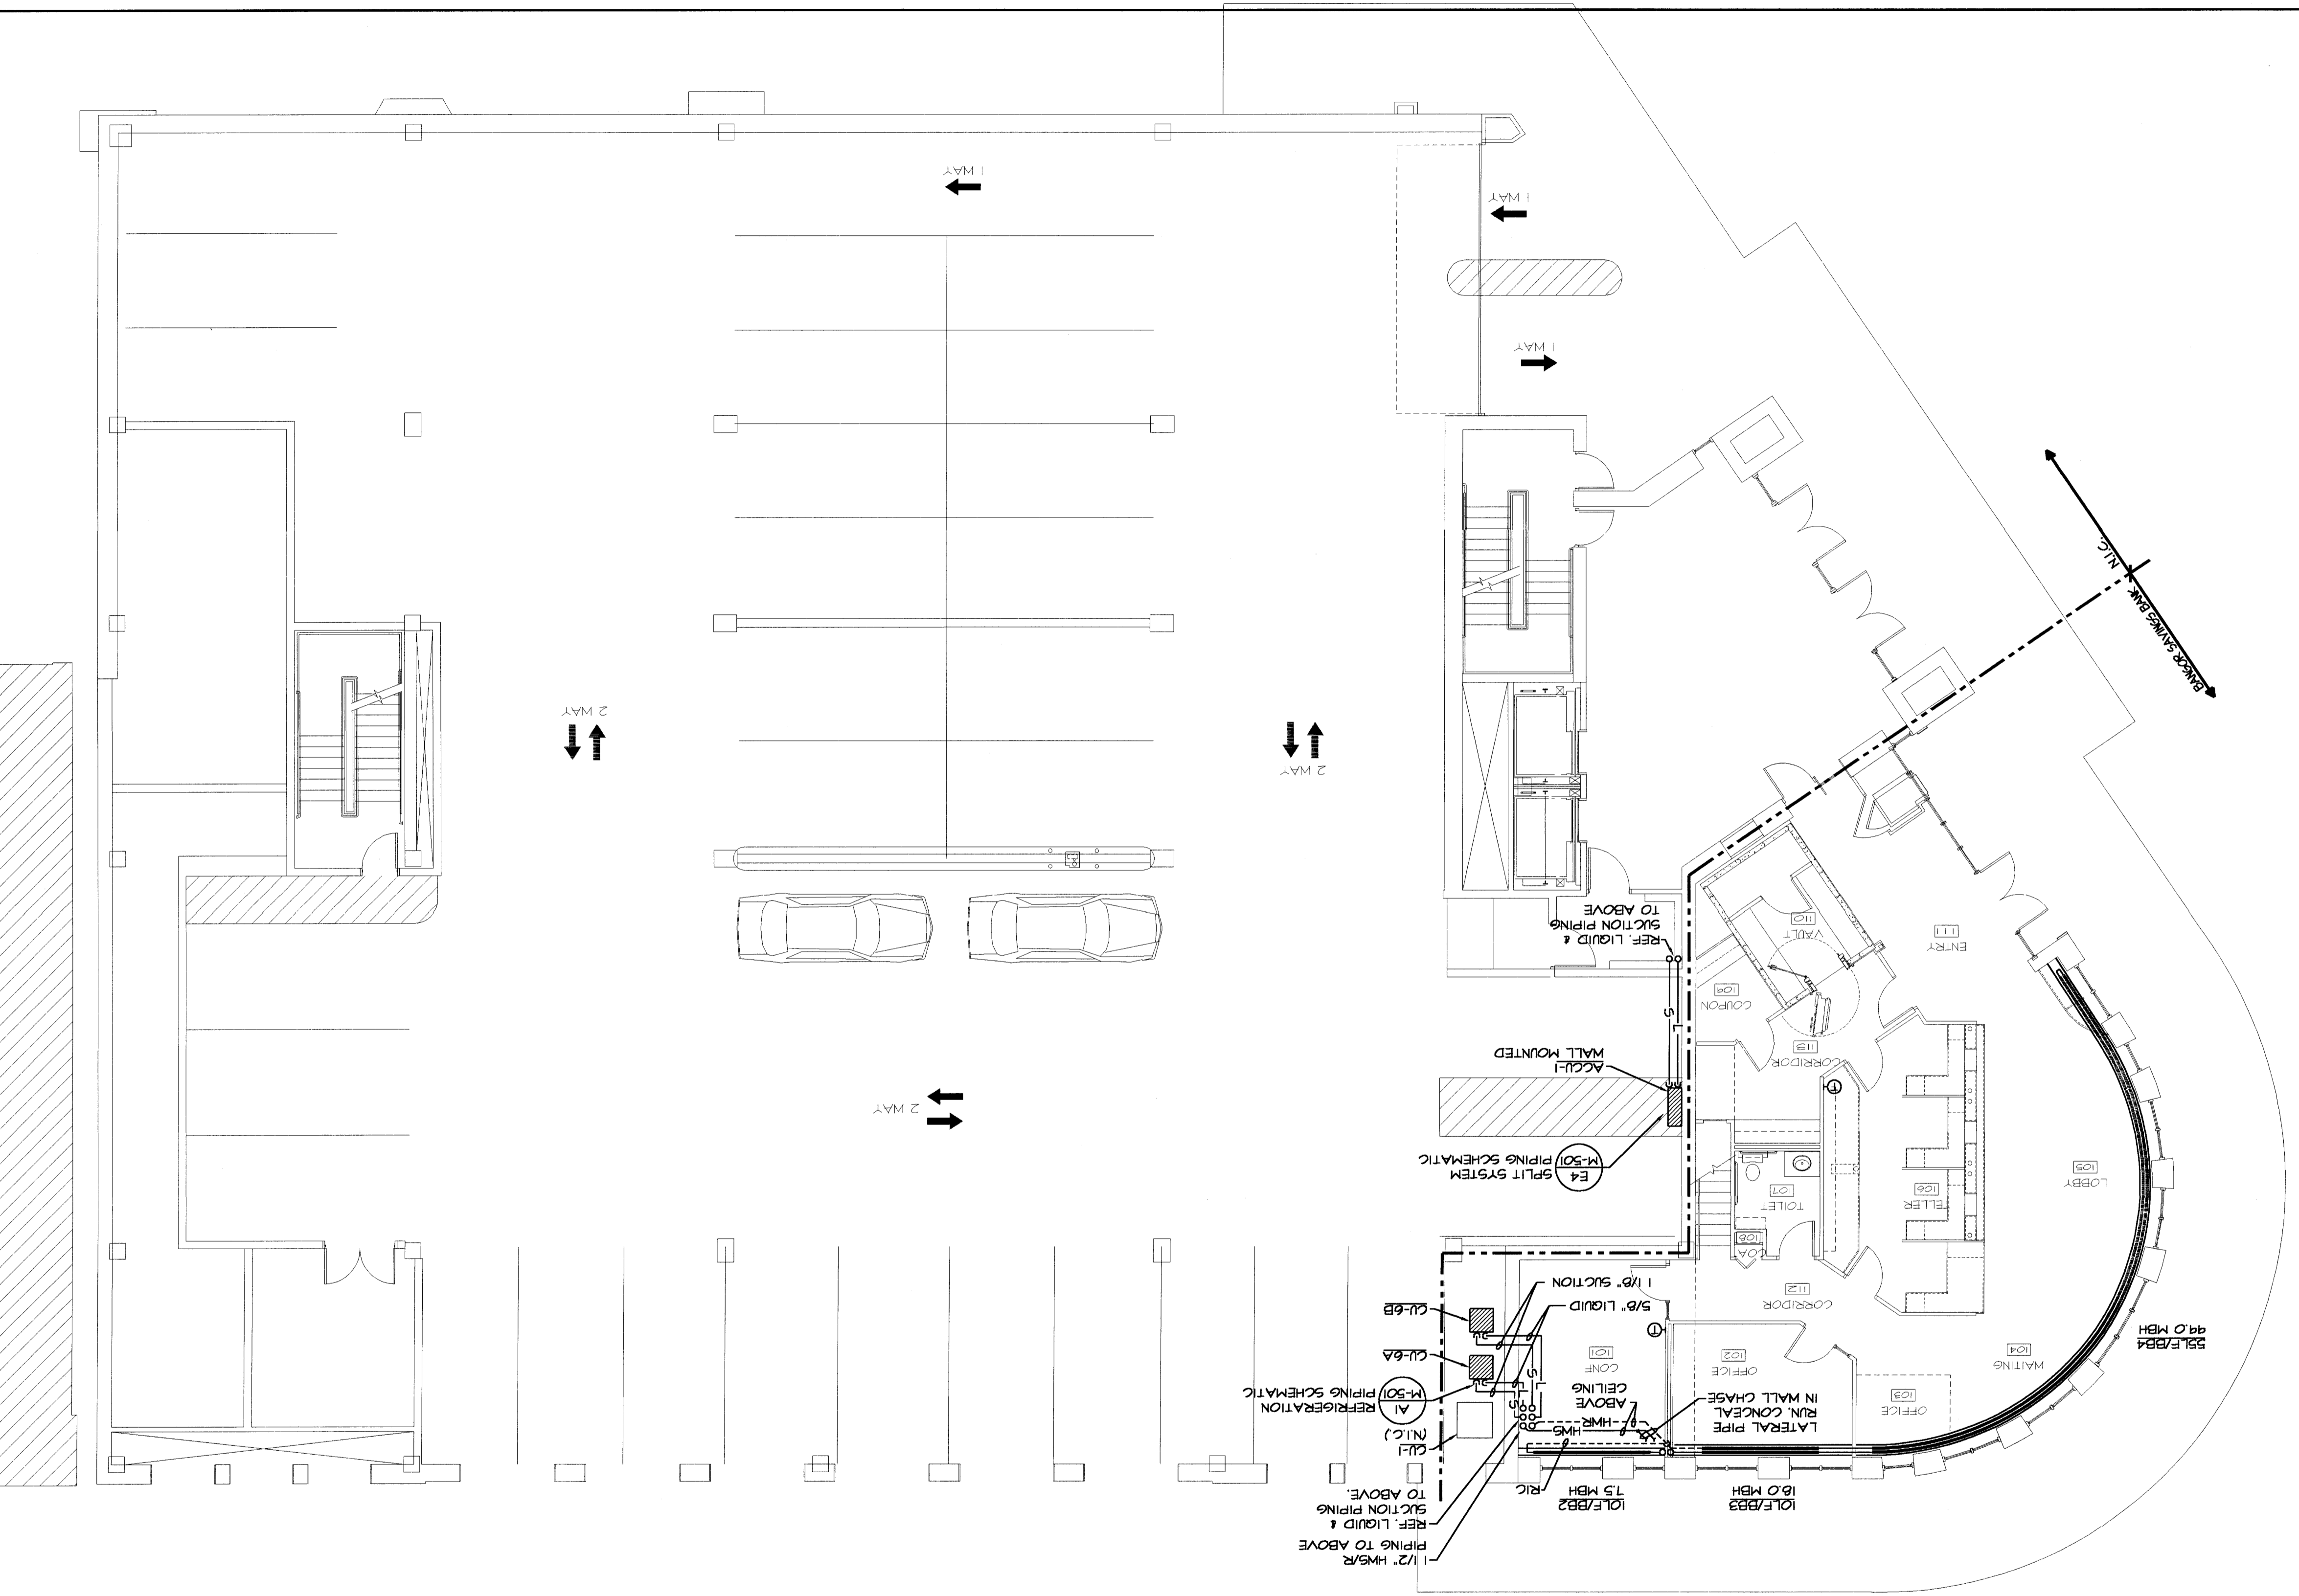

WBRC ARCHITECTS • ENGINEERS 44 Central Street Bangor, Maine 04401 Tel: (207) 947-4511 Fax: (207) 947-4628	
PROJECT NORTH 	
PROJECT BANGOR SAVINGS BANK FORE STREET PORTLAND, MAINE	
SHEET TITLE: FIRST FLOOR MECHANICAL PIPING PLAN	
SCALE: 1/8"=1'-0" DATE: -- --	
PROJECT MANAGER: MLC GRAPHIC SCALE: 0'	
JOB CWP/DRAWN: MAC/LAC A/E OF RECORD: RLR SHEET NO. MP101	
PROJECT No. 2747.69 WBRC CAD FILE: 274769-MP101	

REV.	DESCRIPTION	DATE
0		-- --

ISSUED FOR CONSTRUCTION 06-11-04

CURRENT ISSUE STATUS: