


SECOND FLOOR MECHANICAL PIPING PLAN

A1 1/8"=1'-0"

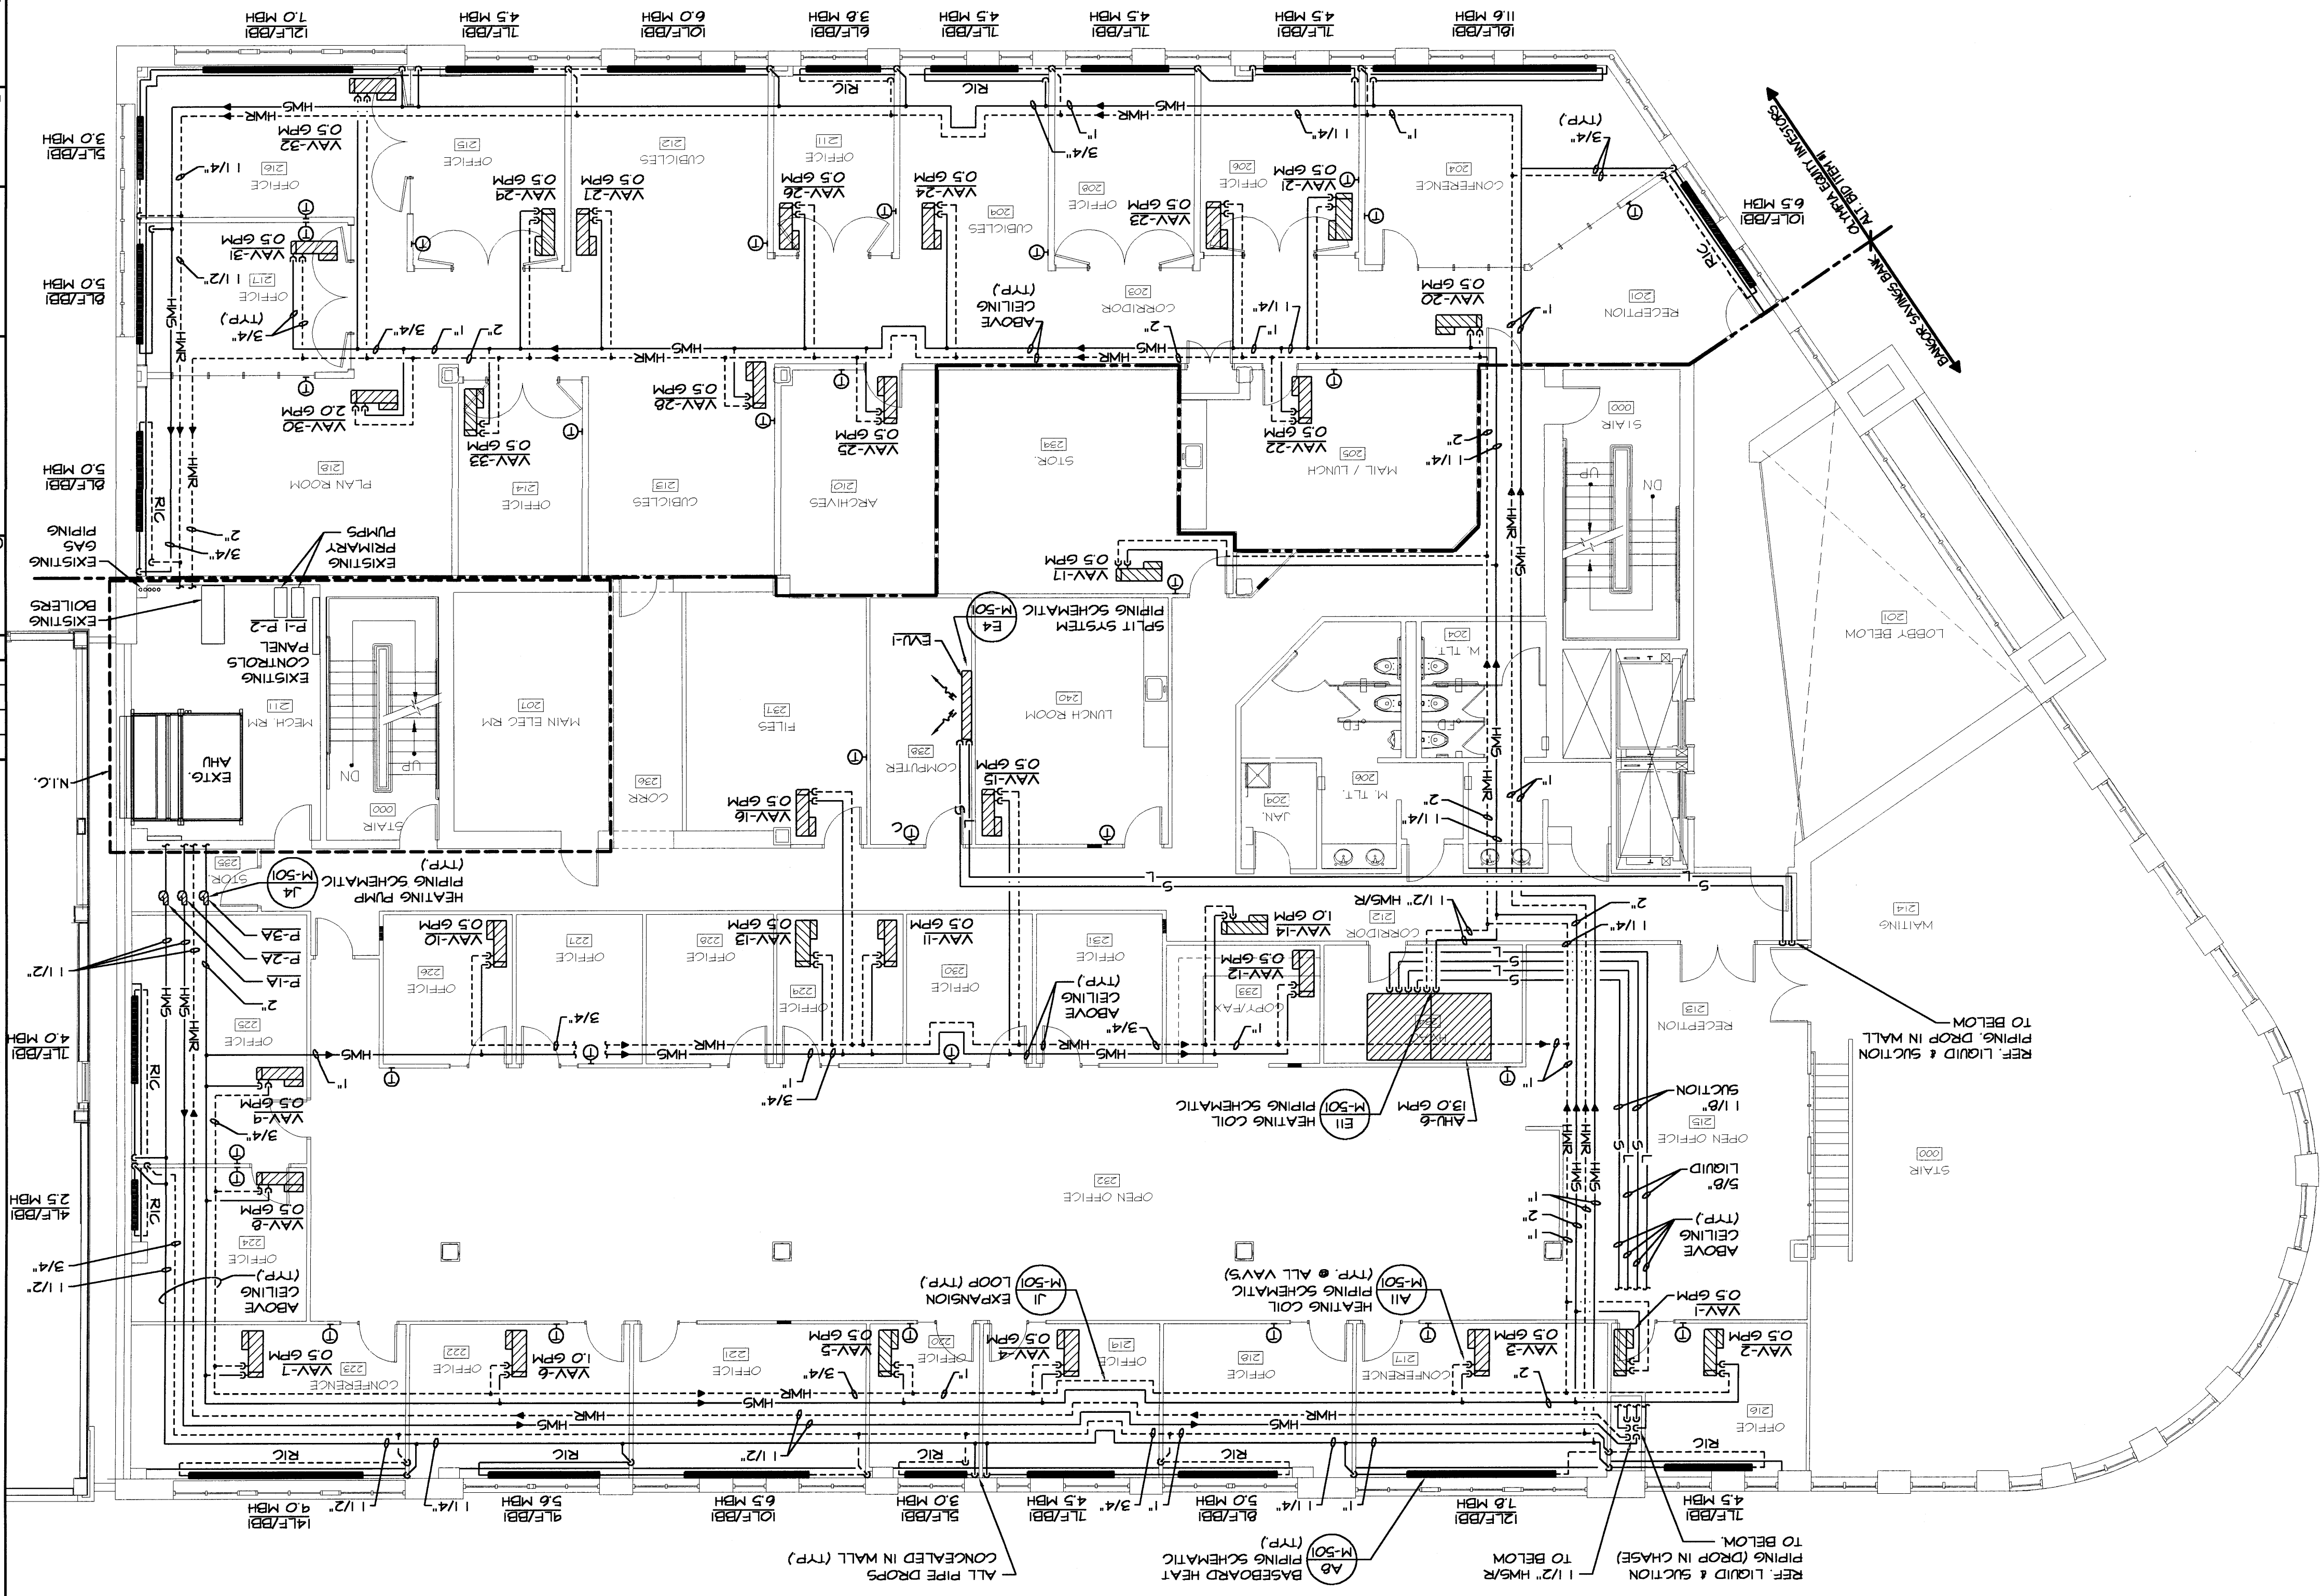

PROJECT No. 2747.69
 WBR CAD FILE: 274769-WP102
 A/E OF RECORD: RLR
 JOB CAP/DRAWN: MAC/LAC
 PROJECT MANAGER: MLC
 SCALE: 1/8"=1'-0"
 DATE: --

SHEET TITLE:
SECOND FLOOR MECHANICAL PIPING PLAN

PROJECT:
**BANGOR SAVINGS BANK
 FORE STREET
 PORTLAND, MAINE**

ARCHITECTS • ENGINEERS
WBRC
 44 Central Street
 Bangor, Maine 04401
 tel (207) 947.4511
 fax (207) 947.4528

PROJECT NORTH

CURRENT ISSUE STATUS:
ISSUED FOR CONSTRUCTION 06-11-04

REV.	DESCRIPTION	DATE
0		

PROJECT NORTH

CURRENT ISSUE STATUS:
ISSUED FOR CONSTRUCTION 06-11-04

REV.	DESCRIPTION	DATE
0		