



**E.S. BOULOS CO**  
ELECTRICAL CONTRACTORS

45 BRADLEY DRIVE  
WESTBROOK, ME 04092  
TEL: (207) 464-3706  
FAX: (207) 464-1833


**SM  
RT**

ARCHITECTURE ENGINEERING PLANNING  
SMART

144 Fore Street/P.O. Box 618  
Portland, Maine 04104  
tel. (207) 772-3846  
fax. (207) 772-1070

**NOTE:**

- SEE SHEET E-001 FOR LEGEND AND GENERAL NOTES.

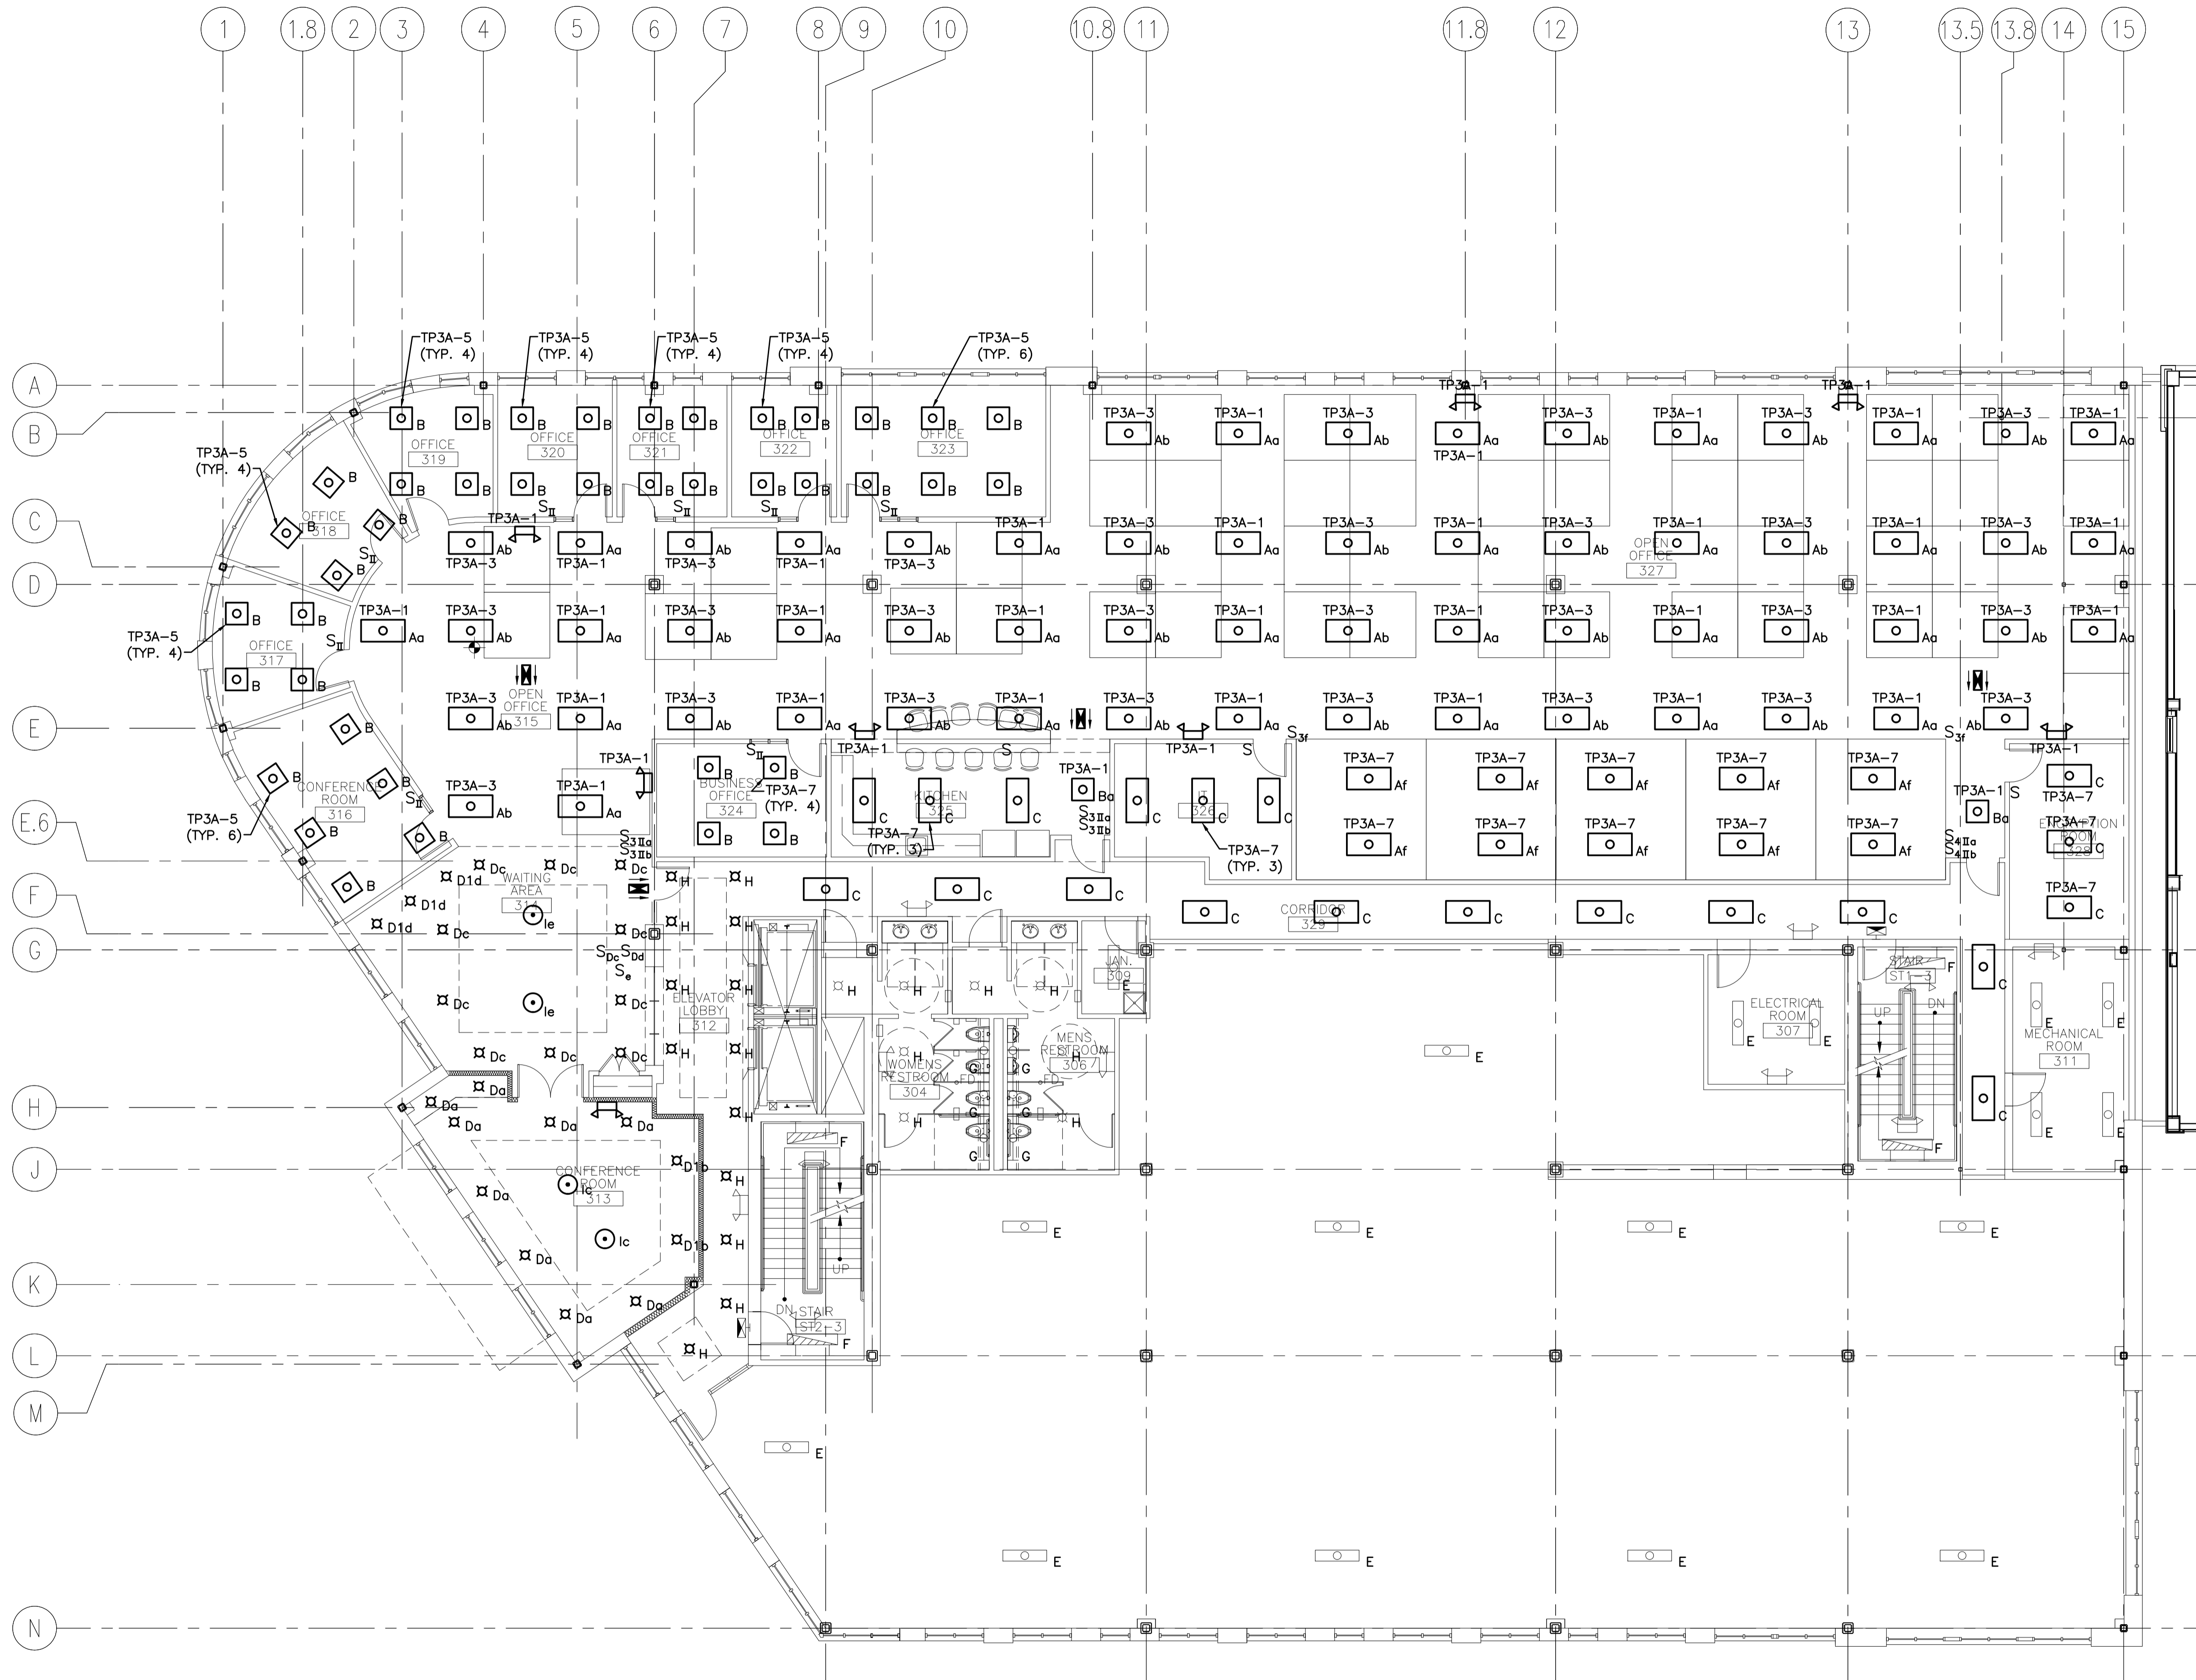

PROJECT TITLE:  
**280 FORE STREET  
3rd FLOOR TENANT FIT-UP**  
PORTLAND, MAINE

ISSUED FOR PERMIT  
9-28-05

REV	DESCRIPTION	DATE

GRAPHIC SCALE:  
0" 1"

SCALE: AS NOTED  
PROJECT MANAGER: JLH  
JC/DRAWN BY: LAM  
A/E OF RECORD: DJT  
CAD FILE: EL101-05123  
PROJECT NO: 05123  
DATE:  
SHEET TITLE:

**LIGHTING  
FLOOR PLAN**

A1 THIRD FLOOR PLAN

1/8"=1'-0"

SHEET No.  
**EL101**

PROGRESS PRINT