



E.S. BOULOS CO
ELECTRICAL CONTRACTORS

45 BRADLEY DRIVE
WESTBROOK, ME 04092
TEL: (207) 464-3706
FAX: (207) 464-1833



ARCHITECTURE ENGINEERING PLANNING
SMRT
144 Fore Street/P.O. Box 618
Portland, Maine 04104
tel. (207) 772-3846
fax. (207) 772-1070

NOTES:

- SEE SHEET E-001 FOR LEGEND AND GENERAL NOTES.
- FOR ALL VOICE/DATA OUTLETS SHOWN INSTALL EMPTY OUTLET BOX AND 1"Ø W/PULL STRING TO ABOVE AN ACCESSIBLE CEILING.

KEYED NOTES:

- EXISTING JUNCTION BOX AND CONDUIT TO BE USED FOR TELECOMMUNICATIONS WIRING IN MODULAR FURNITURE. TELECOMMUNICATIONS WIRING TO BE BY OWNER.
- FURNISH & INSTALL AN EMPTY OUTLET COX & TWO EMPTY ENT CONDUITS TO ABOVE AN ACCESSIBLE CEILING FOR MODULAR FURNITURE TELECOMMUNICATIONS WIRING. TELECOMMUNICATIONS WIRING TO BE BY OWNER.




PROJECT TITLE:
**280 FORE STREET
3rd FLOOR TENANT FIT-UP**
PORTLAND, MAINE

ISSUED FOR PERMIT
9-28-05

REV	DESCRIPTION	DATE

GRAPHIC SCALE:
0" 1"
SCALE: AS NOTED
PROJECT MANAGER: JLH
JC/DRAWN BY: LAM
A/E OF RECORD: DJT
CAD FILE: EY101-05123
PROJECT NO: 05123
DATE:
SHEET TITLE:

SYSTEMS FLOOR PLAN
SHEET No. EY101

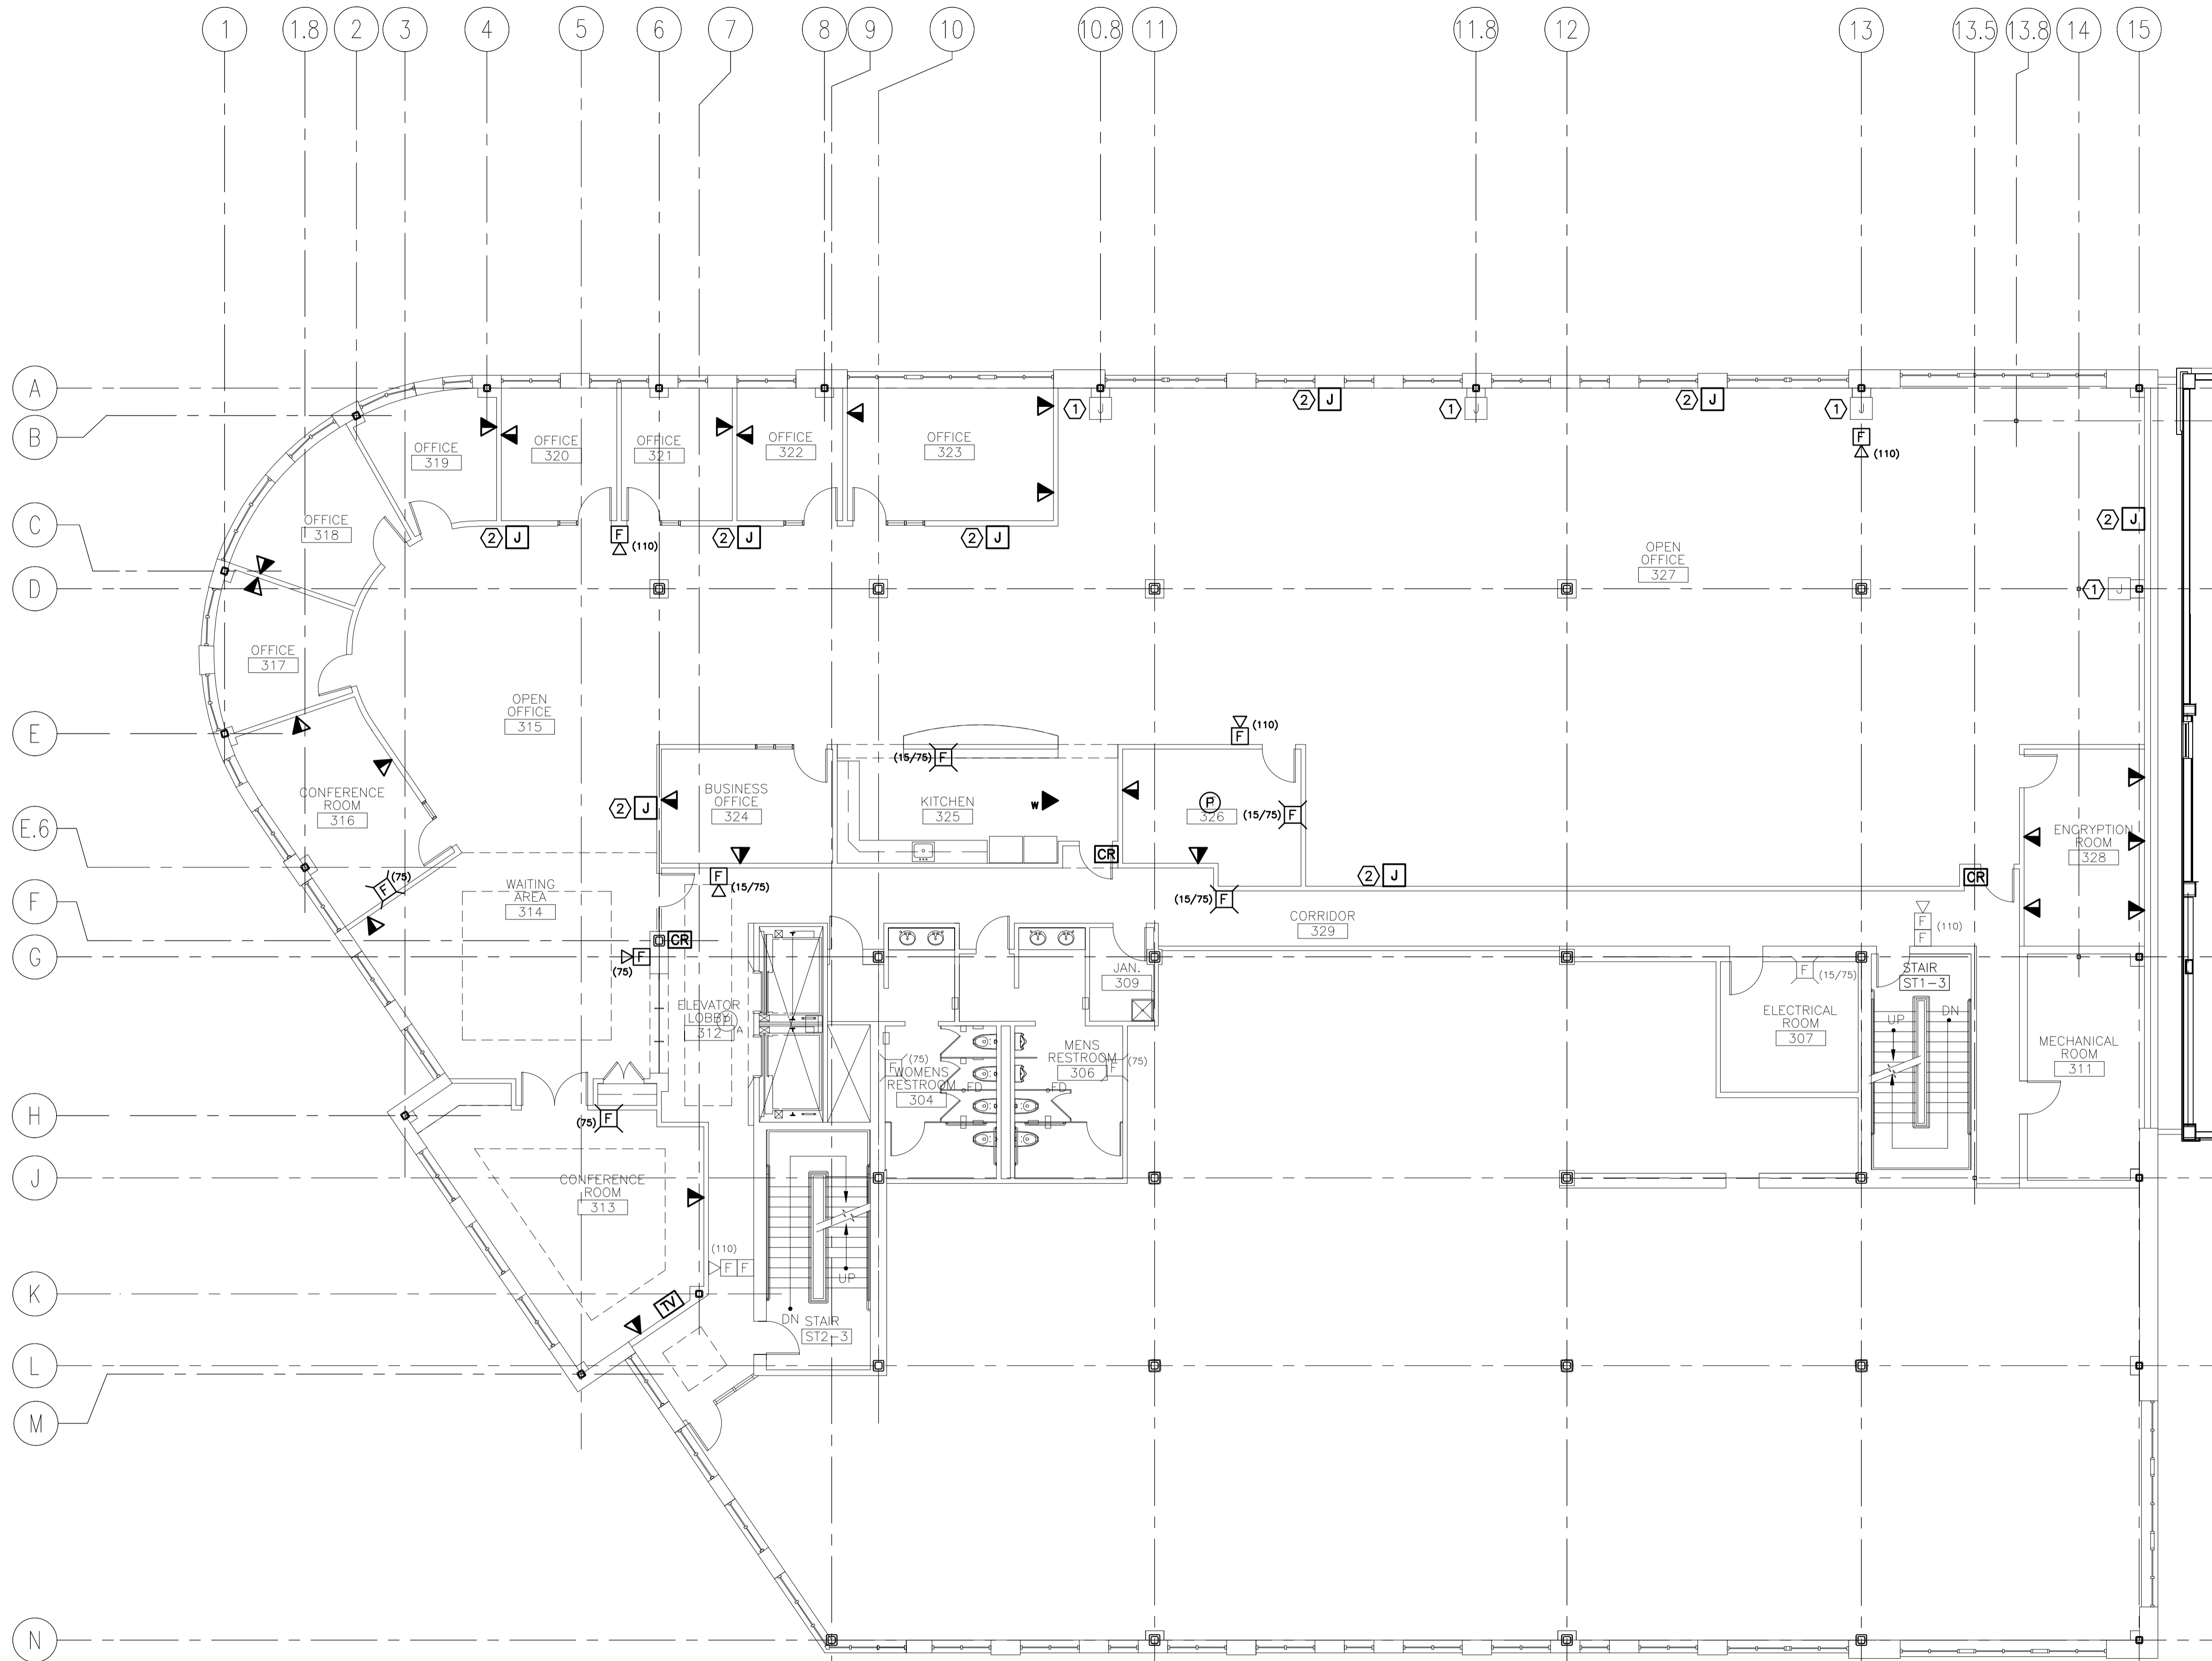

A1 THIRD FLOOR PLAN
1/8"=1'-0"

PROGRESS PRINT