


#	DATE	DESCRIPTION
REVISIONS		
	Date Issued	07.23.13
	Project Number	13105
	Drawing Scale	AS NOTED
	SHEET NAME	SECOND FLOOR PLANS

Drawn By
Checked By JCC


A2.1

IF THIS SHEET IS NOT 24 X 36 IT IS A REDUCED SCALE PRINT - SCALE ACCORDINGLY

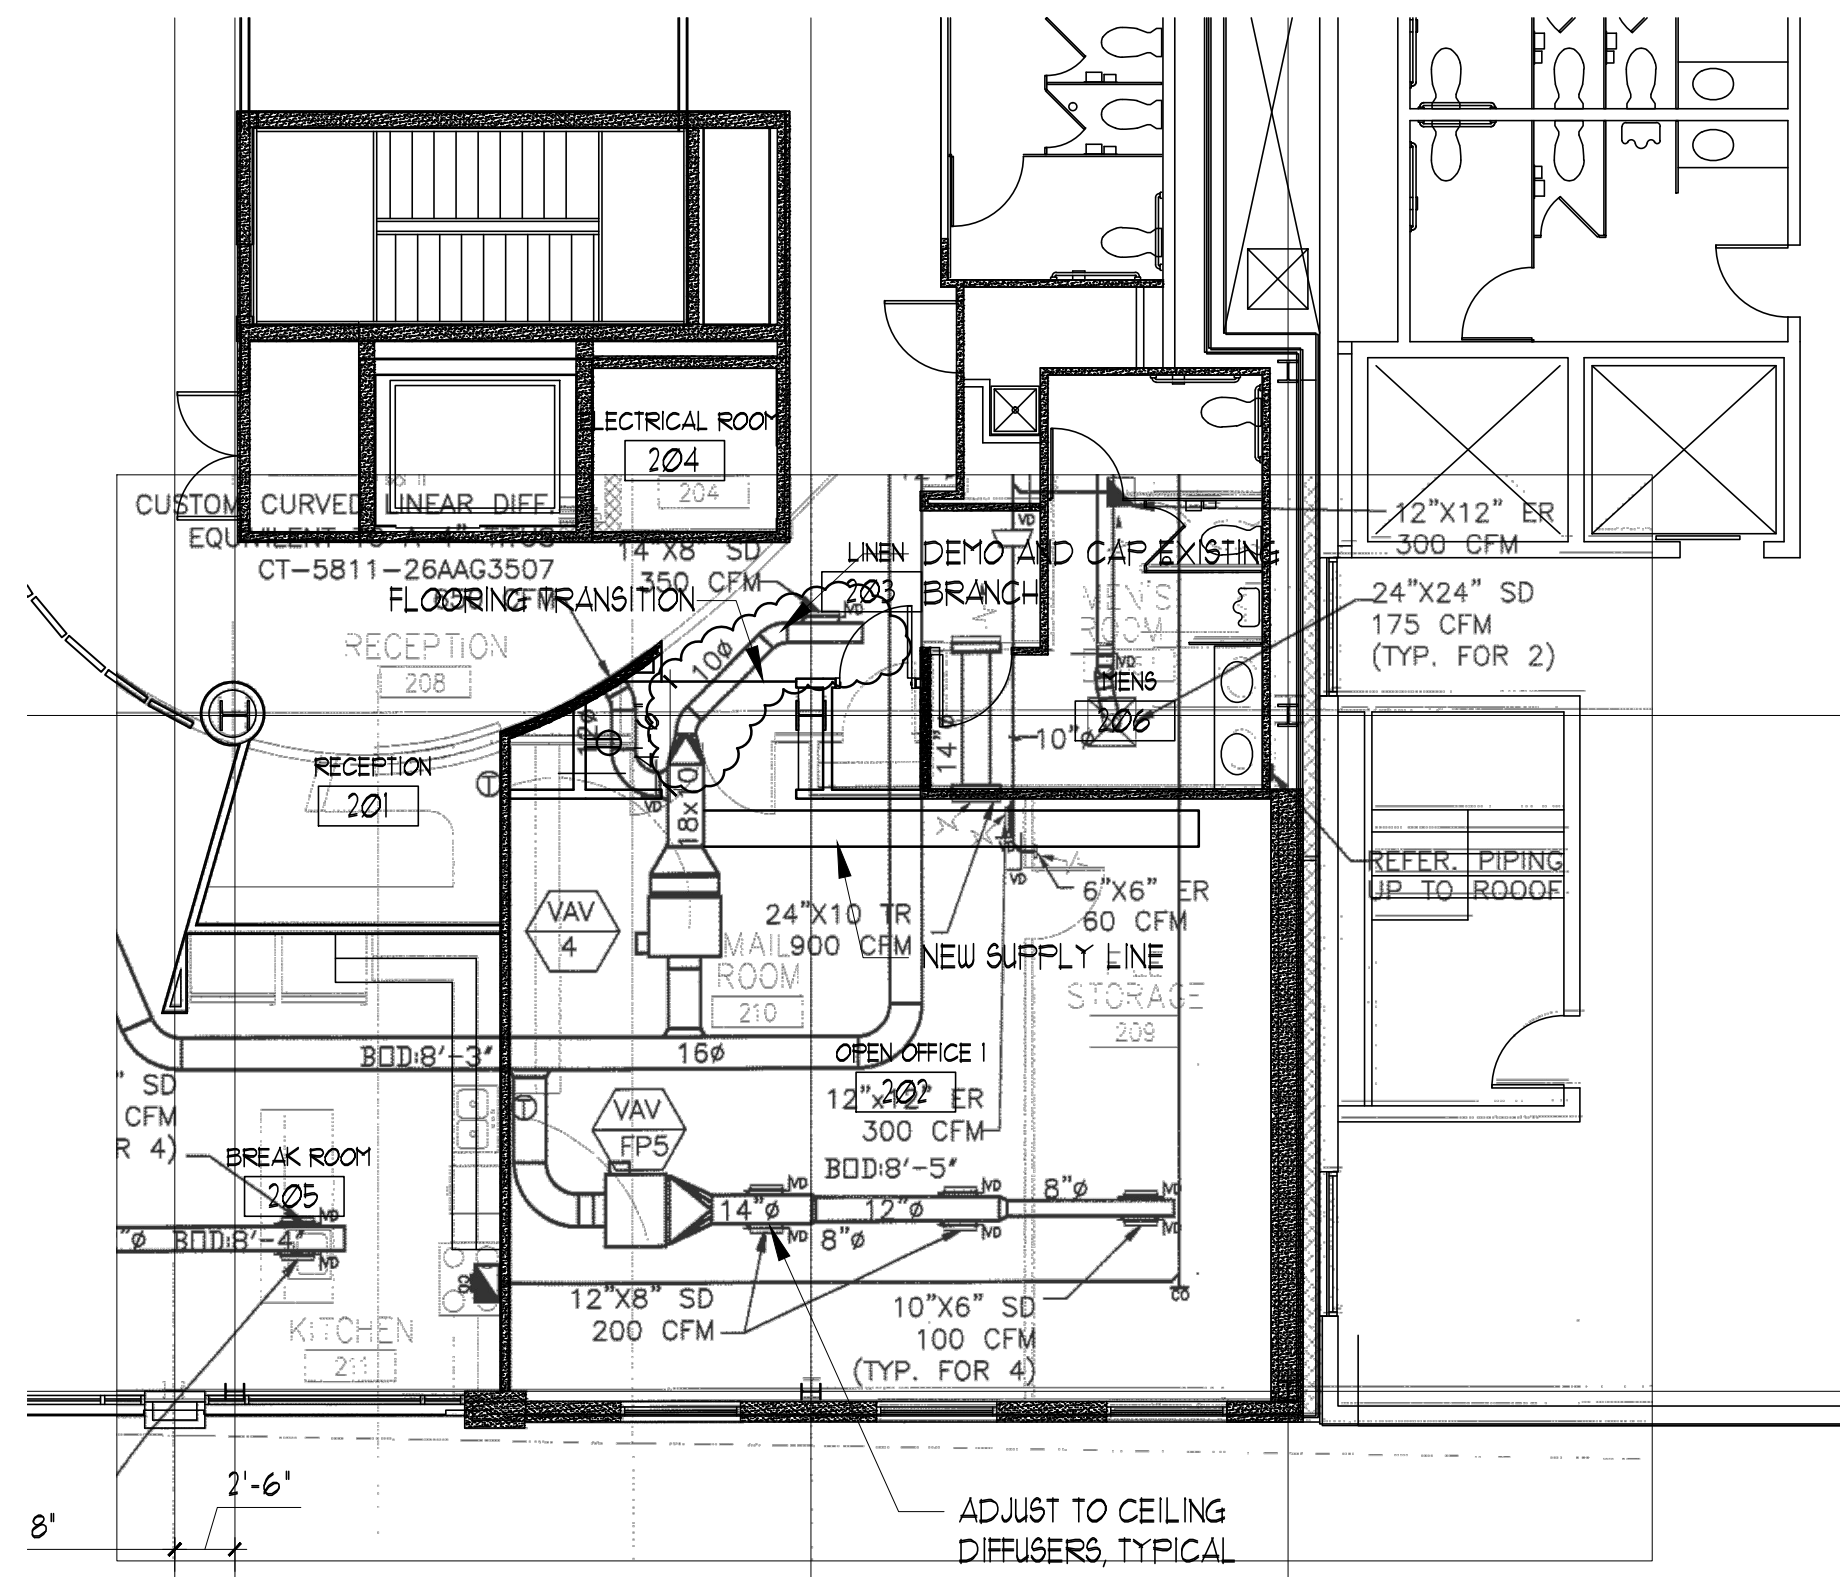


2ND FLOOR MECHANICAL PLAN
SCALE: 1/8" = 1'-0"

Narrative:
Open Office 202 - Fan powered VAV box FP5 that currently serves space to remain. VAV 4 box the currently serves corridor outside Open office 202 shall be re-ducted to serve open office 202. Two VAV boxes shall be tied together on the same t-stat.

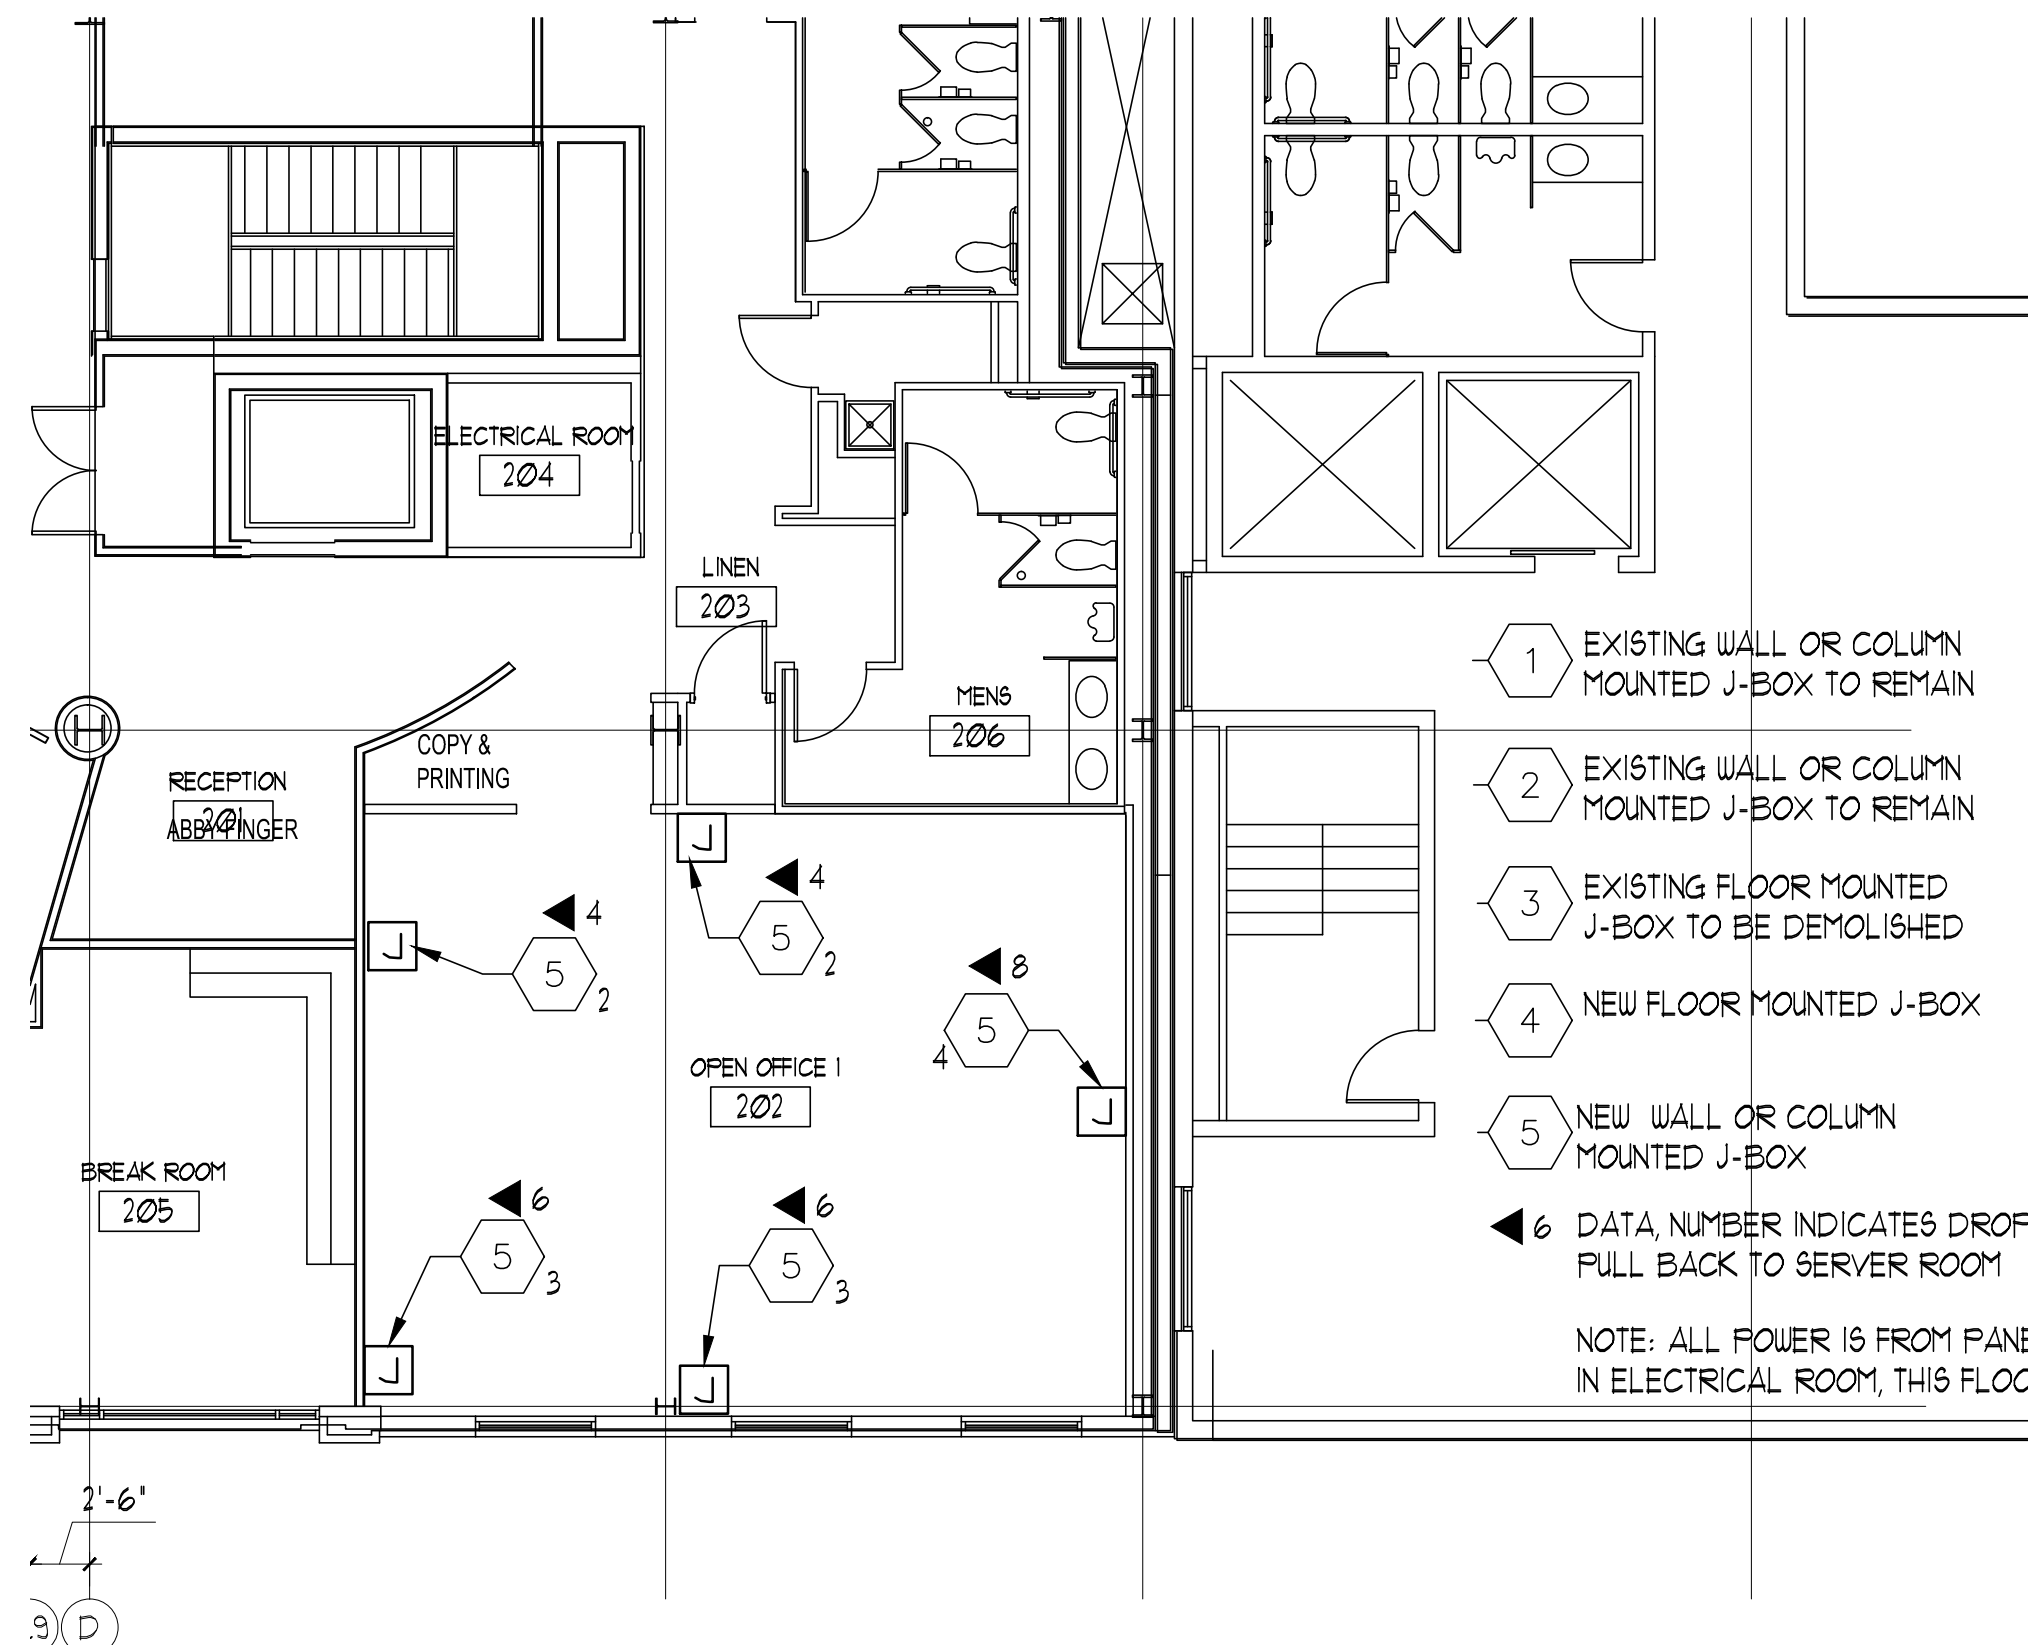


2ND FLOOR POWER/DATA
SCALE: 1/8" = 1'-0"


- 1 EXISTING WALL OR COLUMN MOUNTED J-BOX TO REMAIN
 - 2 EXISTING WALL OR COLUMN MOUNTED J-BOX TO REMAIN
 - 3 EXISTING FLOOR MOUNTED J-BOX TO BE DEMOLISHED
 - 4 NEW FLOOR MOUNTED J-BOX
 - 5 NEW WALL OR COLUMN MOUNTED J-BOX
 - 6 DATA, NUMBER INDICATES DROPS, FULL BACK TO SERVER ROOM
- NOTE: ALL POWER IS FROM PANEL 1 IN ELECTRICAL ROOM, THIS FLOOR.

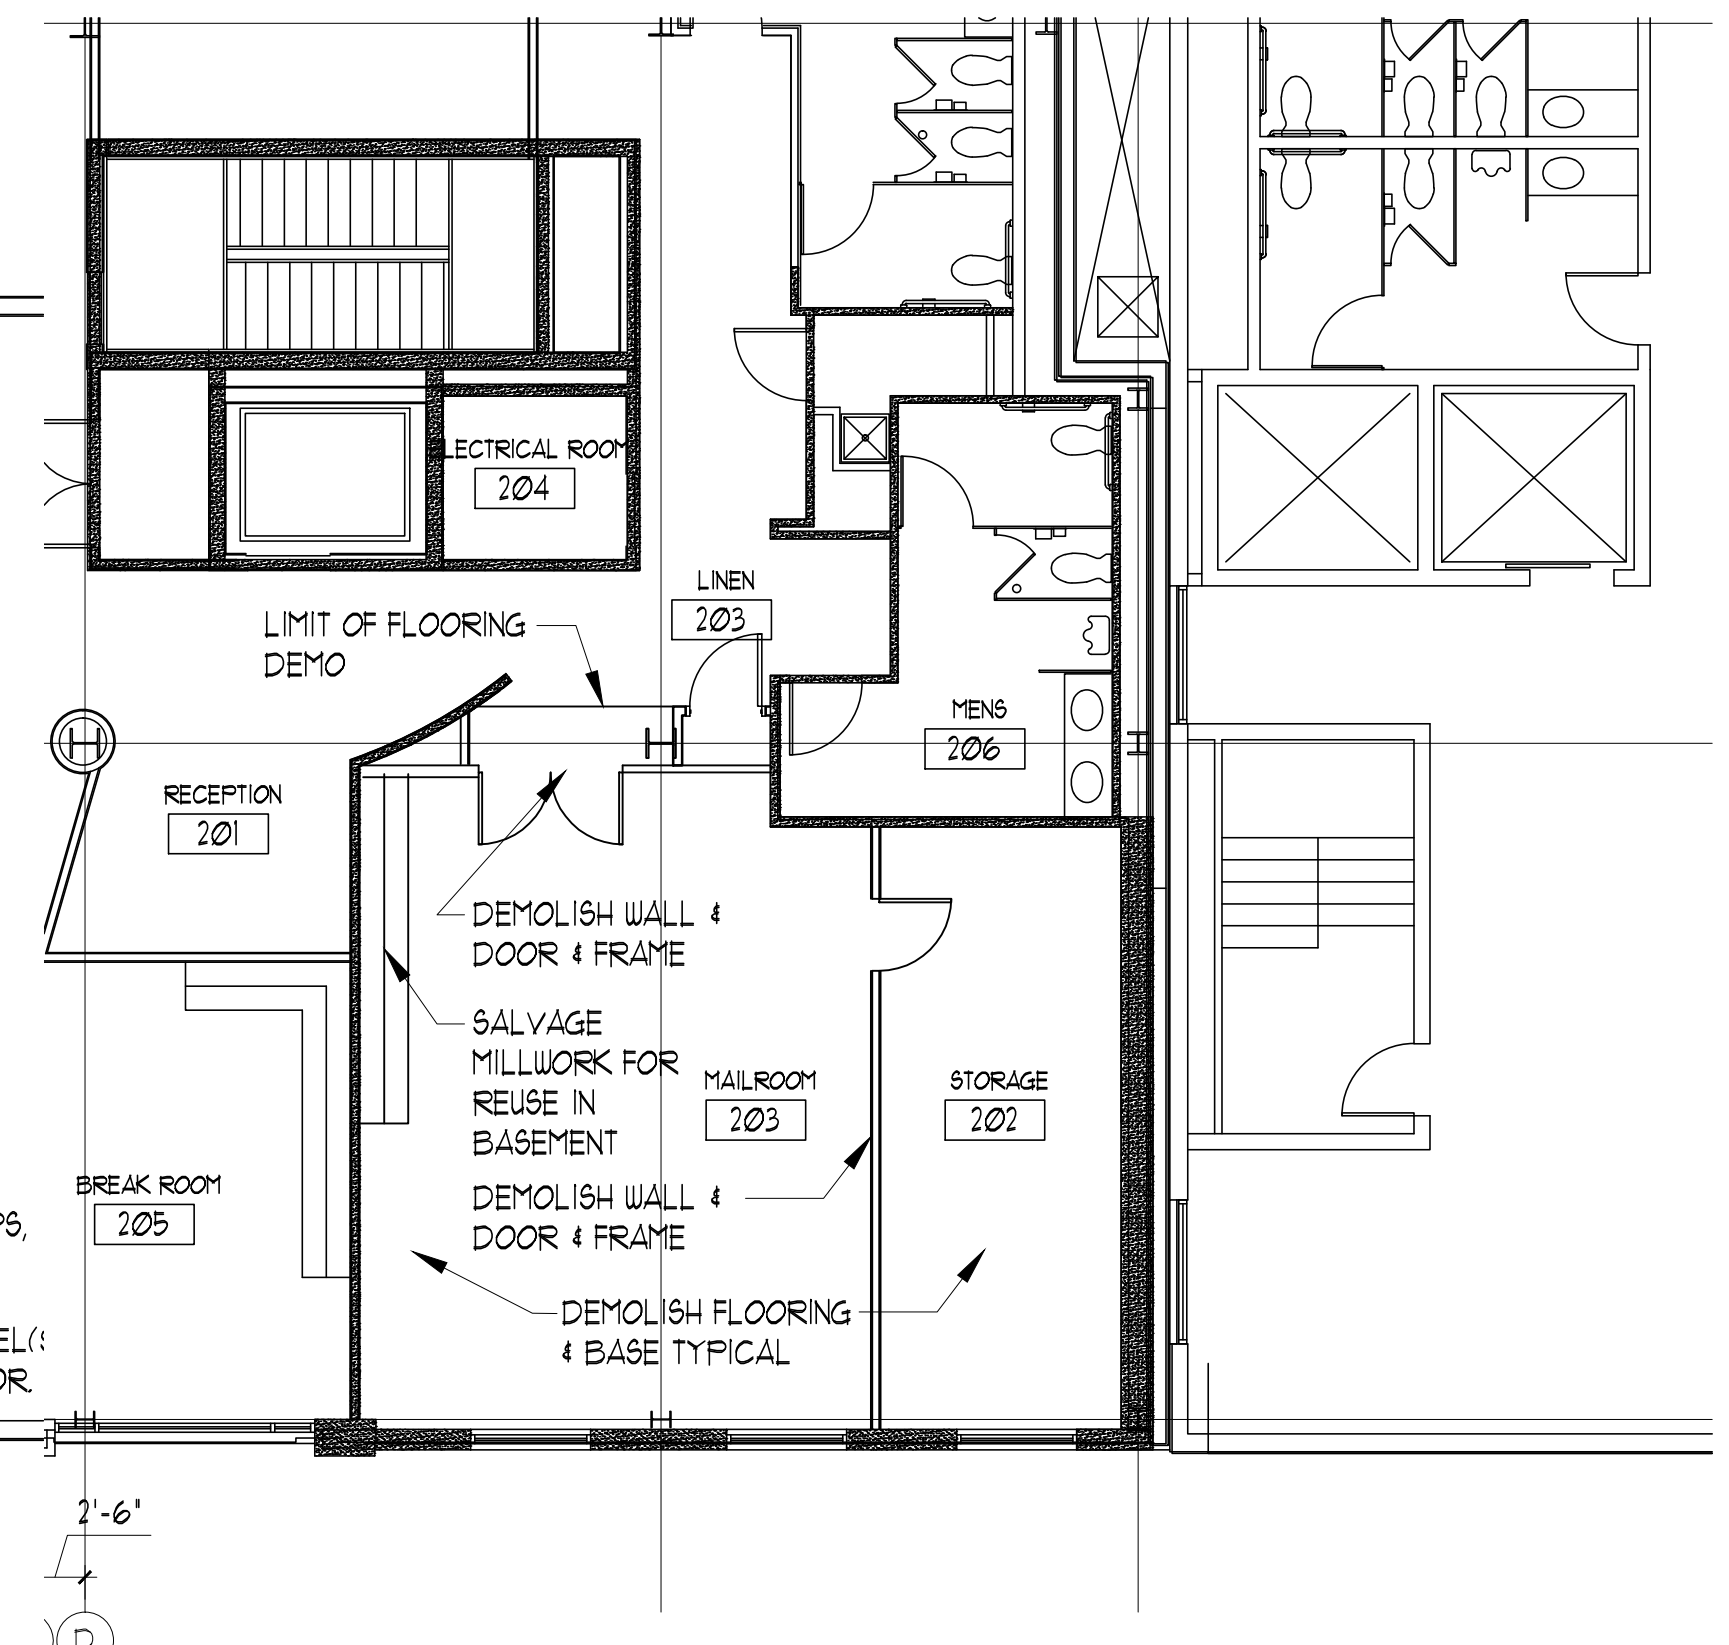


2ND FLOOR DEMO
SCALE: 1/8" = 1'-0"

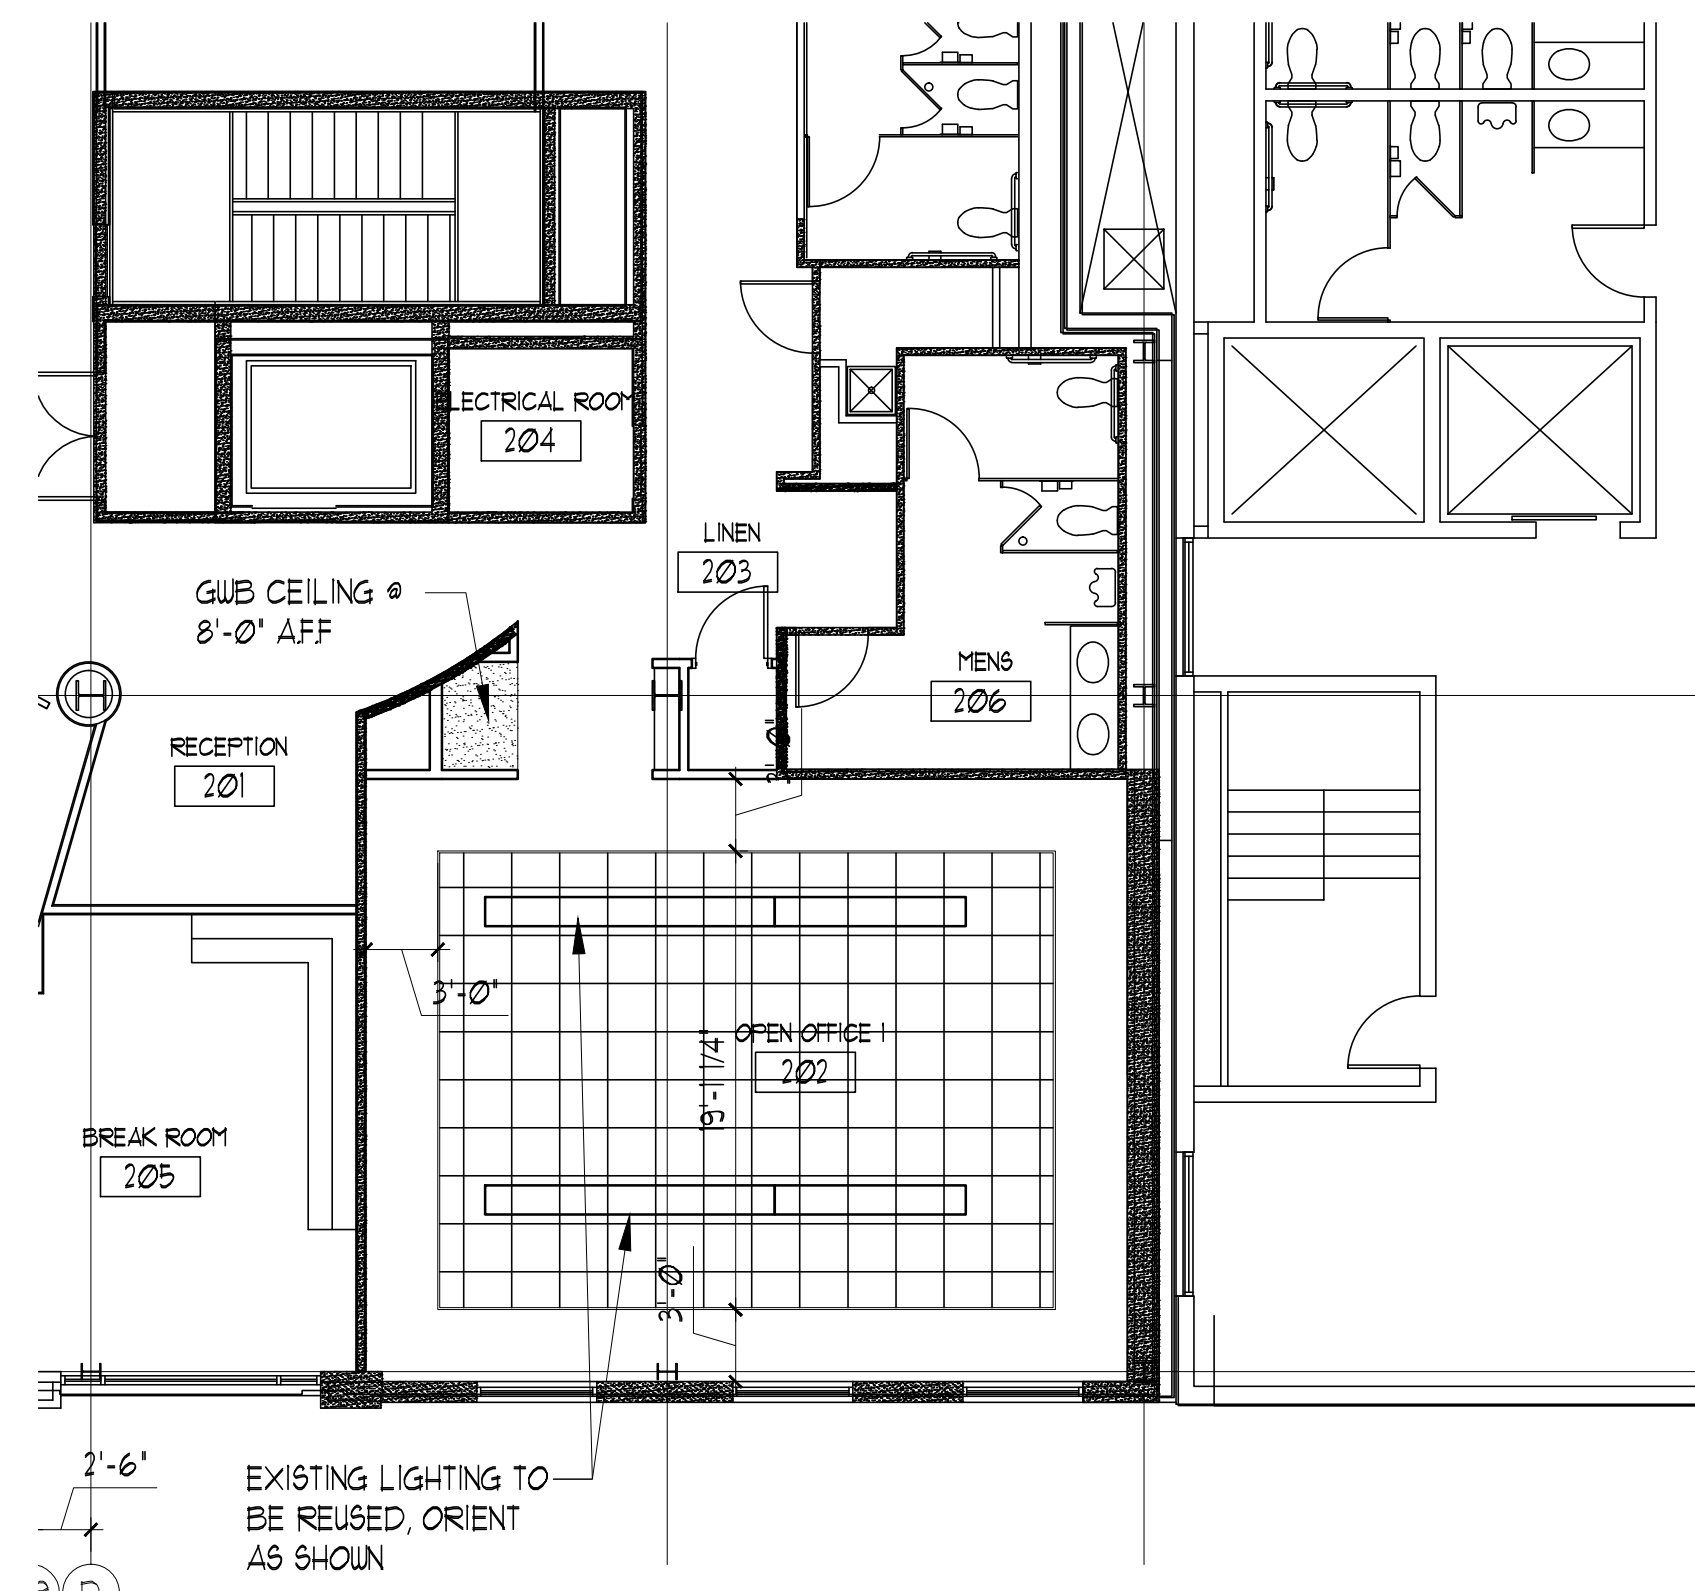

2ND FLOOR PLAN RCP
SCALE: 1/8" = 1'-0"

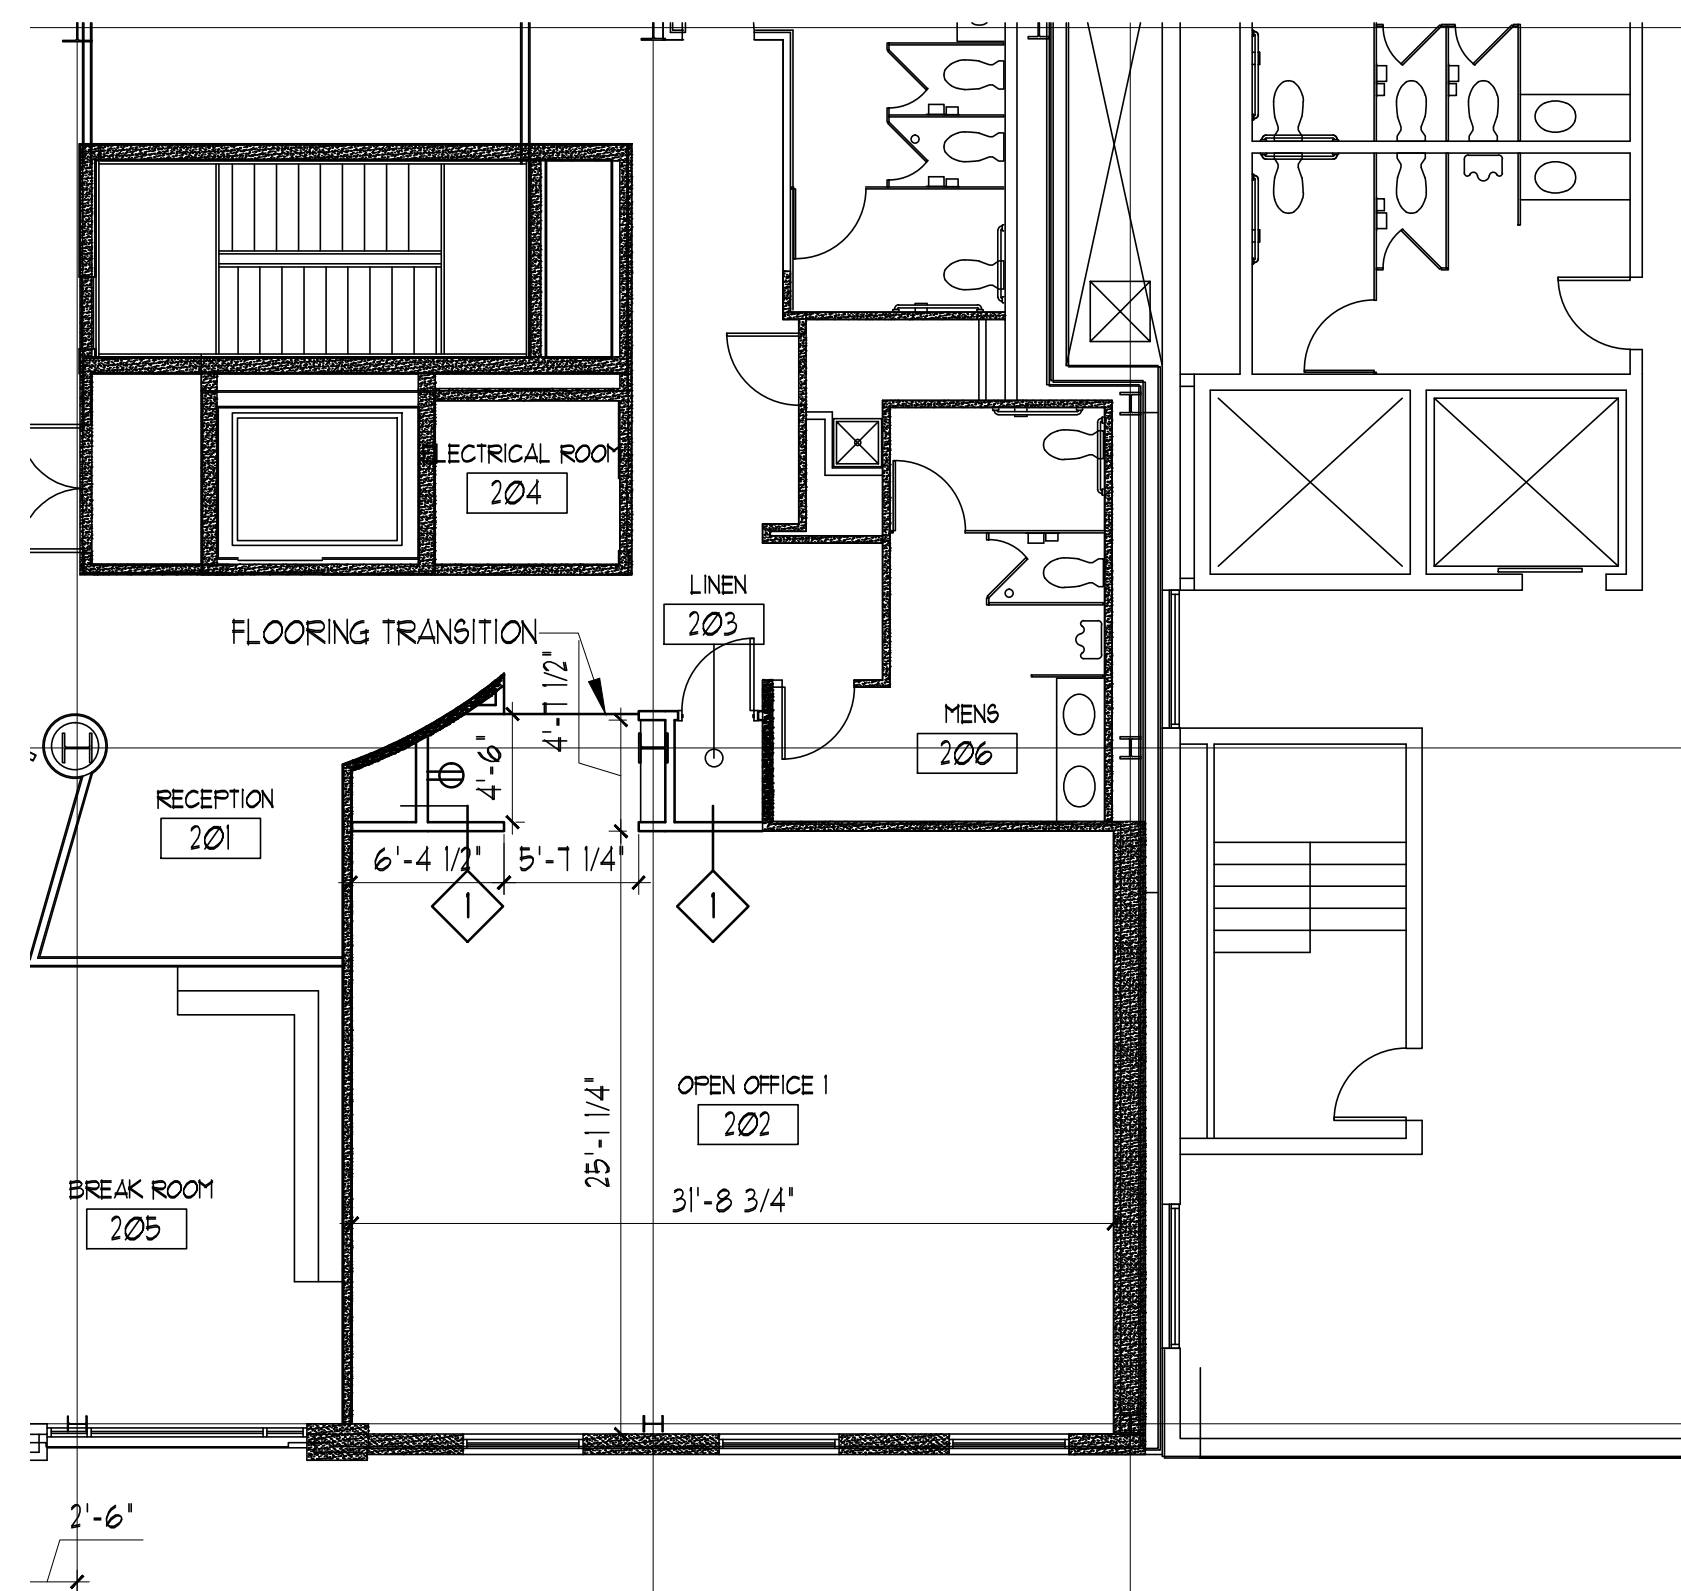

2ND FLOOR PLAN PROPOSED
SCALE: 1/8" = 1'-0"

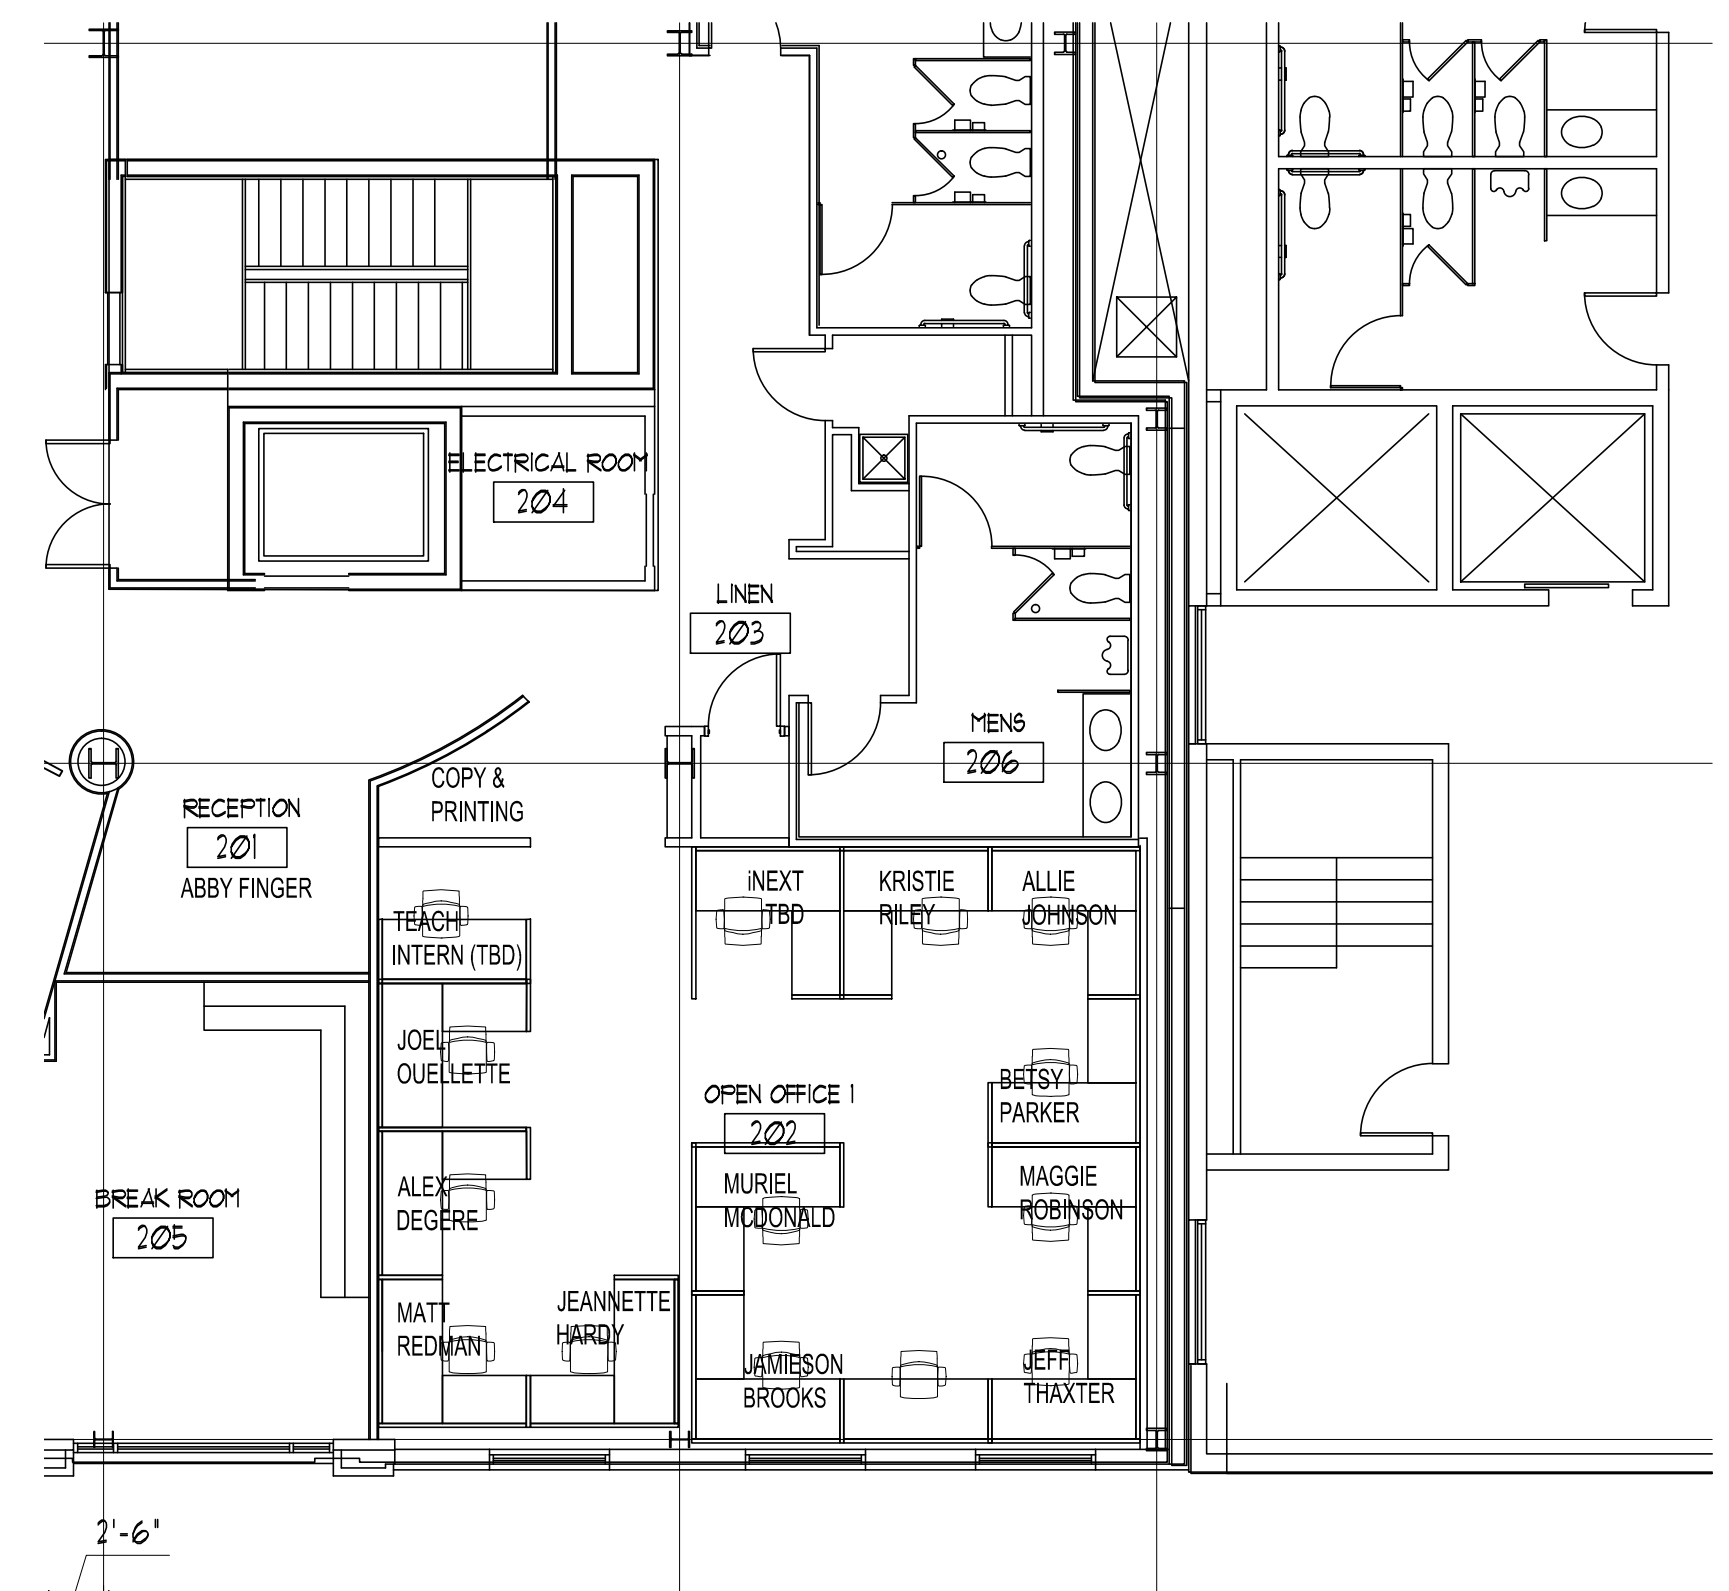

2ND FLOOR PLAN FURNITURE
SCALE: 1/8" = 1'-0"