

SHEET NOTES

- 03 EXPOSED STRUCTURE AND SLAB.
- 04 EXPOSED STRUCTURE AND SLAB WITH ACOUSTIC SPRAY.
- 05 EXISTING SPRINKLERS TO BE MODIFIED: COORDINATE WITH FF ENGINEER. CENTER SPRINKLER HEAD IN CEILING TILE AS REQUIRED.
- 06 EXISTING FIRE ALARM SYSTEM TO BE MODIFIED, COORDINATE WITH FF ENGINEER.
- 07 MOISTURE RESISTANT ACT.
- 08 EXISTING EMERGENCY LIGHTING ALONG PATH OF EGRESS TO BE MODIFIED AS REQUIRED TO CONFORM WITH CODE REQUIREMENTS, COORDINATE WITH ELECTRICAL DESIGN/BUILD CONTRACTOR.

GENERAL NOTES


LEGEND

- ACoustical CEILING AND GRID
- CEILING HEIGHT CHANGE SYMBOL
- FINISH CEILING HEIGHT SYMBOL
- GRID STARTPOINT SYMBOL
- CEILING FINISH TAG
- MOTION SENSOR
- CEILING MOUNTED SPEAKER
- CEILING MOUNTED CAMERA
- CEILING MOUNTED SMOKE DETECTOR
- CEILING MOUNTED EXIT SIGN
- WALL MOUNTED EXIT SIGN
- DENOTES EXISTING TO REMAIN
- DENOTES EXISTING TO BE RELOCATED
- FLUORESCENT LIGHT FIXTURE
- FLUORESCENT LIGHT FIXTURE / EMERGENCY CIRCUIT
- EXISTING LIGHT FIXTURE TO BE REMOVED
- UNDER CABINET FLUORESCENT FIXTURE
- FLUORESCENT STRIP FIXTURE
- FLUORESCENT PENDANT FIXTURE
- RECESSED DOWNLIGHT
- RECESSED ADJUSTABLE DOWNLIGHT
- RECESSED WALL WASHER
- TRACK LIGHTING
- SURFACE MOUNTED LIGHT FIXTURE
- WALL SCONCE
- LIGHT SWITCH
- DIMMER SWITCH
- RETURN AIR
- SUPPLY AIR
- CIRCULAR DIFFUSER
- LINEAR DIFFUSER
- EXHAUST FAN
- FIRE SPRINKLER
- ACCESS DOOR

Lighting Fixture Schedule	
Type Mark	Description
A1	LOW PROFILE LED RECESSED DOWNLIGHT
A2	LOW PROFILE LED RECESSED WALLWASHER
B1	LINEAR LED PENDANT
B2	LINEAR LED PENDANT
C1	2 X 4 RECESSED LED TROFFER
D1	LINEAR LED PENDANT
E1	TRACK MOUNTED LED WALL WASHER
F1	LINEAR LED COVE LIGHT
G1	SUSPENDED LED CYLINDER
H1	SUSPENDED LED ARCHITECTURAL
J1	LINEAR LED PENDANT (DIRECT/INDIRECT)
J2	LINEAR LED PENDANT (DIRECT/INDIRECT)
K1	RECESSED DOWNLIGHT
L1	SUSPENDED LED CYLINDER


ciee
 Council on International Educational Exchange
 300 Fore Street
 Portland, ME

Gensler
 One Beacon Street
 Third Floor
 Boston MA 02108
 (617) 619-5700
 (617) 619-5701

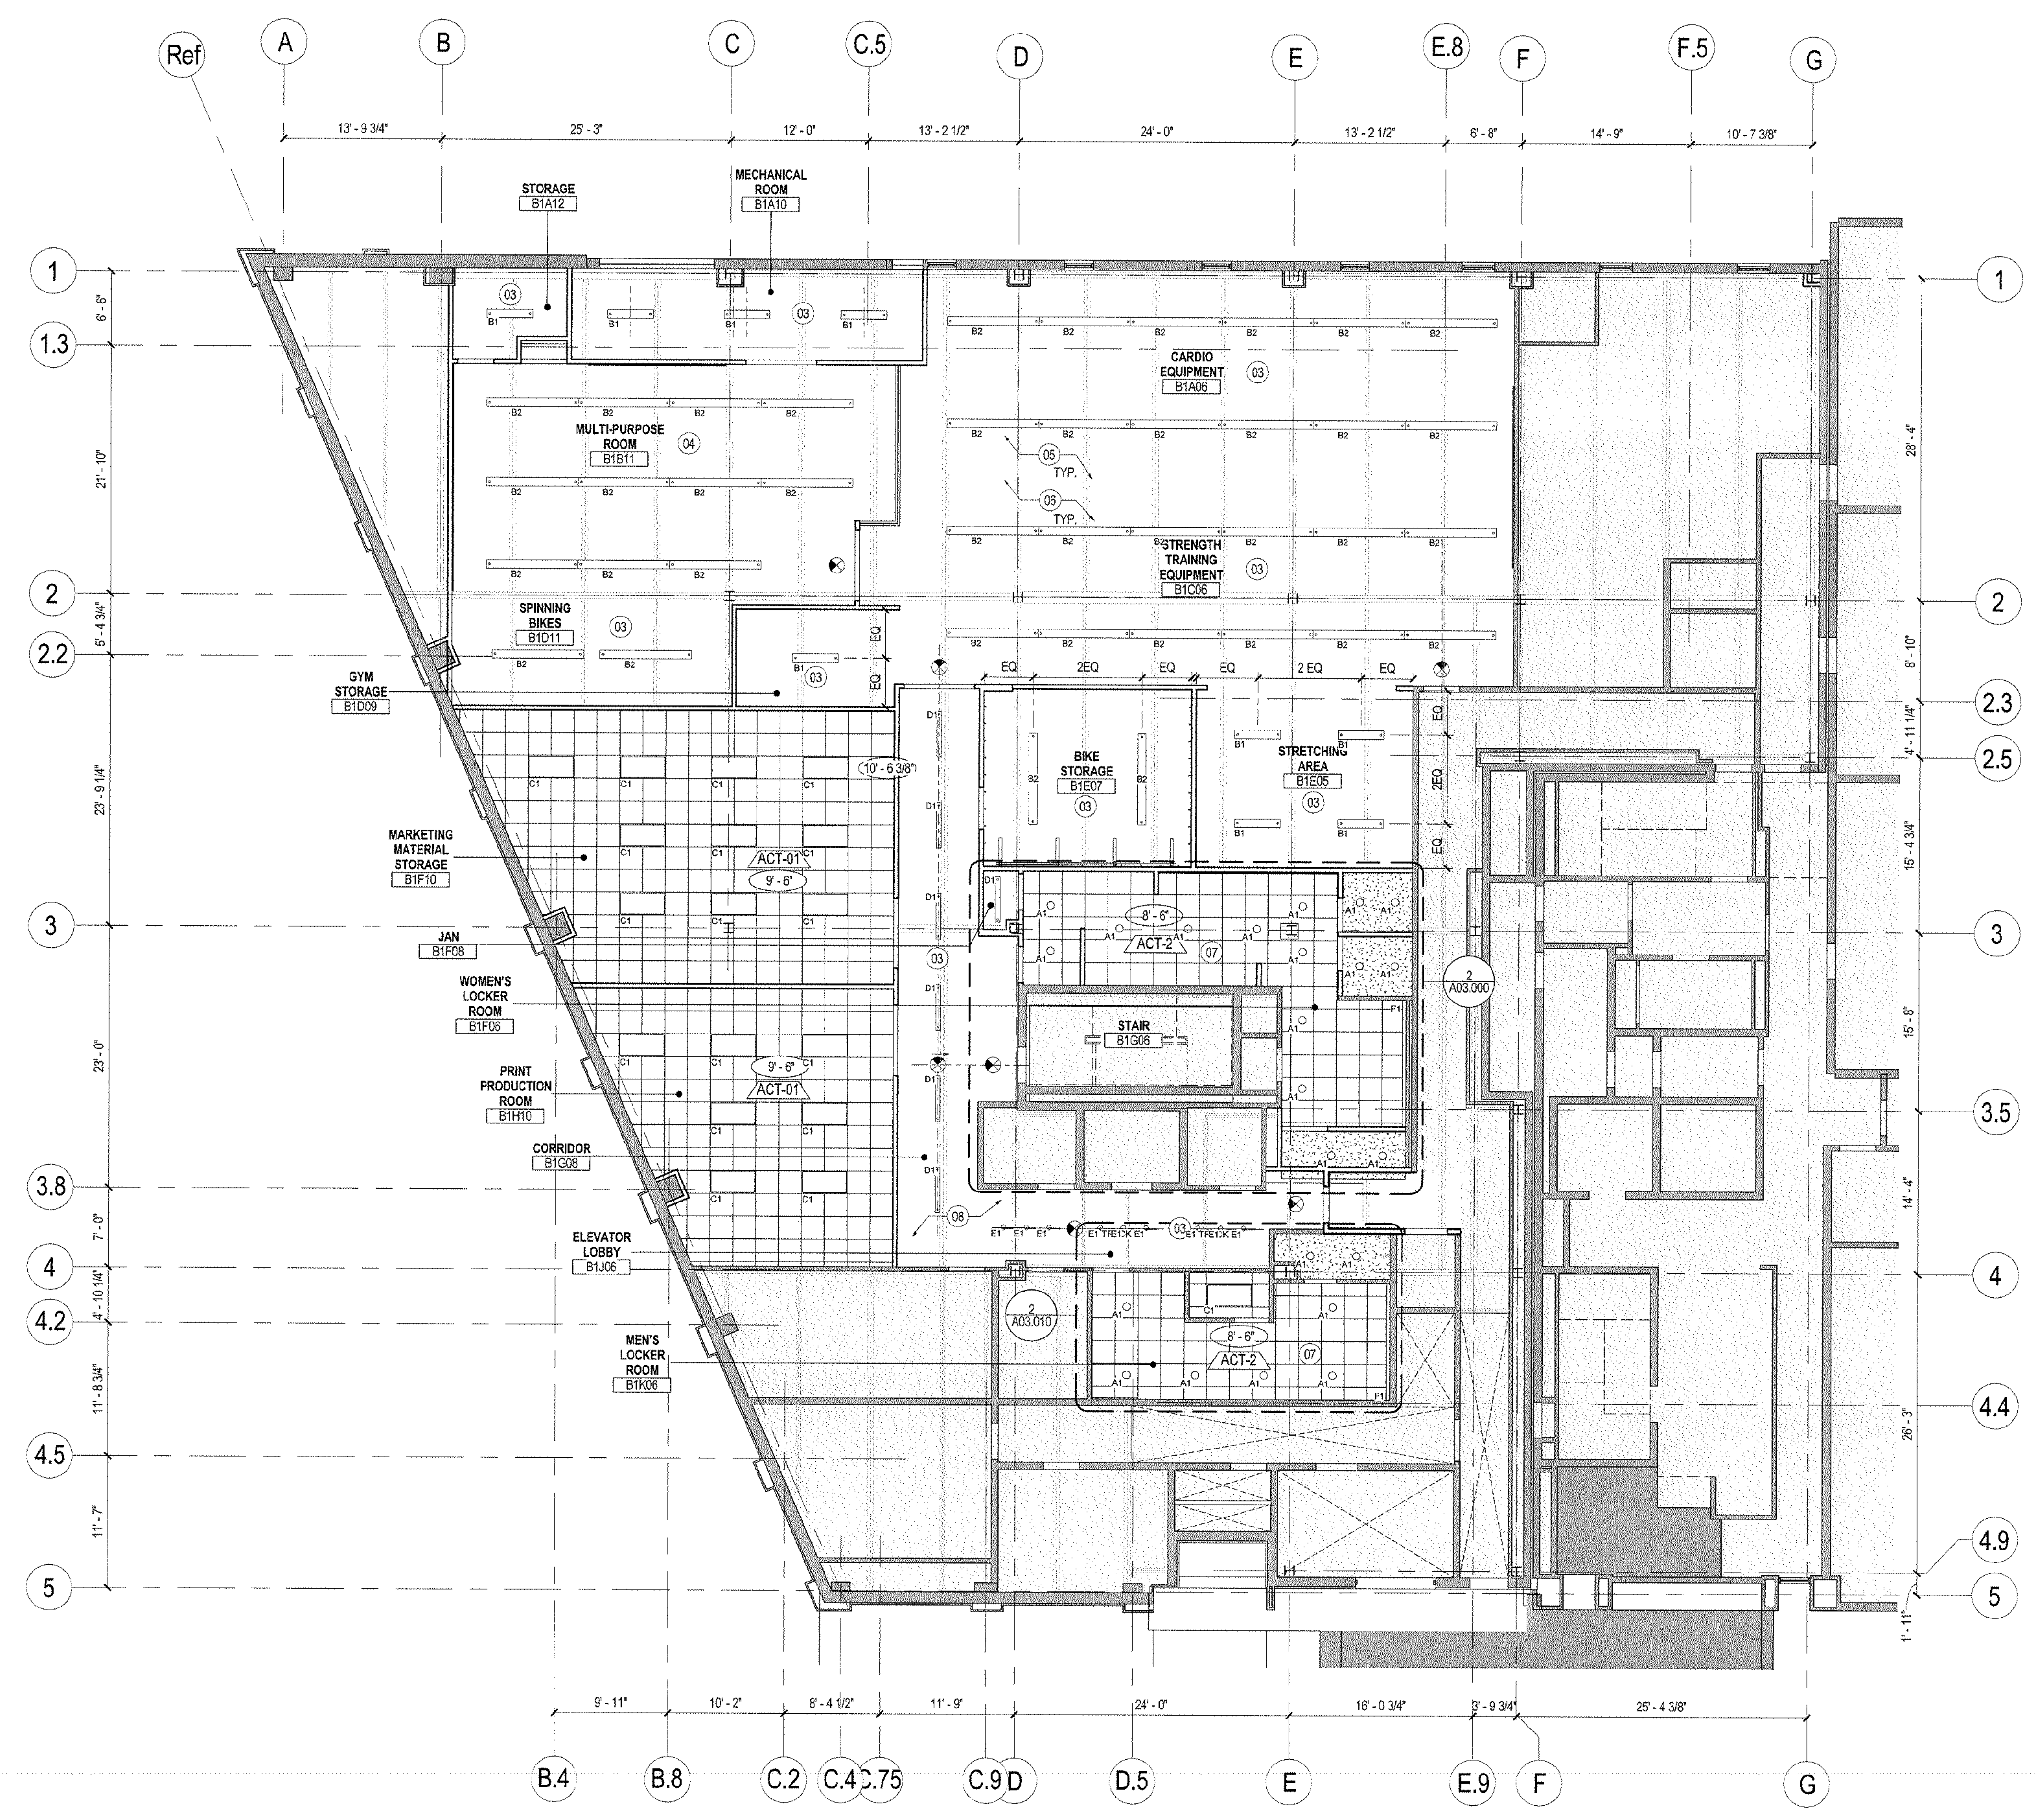

01 REFLECTED CEILING PLAN - BASEMENT LEVEL
 SCALE: 1/8" = 1'-0"


Seal/Signature

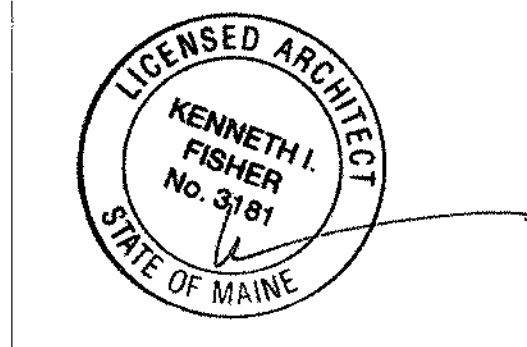

Project Name
 CIEE HQ Renovations

Project Number
 11.7086.000

Description
 REFLECTED CEILING PLAN - BASEMENT LEVEL

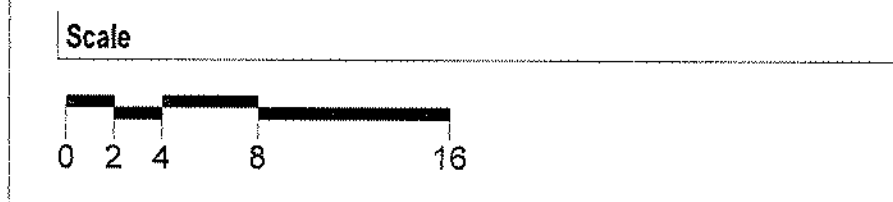

A02.600