

NOTE:

1. SEE SHEET E-001 FOR LEGEND AND GENERAL NOTES.

KEYED NOTE:


- ① MOUNT RECEPTACLE 42" AFF TO BOTTOM OF DEVICE.
- ② SPLIT SYSTEM INDOOR UNIT TO BE FED FROM SAME CIRCUIT AS ROOF MOUNTED CONDENSING UNIT. PROVIDE INTERCONNECTING WIRING BETWEEN INDOOR AND OUTDOOR UNIT AS REQUIRED.

ESB
E.S. BOULOS CO
 ELECTRICAL CONTRACTORS

45 BRADLEY DRIVE
 WESTBROOK, ME 04092
 TEL: (207) 464-3706
 FAX: (207) 464-1833

SM
RT

ARCHITECTURE ENGINEERING PLANNING
 SWRT
 144 Fore Street/P.O. Box 618
 Portland, Maine 04104
 tel. (207) 772-3846
 fax. (207) 772-1070

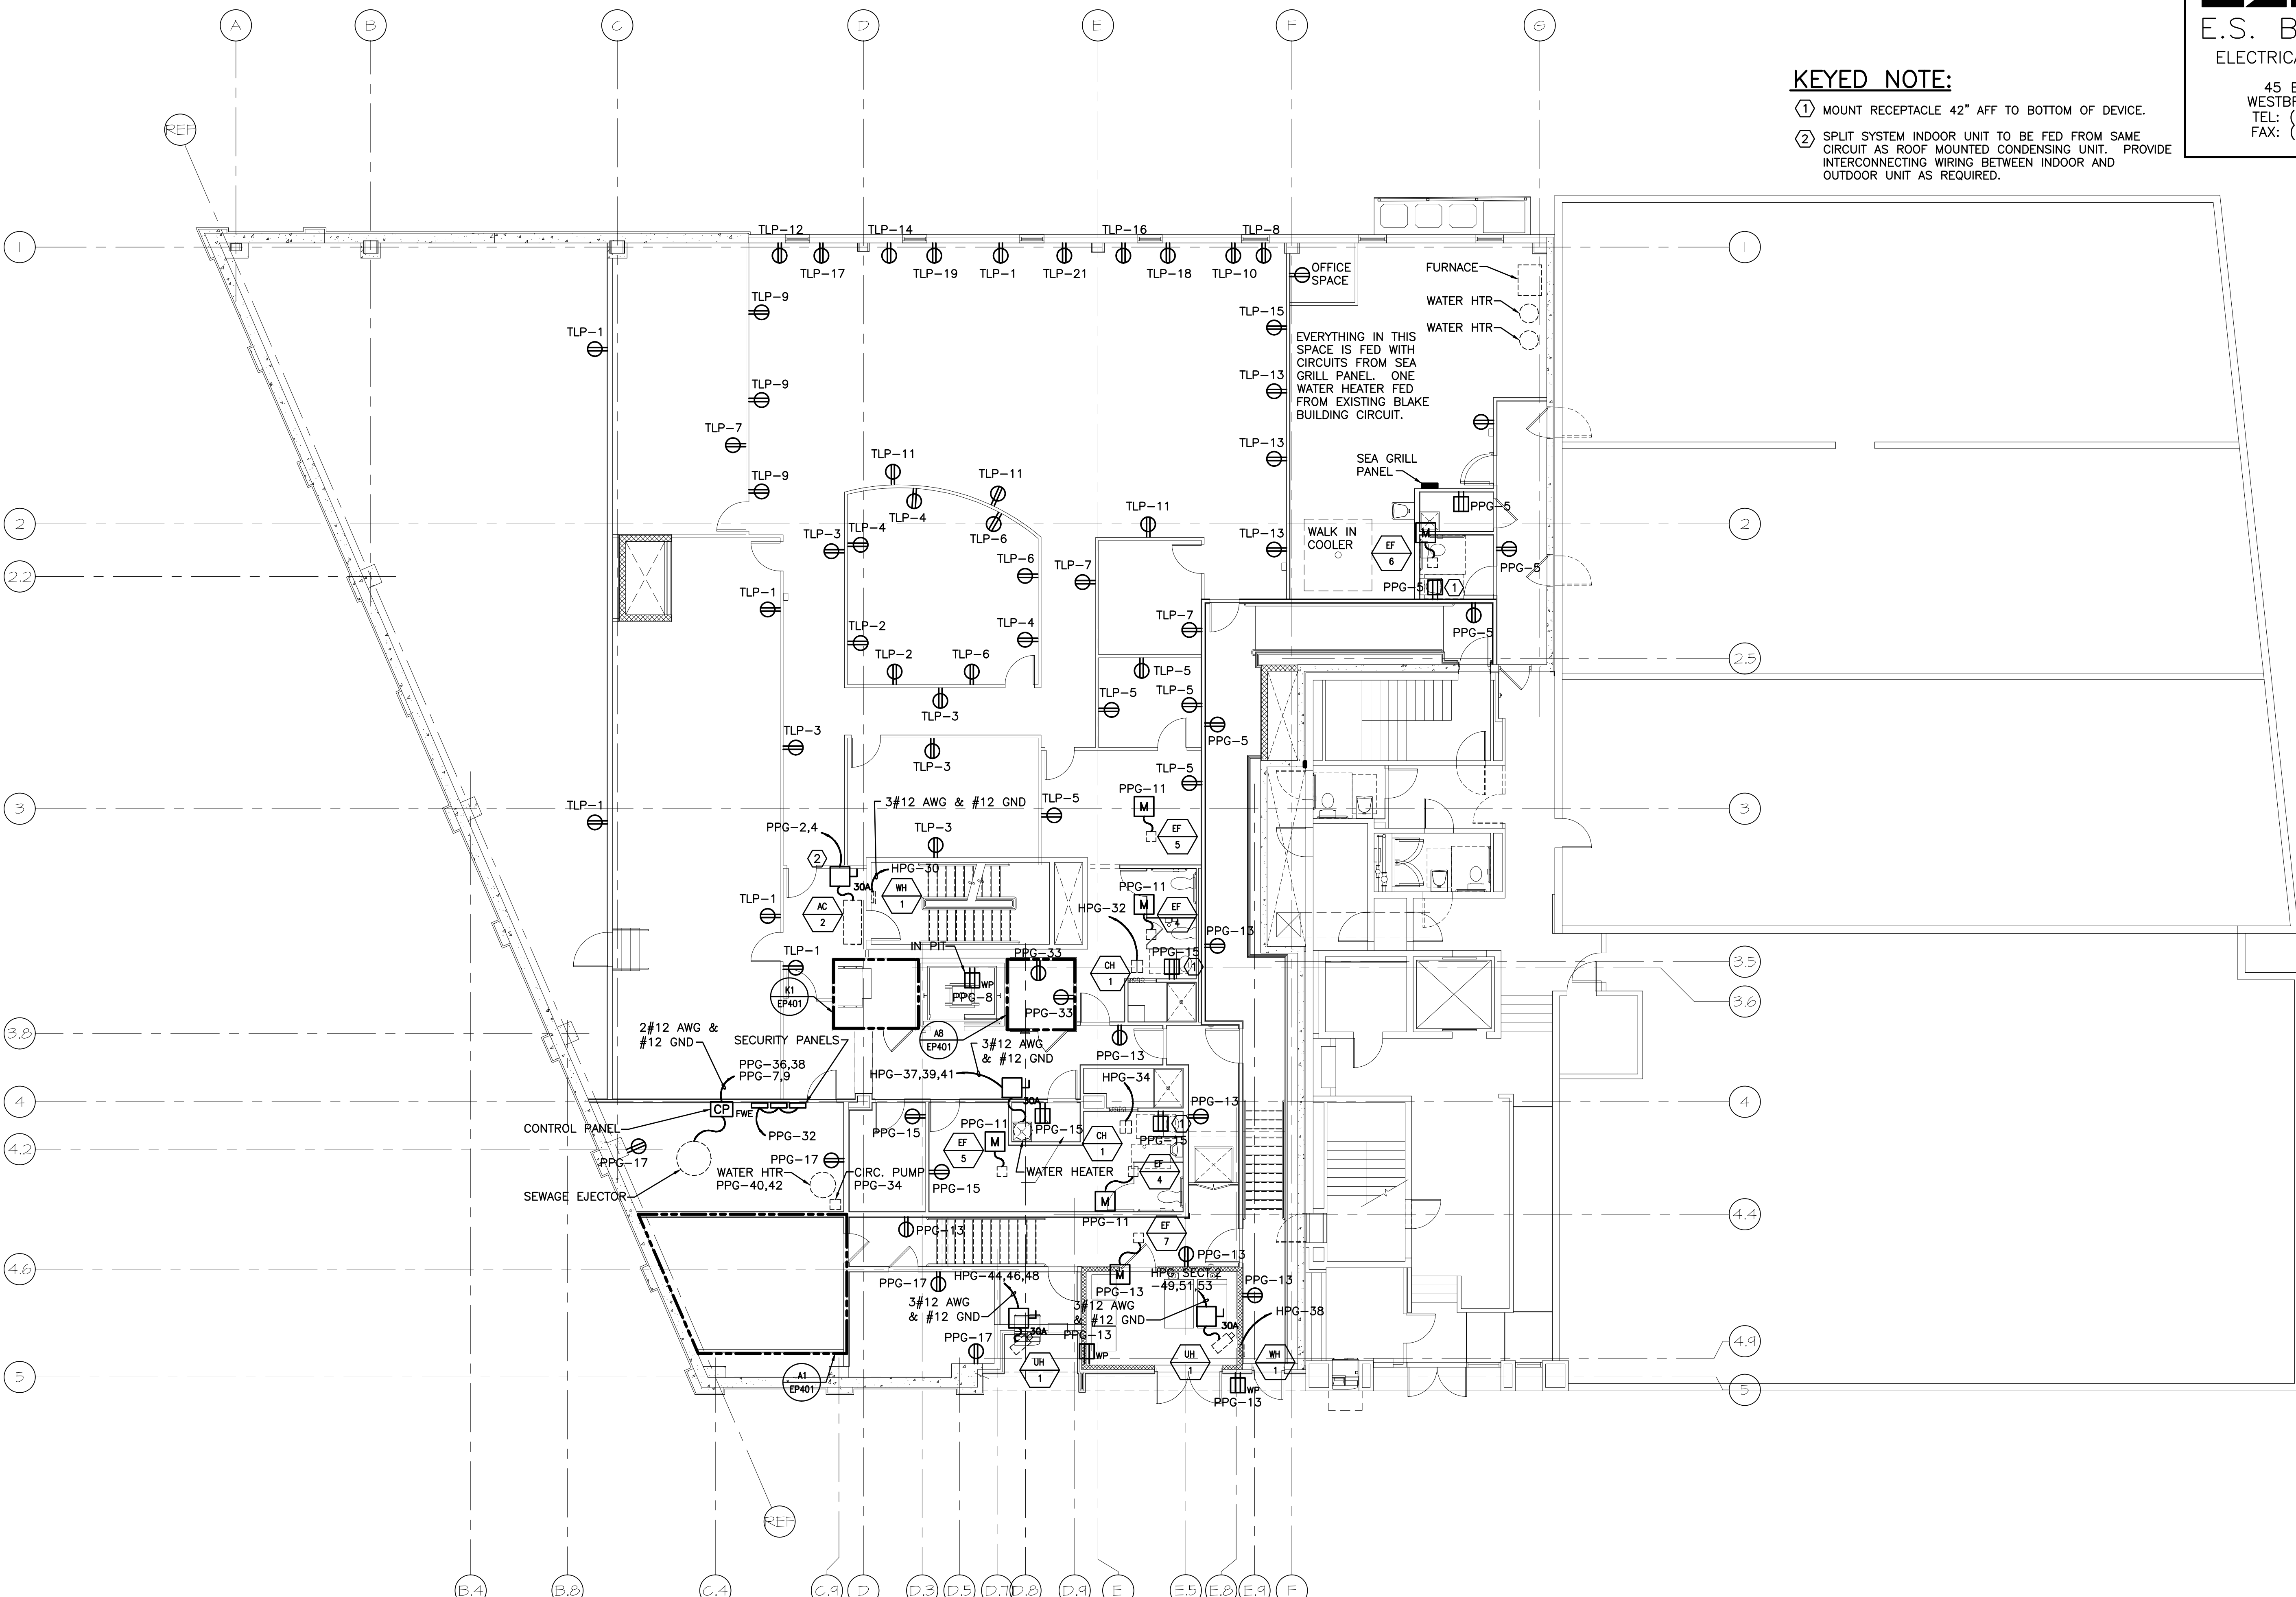

PROJECT TITLE: CUSTOM HOUSE SQUARE FORE STREET PORTLAND, MAINE

CURRENT ISSUE STATUS: RECORD DRAWINGS 9-19-07
 ISSUED FOR REVISION 3-5-07
 ISSUED FOR CONSTRUCTION 12-20-06

REV	DESCRIPTION	DATE
2	RECORD DRAWINGS	9-19-07
1	ISSUED FOR REVISION	3-5-07
0	ISSUED FOR CONSTRUCTION	12-20-06

GRAPHIC SCALE: 0" 1"

SCALE: AS NOTED

PROJECT MANAGER: DJT

JC/DRAWN BY: CDS

A/E OF RECORD: DJT

CAD FILE: EP101-06068

PROJECT NO: 06068

DATE: 12-20-06

SHEET TITLE: LOWER LEVEL FLOOR POWER PLAN

A1 LOWER LEVEL PLAN

1/8"=1'-0"

SHEET No. EP101