

**NOTE:**

1. SEE SHEET E-001 FOR LEGEND AND GENERAL NOTES.

**KEYED NOTE:**

① EXISTING FIRE ALARM CONTROL PANEL TO BE TIED INTO NEW BUILDING FIRE ALARM SYSTEM SO THAT AN INITIATING SIGNAL IN EITHER BUILDING WILL INITIATE NOTIFICATION DEVICES IN BOTH BUILDINGS. SEE SHEET EY102 FOR LOCATION OF NEW BUILDING FIRE ALARM CONTROL PANEL.

**ESB**  
E.S. BOULOS CO  
ELECTRICAL CONTRACTORS

45 BRADLEY DRIVE  
WESTBROOK, ME 04092  
TEL: (207) 464-3706  
FAX: (207) 464-1833

**SMT**  
**RT**

ARCHITECTURE ENGINEERING PLANNING  
SMART  
144 Fore Street/P.O. Box 618  
Portland, Maine 04104  
tel. (207) 775-3846  
fax. (207) 775-1070

CUSTOM HOUSE SQUARE  
FORE STREET  
PORTLAND, MAINE  
RECORD DRAWINGS  
9-19-07

PROJECT TITLE:  
CURRENT ISSUE STATUS:


REV	DESCRIPTION	DATE
2	RECORD DRAWINGS	9-19-07
1	ISSUED FOR REVISION	3-5-07
0	ISSUED FOR CONSTRUCTION	12-20-06

GRAPHIC SCALE:  
0" 1"

SCALE: AS NOTED  
PROJECT MANAGER: DJT  
JC/DRAWN BY: CDS  
A/E OF RECORD: DJT  
CAD FILE: EY101-06068  
PROJECT NO: 06068  
DATE: 12-20-06

SHEET TITLE:  
LOWER LEVEL FLOOR  
SYSTEMS PLAN

SHEET No.  
EY101  
© copyright 2006 SMT LLC

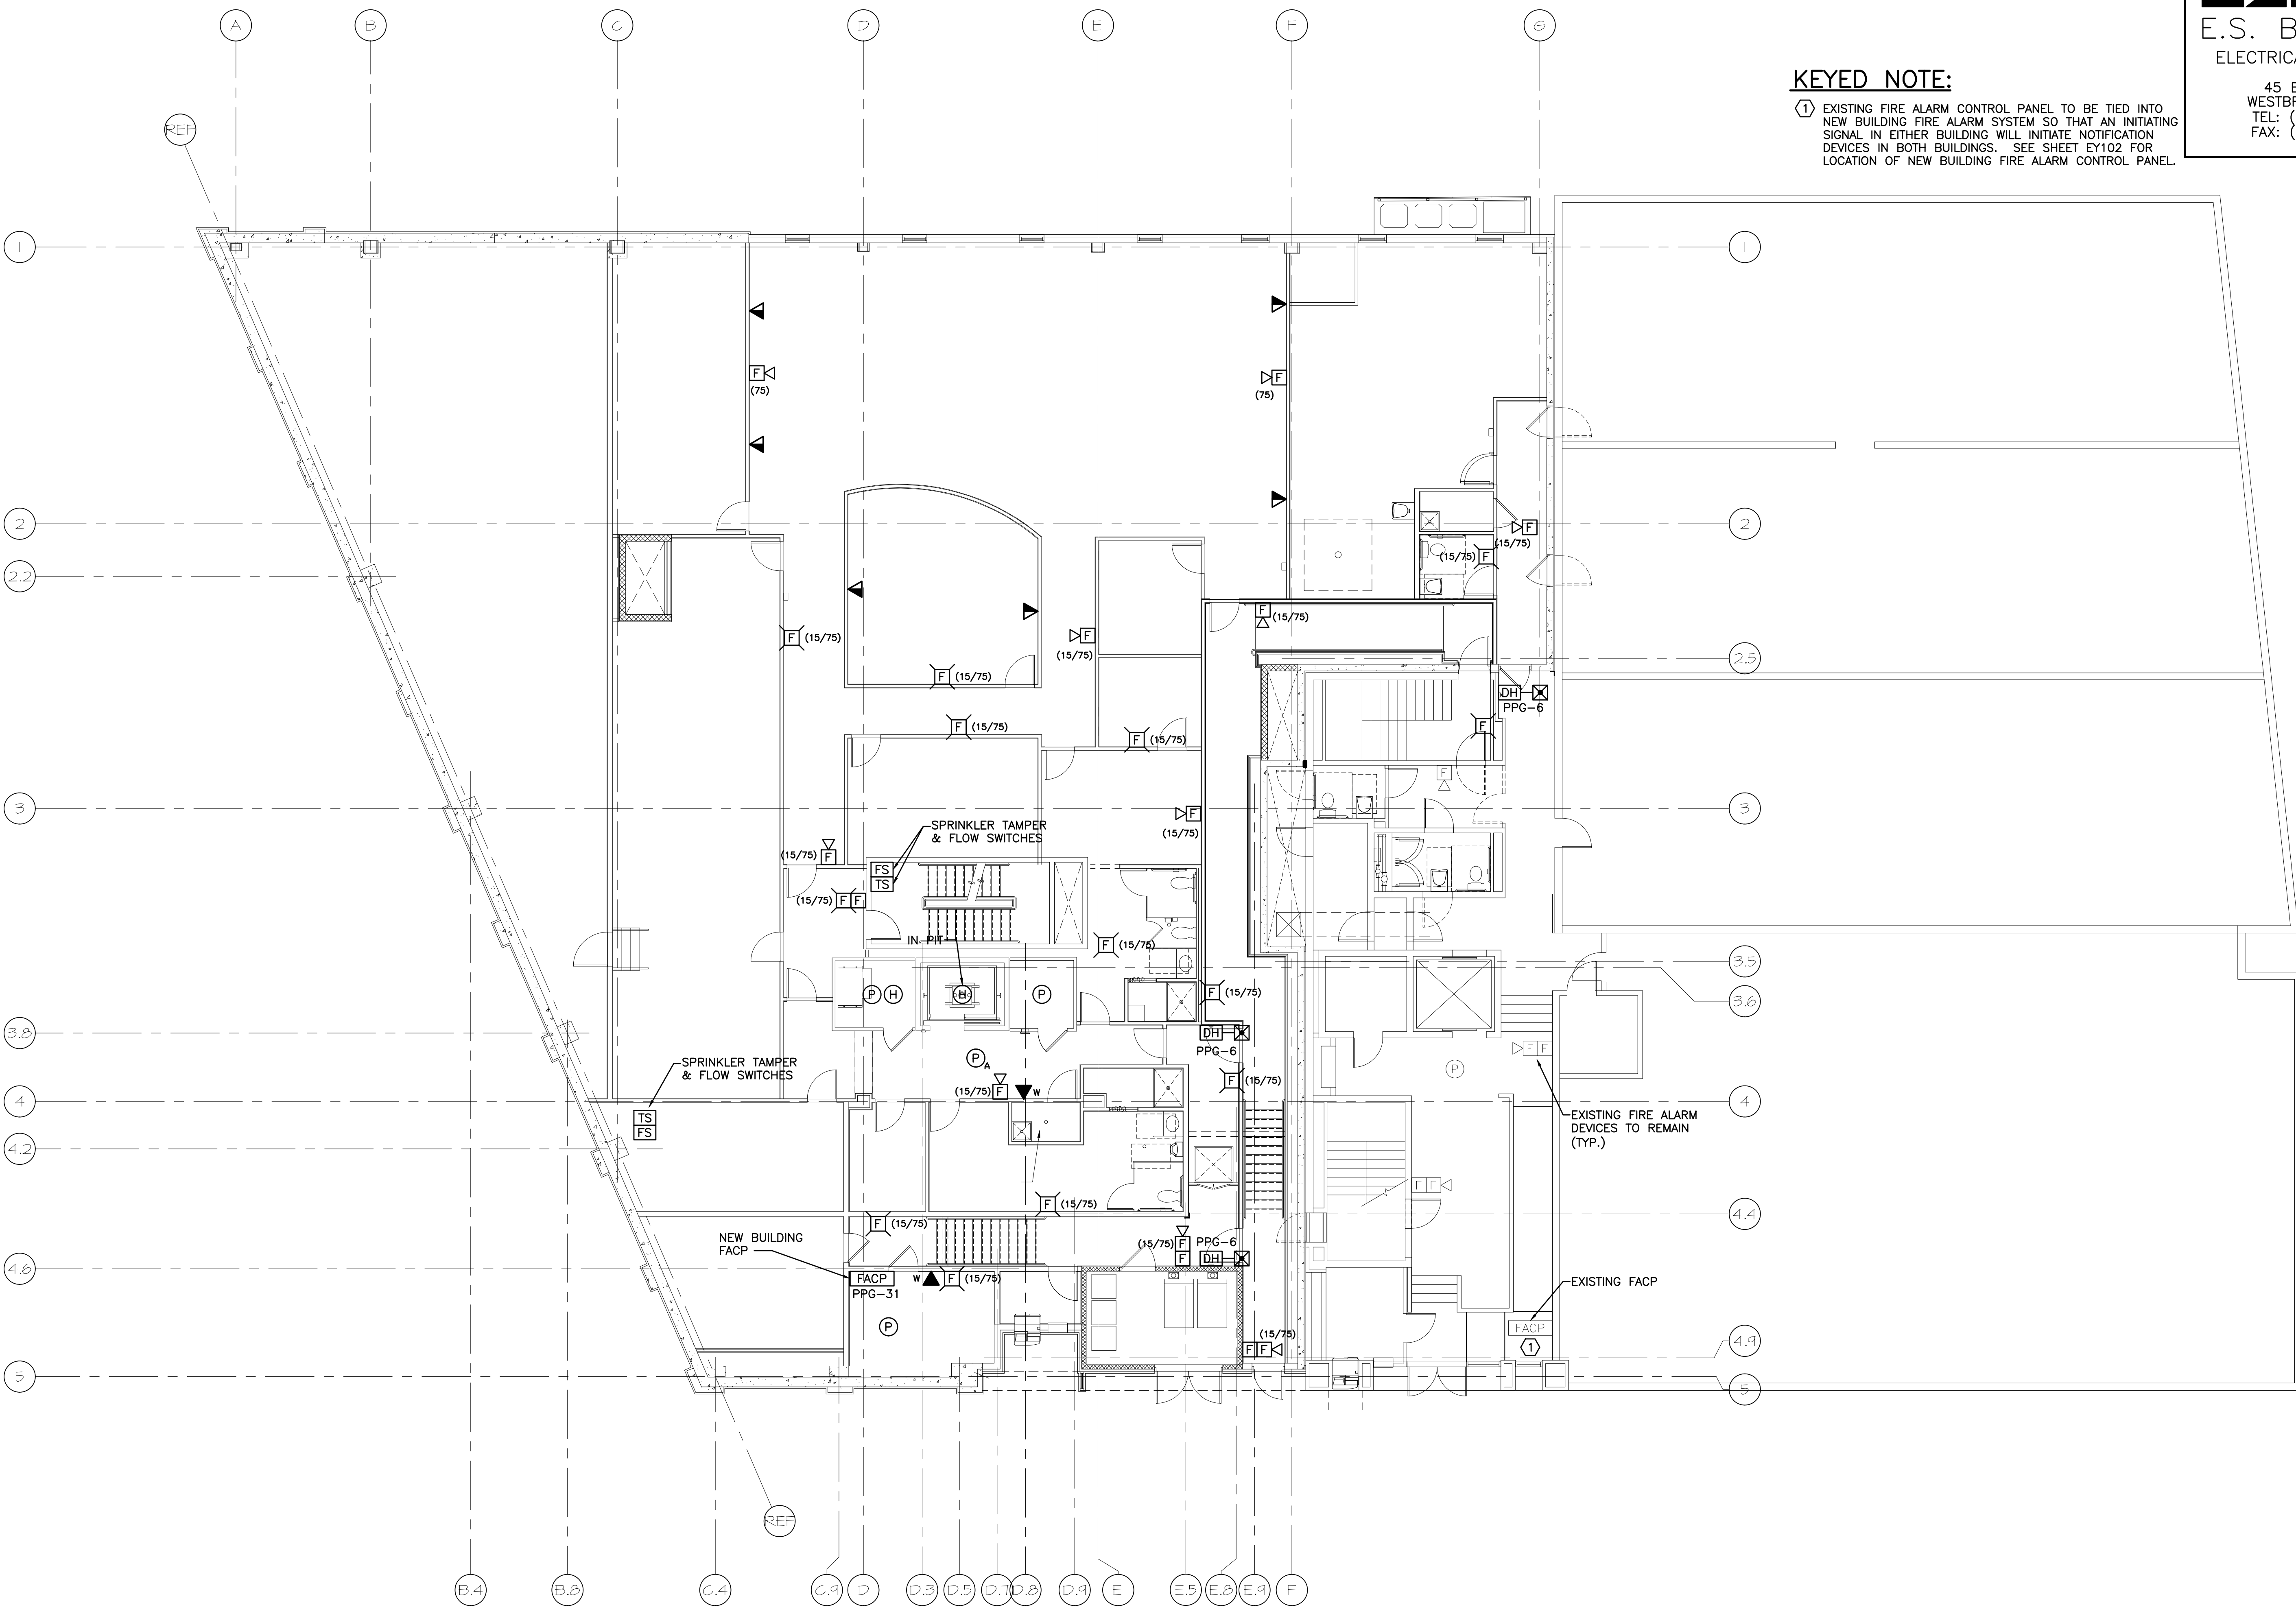

**A1** LOWER LEVEL PLAN

1/8"=1'-0"