

NOTE:


1. SEE SHEET E-001 FOR LEGEND AND GENERAL NOTES.

KEYED NOTE:

- ① PROVIDE SLEEVE IN FLOOR SLAB AT LOCATIONS SHOWN FOR MODULAR FURNITURE TELECOMMUNICATIONS WIRING TO BE INSTALLED BY OWNER.
- ② PROVIDE JUNCTION BOX AND 1" CONDUIT STUB UP, WALL MOUNTED ON COLUMN OR WALL AT LOCATIONS SHOWN FOR MODULAR FURNITURE TELECOMMUNICATIONS WIRING.
- ③ FLOOR BOX TO HAVE DUPLEX OUTLETS AND PROVISIONS FOR OWNER INSTALLED TELECOMMUNICATIONS WIRING.

ESB
E.S. BOULOS CO
 ELECTRICAL CONTRACTORS
 45 BRADLEY DRIVE
 WESTBROOK, ME 04092
 TEL: (207) 464-3706
 FAX: (207) 464-1833

SMRT
 ARCHITECTURE ENGINEERING PLANNING
 SMART
 144 Fore Street/P.O. Box 618
 Portland, Maine 04104
 tel. (207) 775-3846
 fax. (207) 775-1070

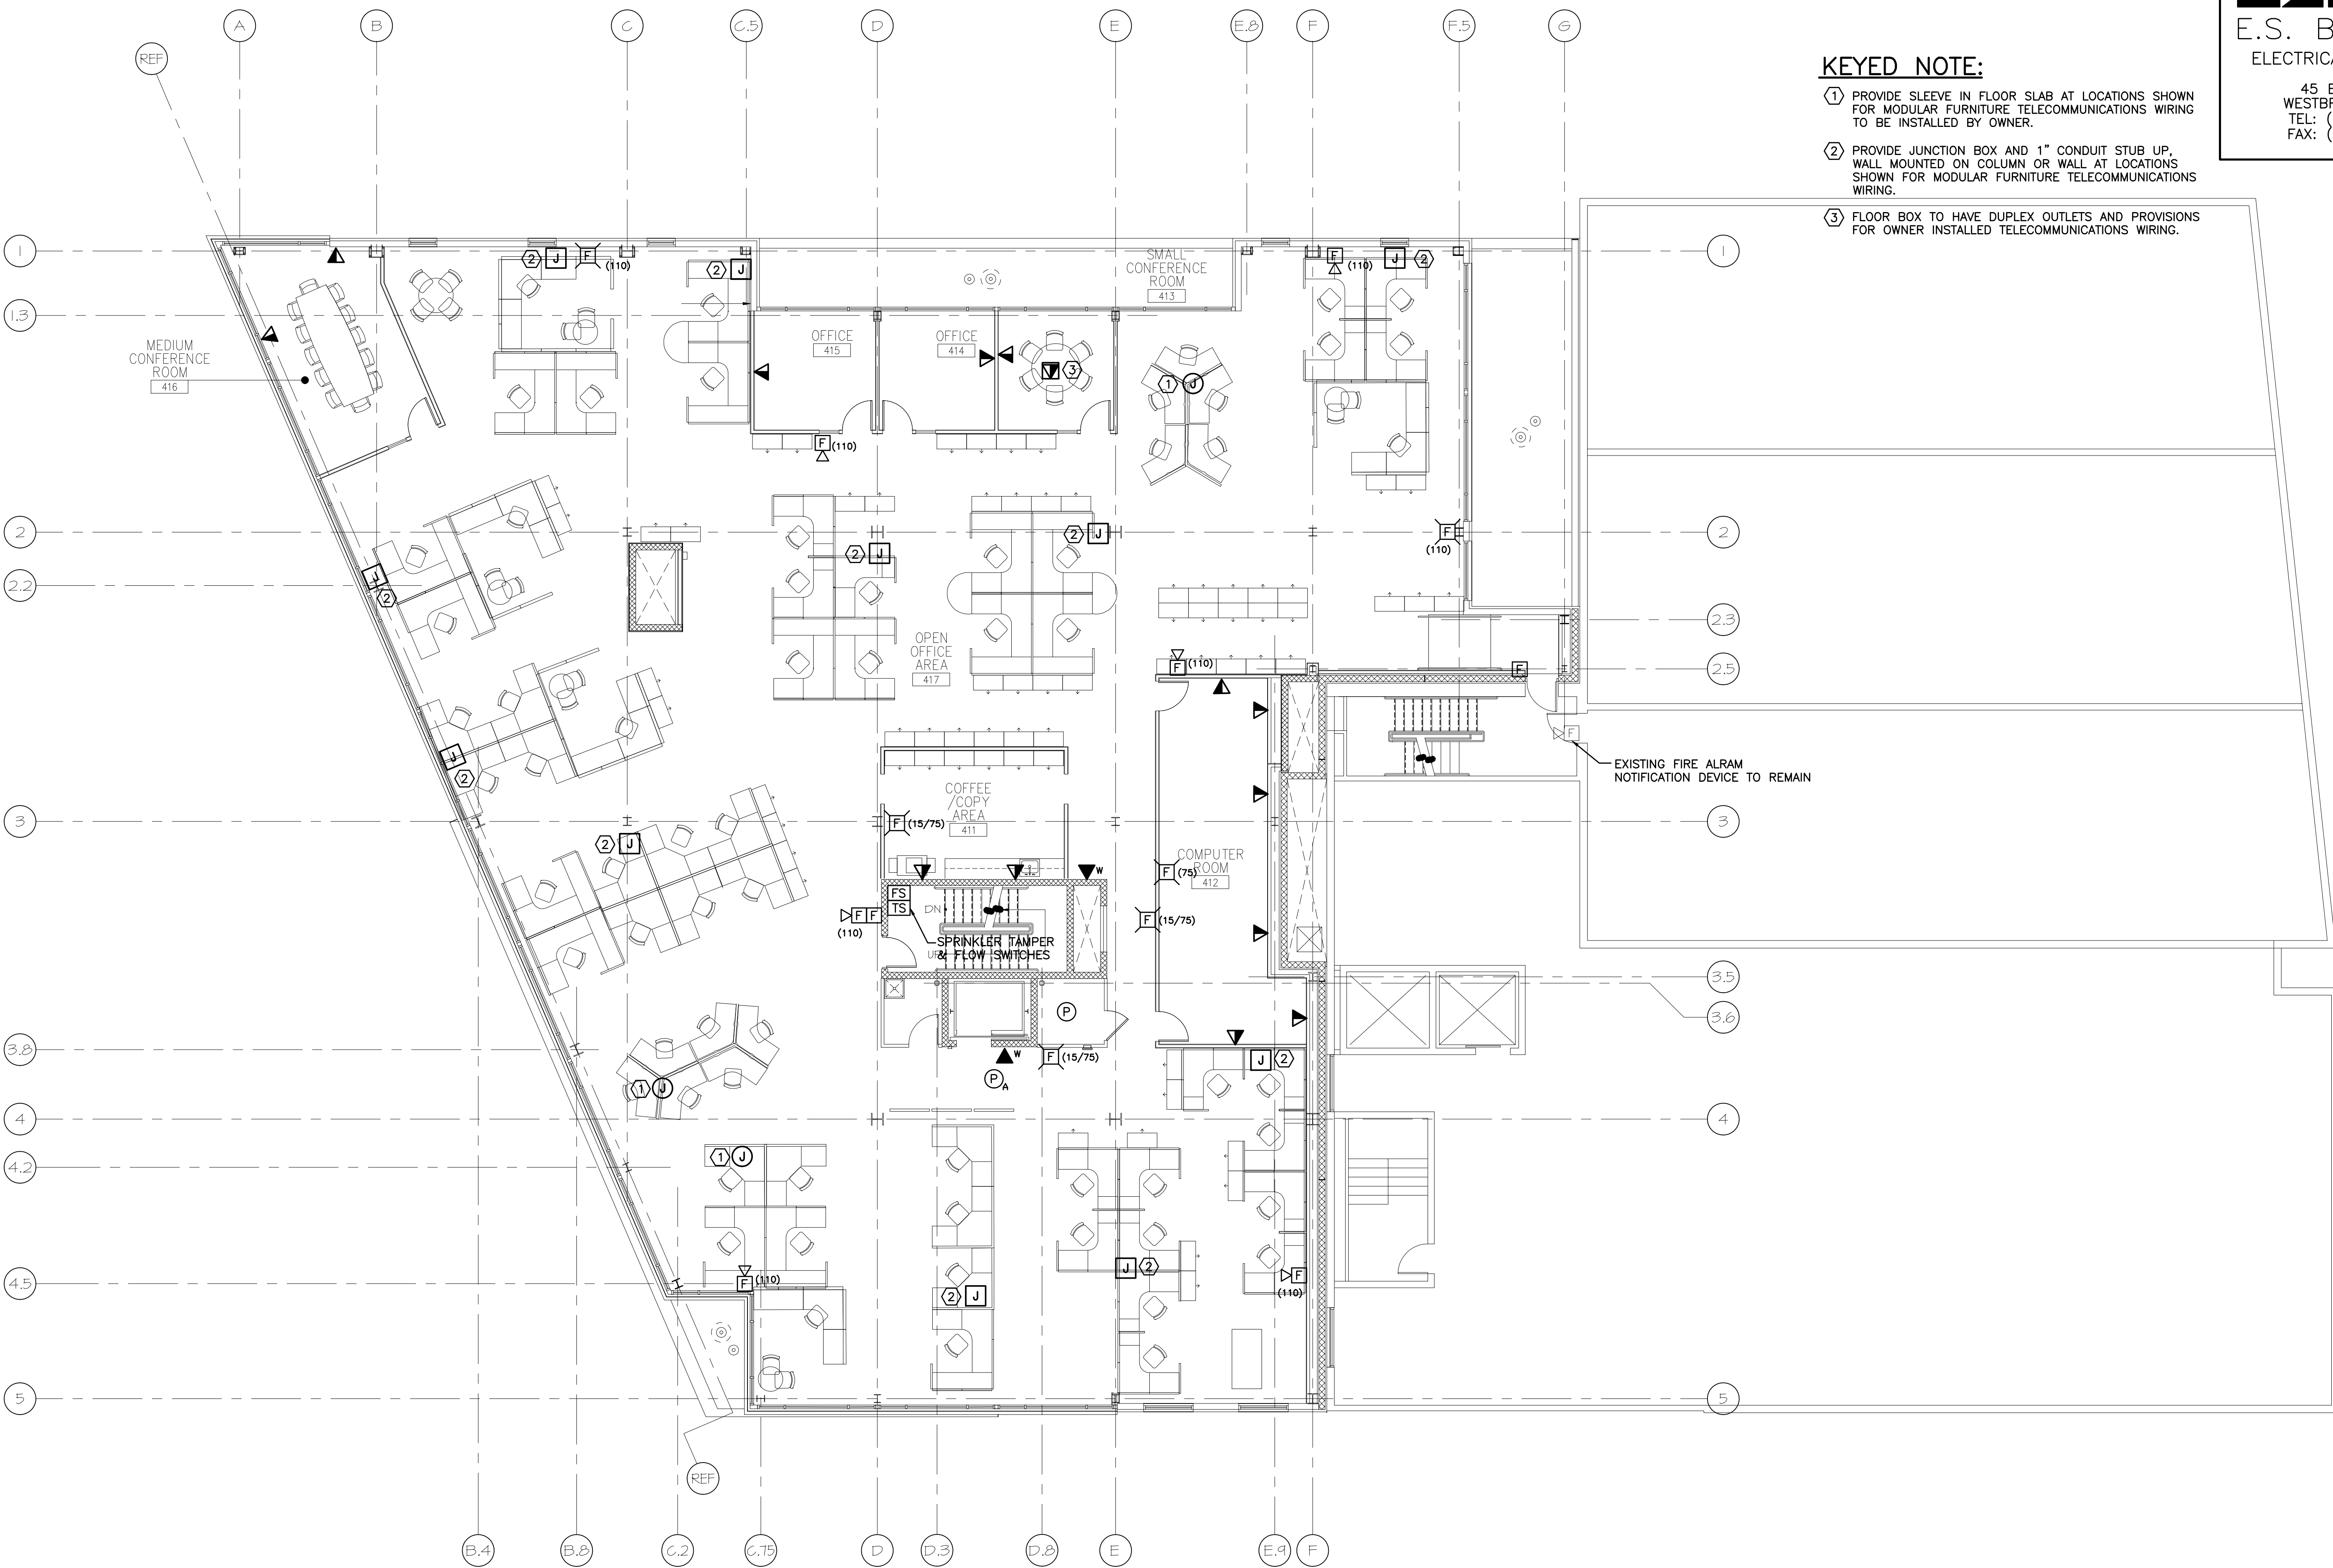

CUSTOM HOUSE SQUARE
 FORE STREET
 PORTLAND, MAINE

RECORD DRAWINGS
 9-19-07

REV	DESCRIPTION	DATE
2	RECORD DRAWINGS	9-19-07
1	ISSUED FOR REVISION	3-5-07
0	ISSUED FOR CONSTRUCTION	12-20-06

GRAPHIC SCALE:
 0" 1"
 SCALE: AS NOTED
 PROJECT MANAGER: DJT
 JC/DRAWN BY: CDS
 A/E OF RECORD: DJT
 CAD FILE: EY105-06068
 PROJECT NO: 06068
 DATE: 12-20-06

A1 FOURTH FLOOR PLAN

1/8"=1'-0"

SHEET TITLE:
FOURTH FLOOR SYSTEMS PLAN
 SHEET No.
EY105