


NOTE:
 1. SEE SHEET E-001 FOR LEGEND AND GENERAL NOTES.
 2. PROVIDE EMPTY OUTLET BOX AND 3/4" CONDUIT W/PULL STRING TO ABOVE AN ACCESSIBLE CEILING FOR ALL TELECOMMUNICATIONS DEVICES SHOWN. TELECOMMUNICATIONS WIRING TO BE BY OWNER.

KEYED NOTE:
 ① PROVIDE SLEEVE IN FLOOR SLAB AT LOCATIONS SHOWN FOR MODULAR FURNITURE TELECOMMUNICATIONS WIRING TO BE INSTALLED BY OWNER.
 ② PROVIDE JUNCTION BOX AND 1" CONDUIT STUB UP, WALL MOUNTED ON COLUMN OR WALL AT LOCATIONS SHOWN FOR MODULAR FURNITURE TELECOMMUNICATIONS WIRING.

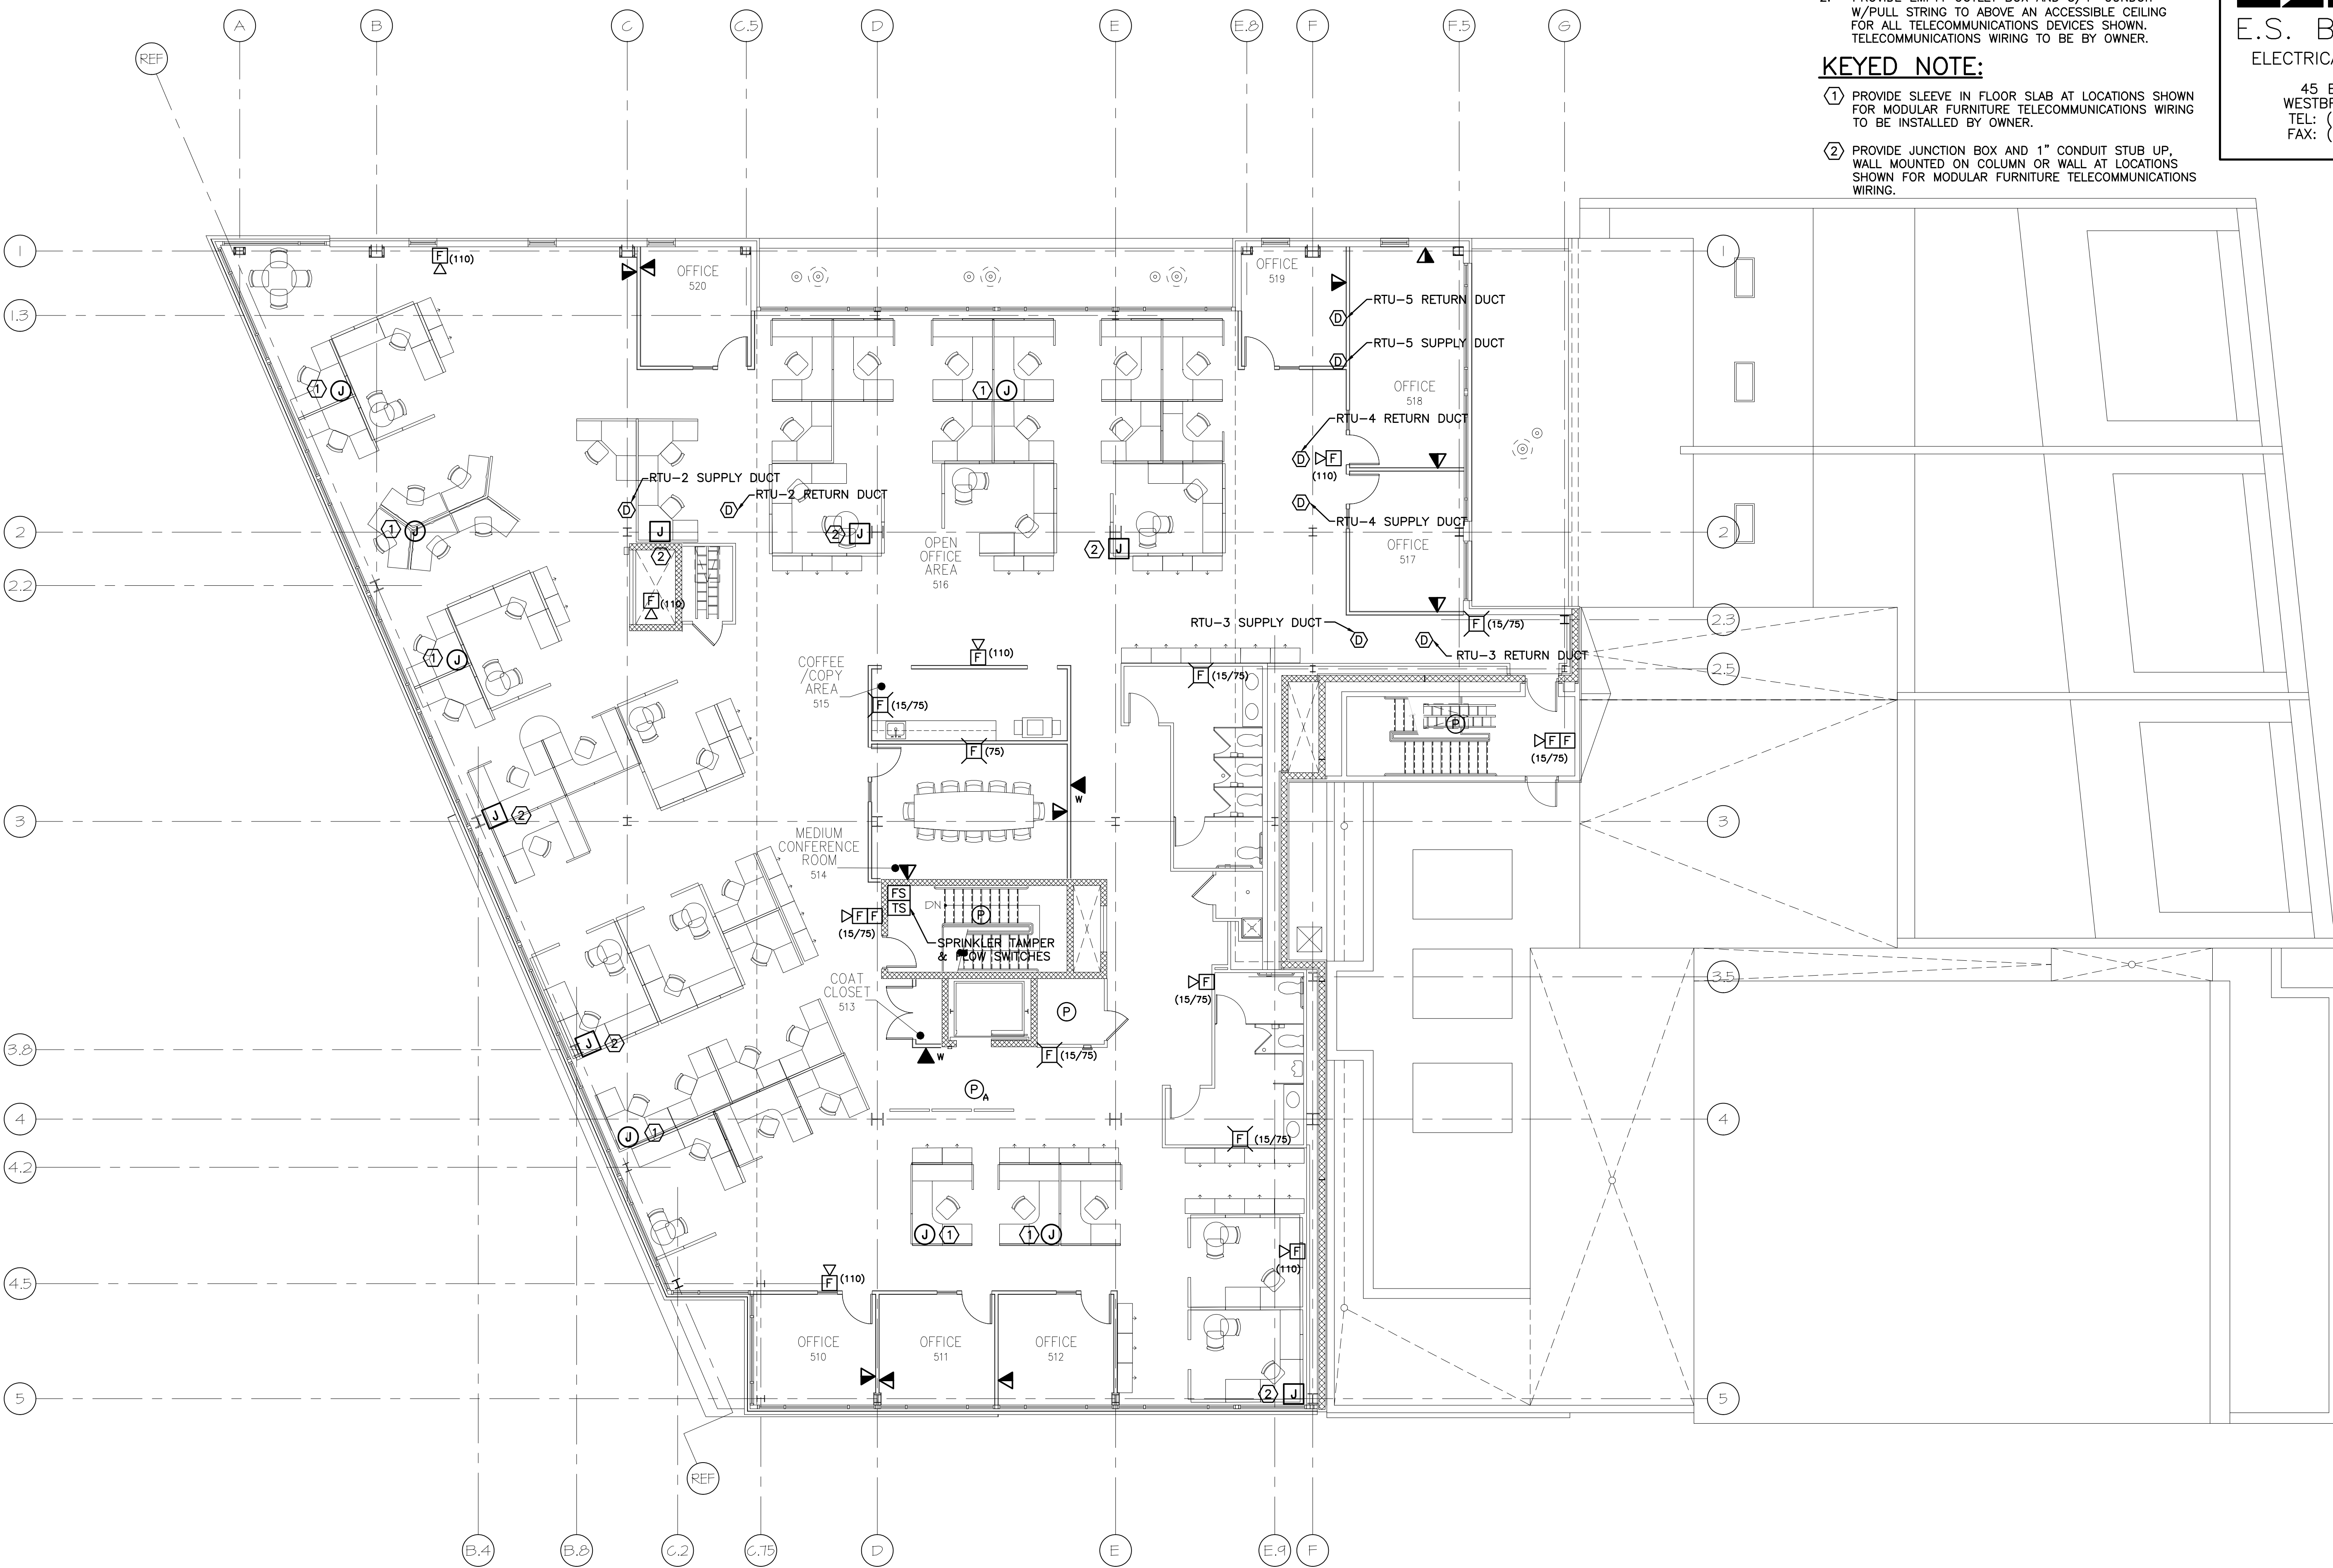

PROJECT TITLE: CUSTOM HOUSE SQUARE FORE STREET PORTLAND, MAINE
 CURRENT ISSUE STATUS: RECORD DRAWINGS 9-19-07
 ISSUED FOR REVISION 3-5-07
 ISSUED FOR CONSTRUCTION 12-20-06

REV	DESCRIPTION	DATE
2	RECORD DRAWINGS	9-19-07
1	ISSUED FOR REVISION	3-5-07
0	ISSUED FOR CONSTRUCTION	12-20-06

GRAPHIC SCALE: 0" 1"
 SCALE: AS NOTED
 PROJECT MANAGER: DJT
 JC/DRAWN BY: CDS
 A/E OF RECORD: DJT
 CAD FILE: EY106-06068
 PROJECT NO: 06068
 DATE: 12-20-06

SHEET TITLE: FIFTH FLOOR SYSTEMS PLAN

A1 FIFTH FLOOR PLAN

1/8"=1'-0"