


ENLARGED CORE AREA PLAN
SCALE: 1/8" = 1'-0"



FOURTH FLOOR PLAN
SCALE: 1/8" = 1'-0"

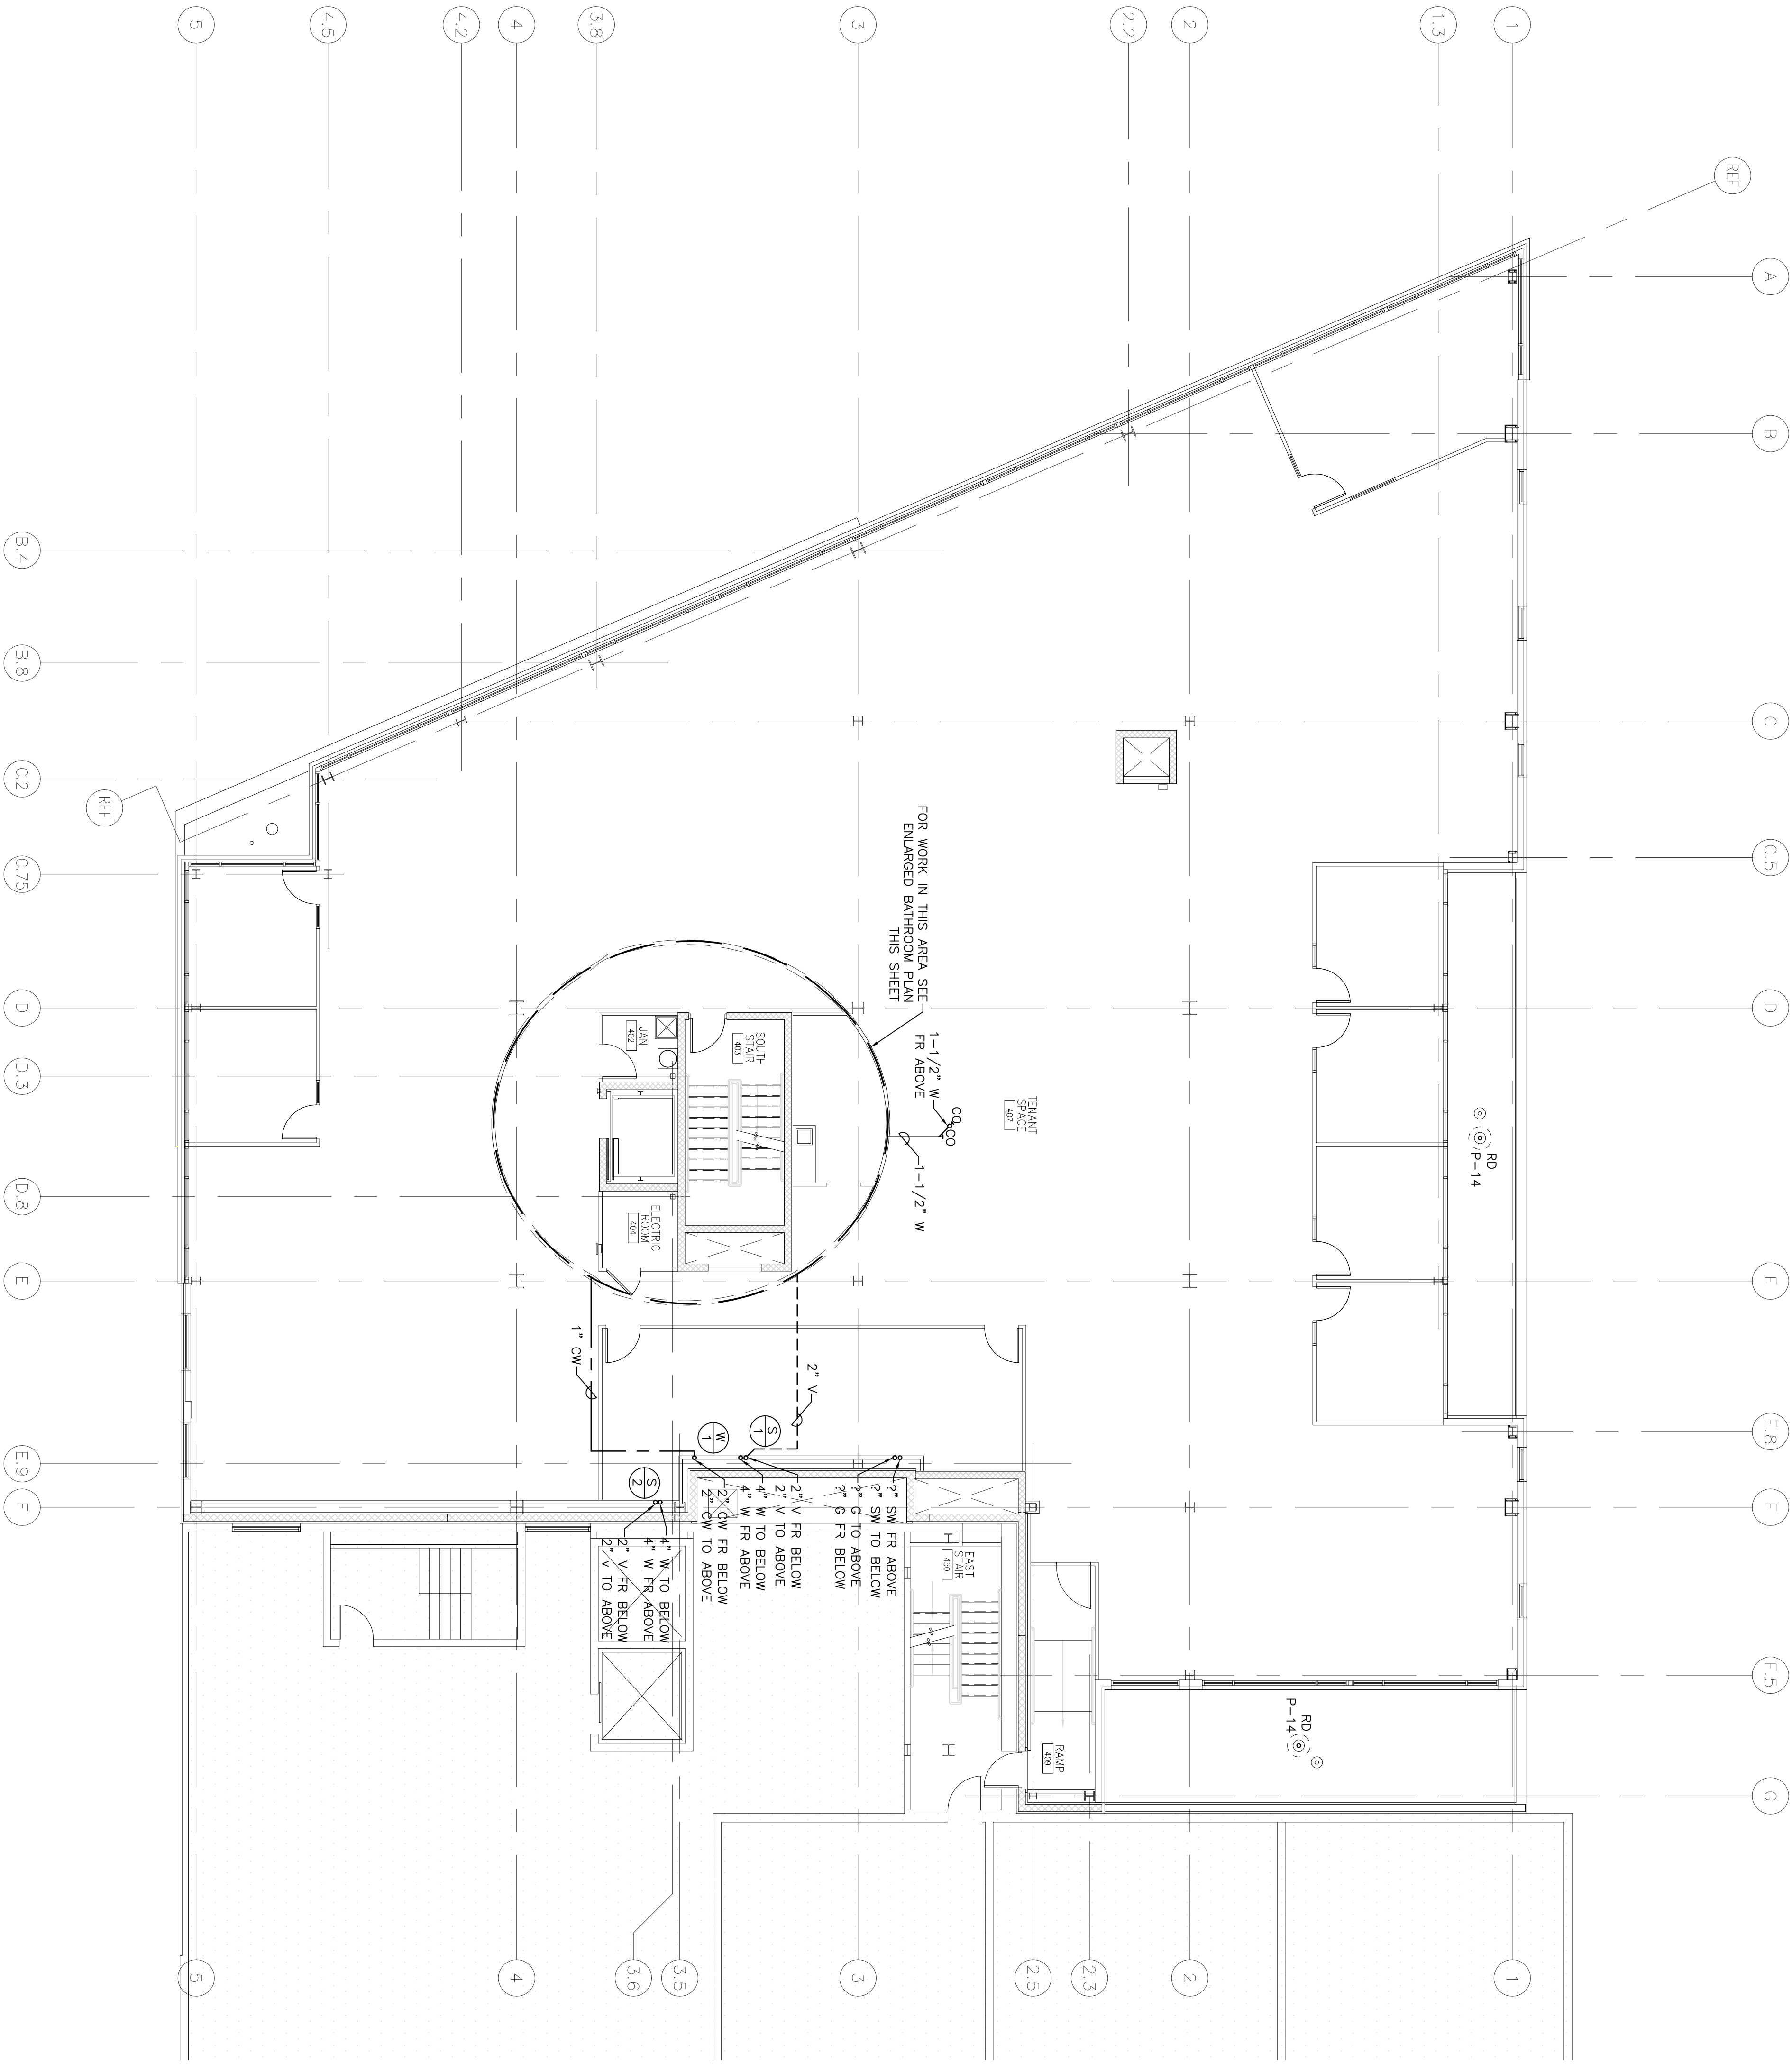

CUSTOM HOUSE SQUARE
300 FORE STREET
PORTLAND, MAINE
FOURTH FLOOR PLUMBING PLAN

Atlantic Comfort Systems, Inc.
PO BOX 665-392 HILL STREET
BIDDEFORD, MAINE 04005
PHONE: (207) 284-6360
FAX: (207) 284-6377

INTEGRATED ENGINEERED SYSTEMS, INC.
 ▲ MECH. DESIGN ▲ ENERGY MGT. ▲ INDOOR AIR QUALITY
 P.O. BOX 657 AUBURN, N.H. 03032
 Tel: (603) 625-1346 Fax: (603) 625-8456

P2.4

P.E.: JK D.B.: CLB
PROJECT #: J493
ISSUE DATE: SEPT. 19, 2006