


ENLARGED BATHROOM PLAN

SCALE: 1/8" = 1'-0"

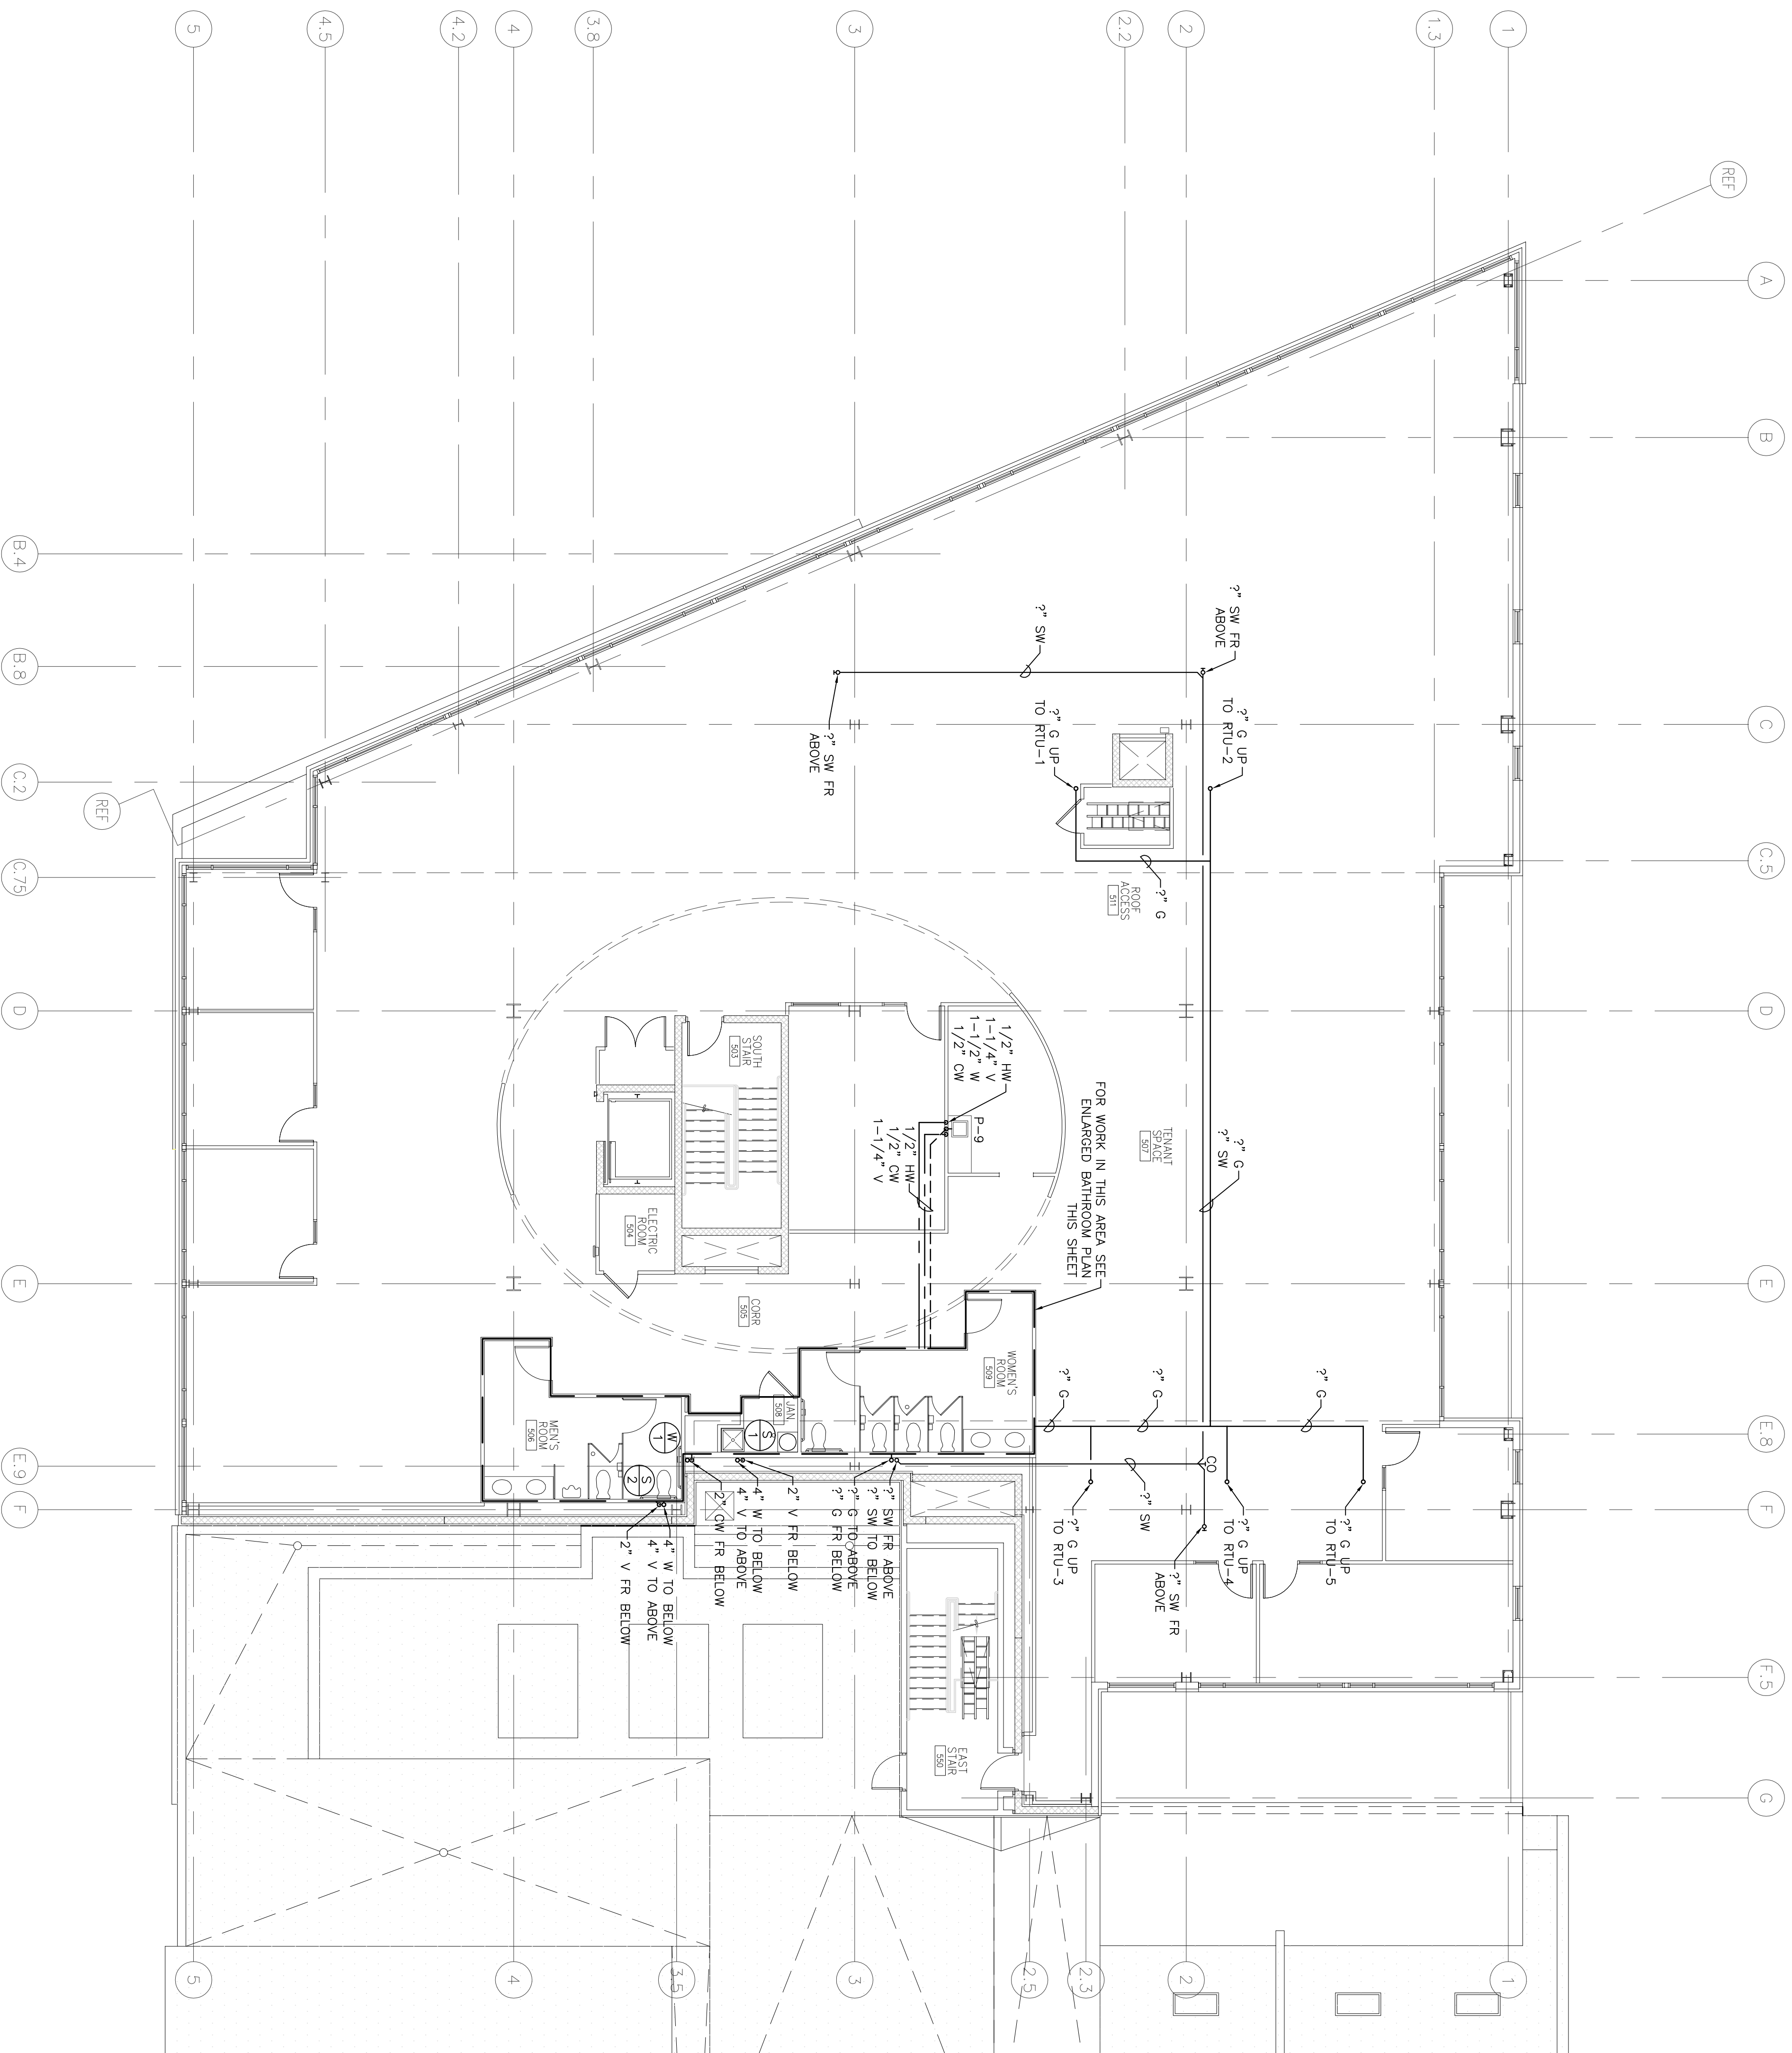

FIFTH FLOOR PLAN

SCALE: 1/8" = 1'-0"



PROJECT NORTH


CUSTOM HOUSE SQUARE

300 FORE STREET
PORTLAND, MAINE

FIFTH FLOOR PLUMBING PLAN



Atlantic Comfort
Systems, Inc.
PO BOX 665-392 HILL STREET
BIDDEFORD, MAINE 04005
PHONE: (207) 284-6360
FAX: (207) 284-6377

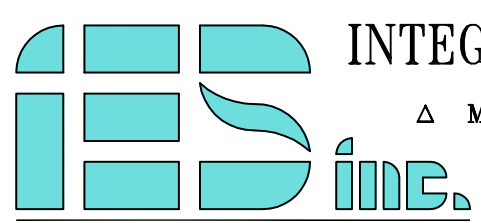

INTEGRATED ENGINEERED SYSTEMS, INC.

△ MECH. DESIGN △ ENERGY MGT. △ INDOOR AIR QUALITY
P.O. BOX 657 AUBURN, N.H. 03032
Tel: (603) 625-1346 Fax: (603) 625-8456

P2.5

ISSUE DATE: SEPT. 19, 2006
PROJECT #: J493
P.E.: JK D.B.A.: CLB