


REVISION	0	ISSUED FOR REVIEW & APPROVAL	1/24/2014
DESCRIPTION			
DATE			

RESERVED FOR CITY STAMP

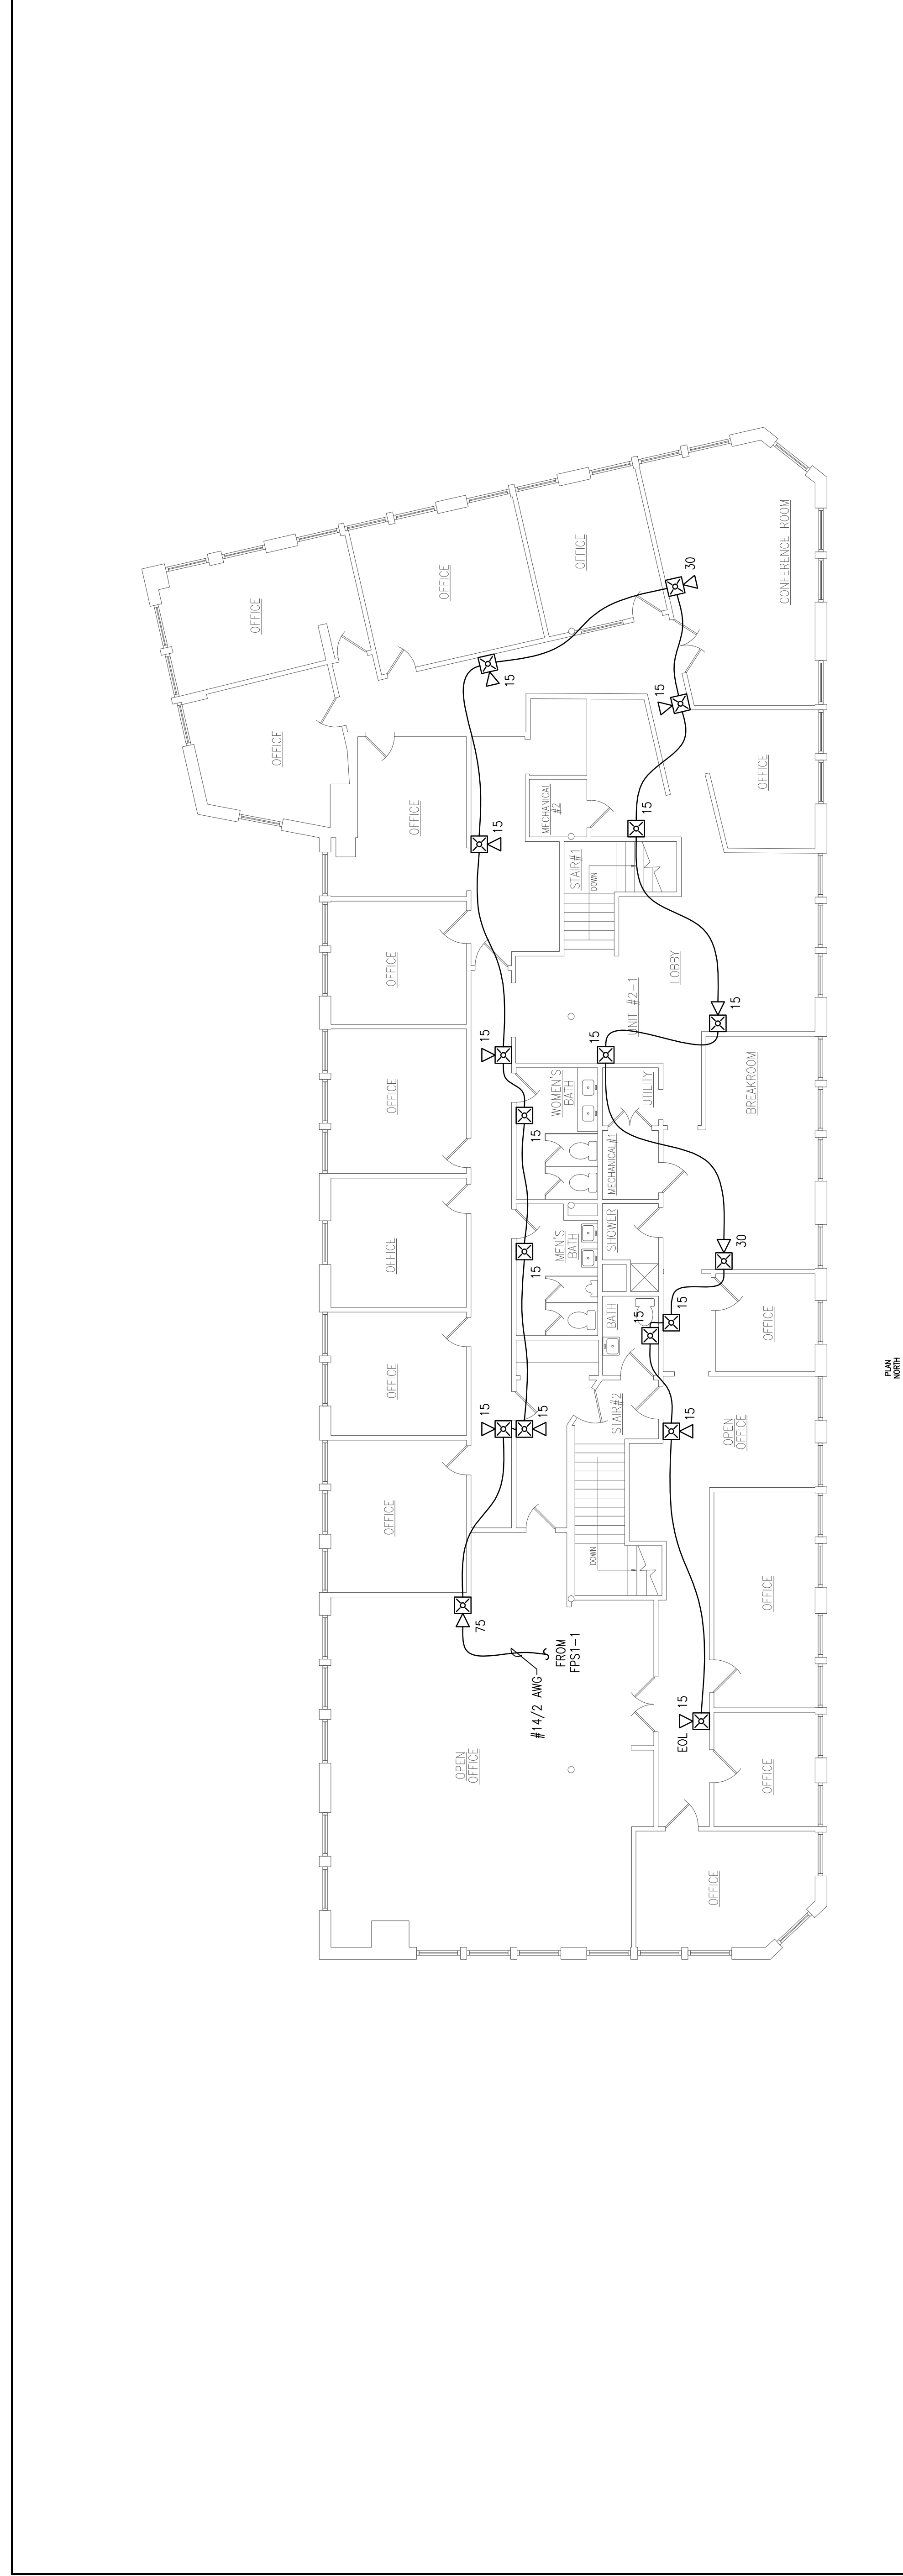

PLAN NORTH
SECOND FLOOR FIRE ALARM PLAN
 SCALE: 1/8"=1'-0"

CUNNINGHAM
 Security Systems
 10 Princes Point Road, Yarmouth, Maine 04096
 Office: 207.846.3350 • Fax: 207.846.6080

COMMERCIAL PROPERTIES, INC.
 80-90 MIDDLE STREET
 PORTLAND, MAINE 04101
SECOND FLOOR FIRE ALARM PLAN

DRAWN	JPB	UNICAD JOB #14028
CHECKED	WAYNE B. HAWES	NCET # 90496
DATE	1/23/2014	
REVISION	0	
SCALE	1/8"=1'-0"	

UNICAD Inc.
 575 W. 40TH ST.
 PORTLAND, ME 04101
 www.unicad.net

FA-3