


NOTE  
1) SEE LIFE SAFETY PLAN FOR ELECTRICAL EXIT SIGNS & EMERGENCY LIGHT

FIXTURE LEGEND		MATERIAL LEGEND	
○	SURFACE-MOUNTED LED FIXTURES	[Stippled Pattern]	GYPSUM CEILING
○	W/ADJUSTABLE HEADS	[Horizontal Lines]	1/8" ROUGH SAWN SHIP LAP
⊙	PENDANT LIGHTS	[Vertical Lines]	PLYWOOD TOP OF JOISTS
\$	SWITCH		
[Rectangular with Lines]	DIFFUSER		

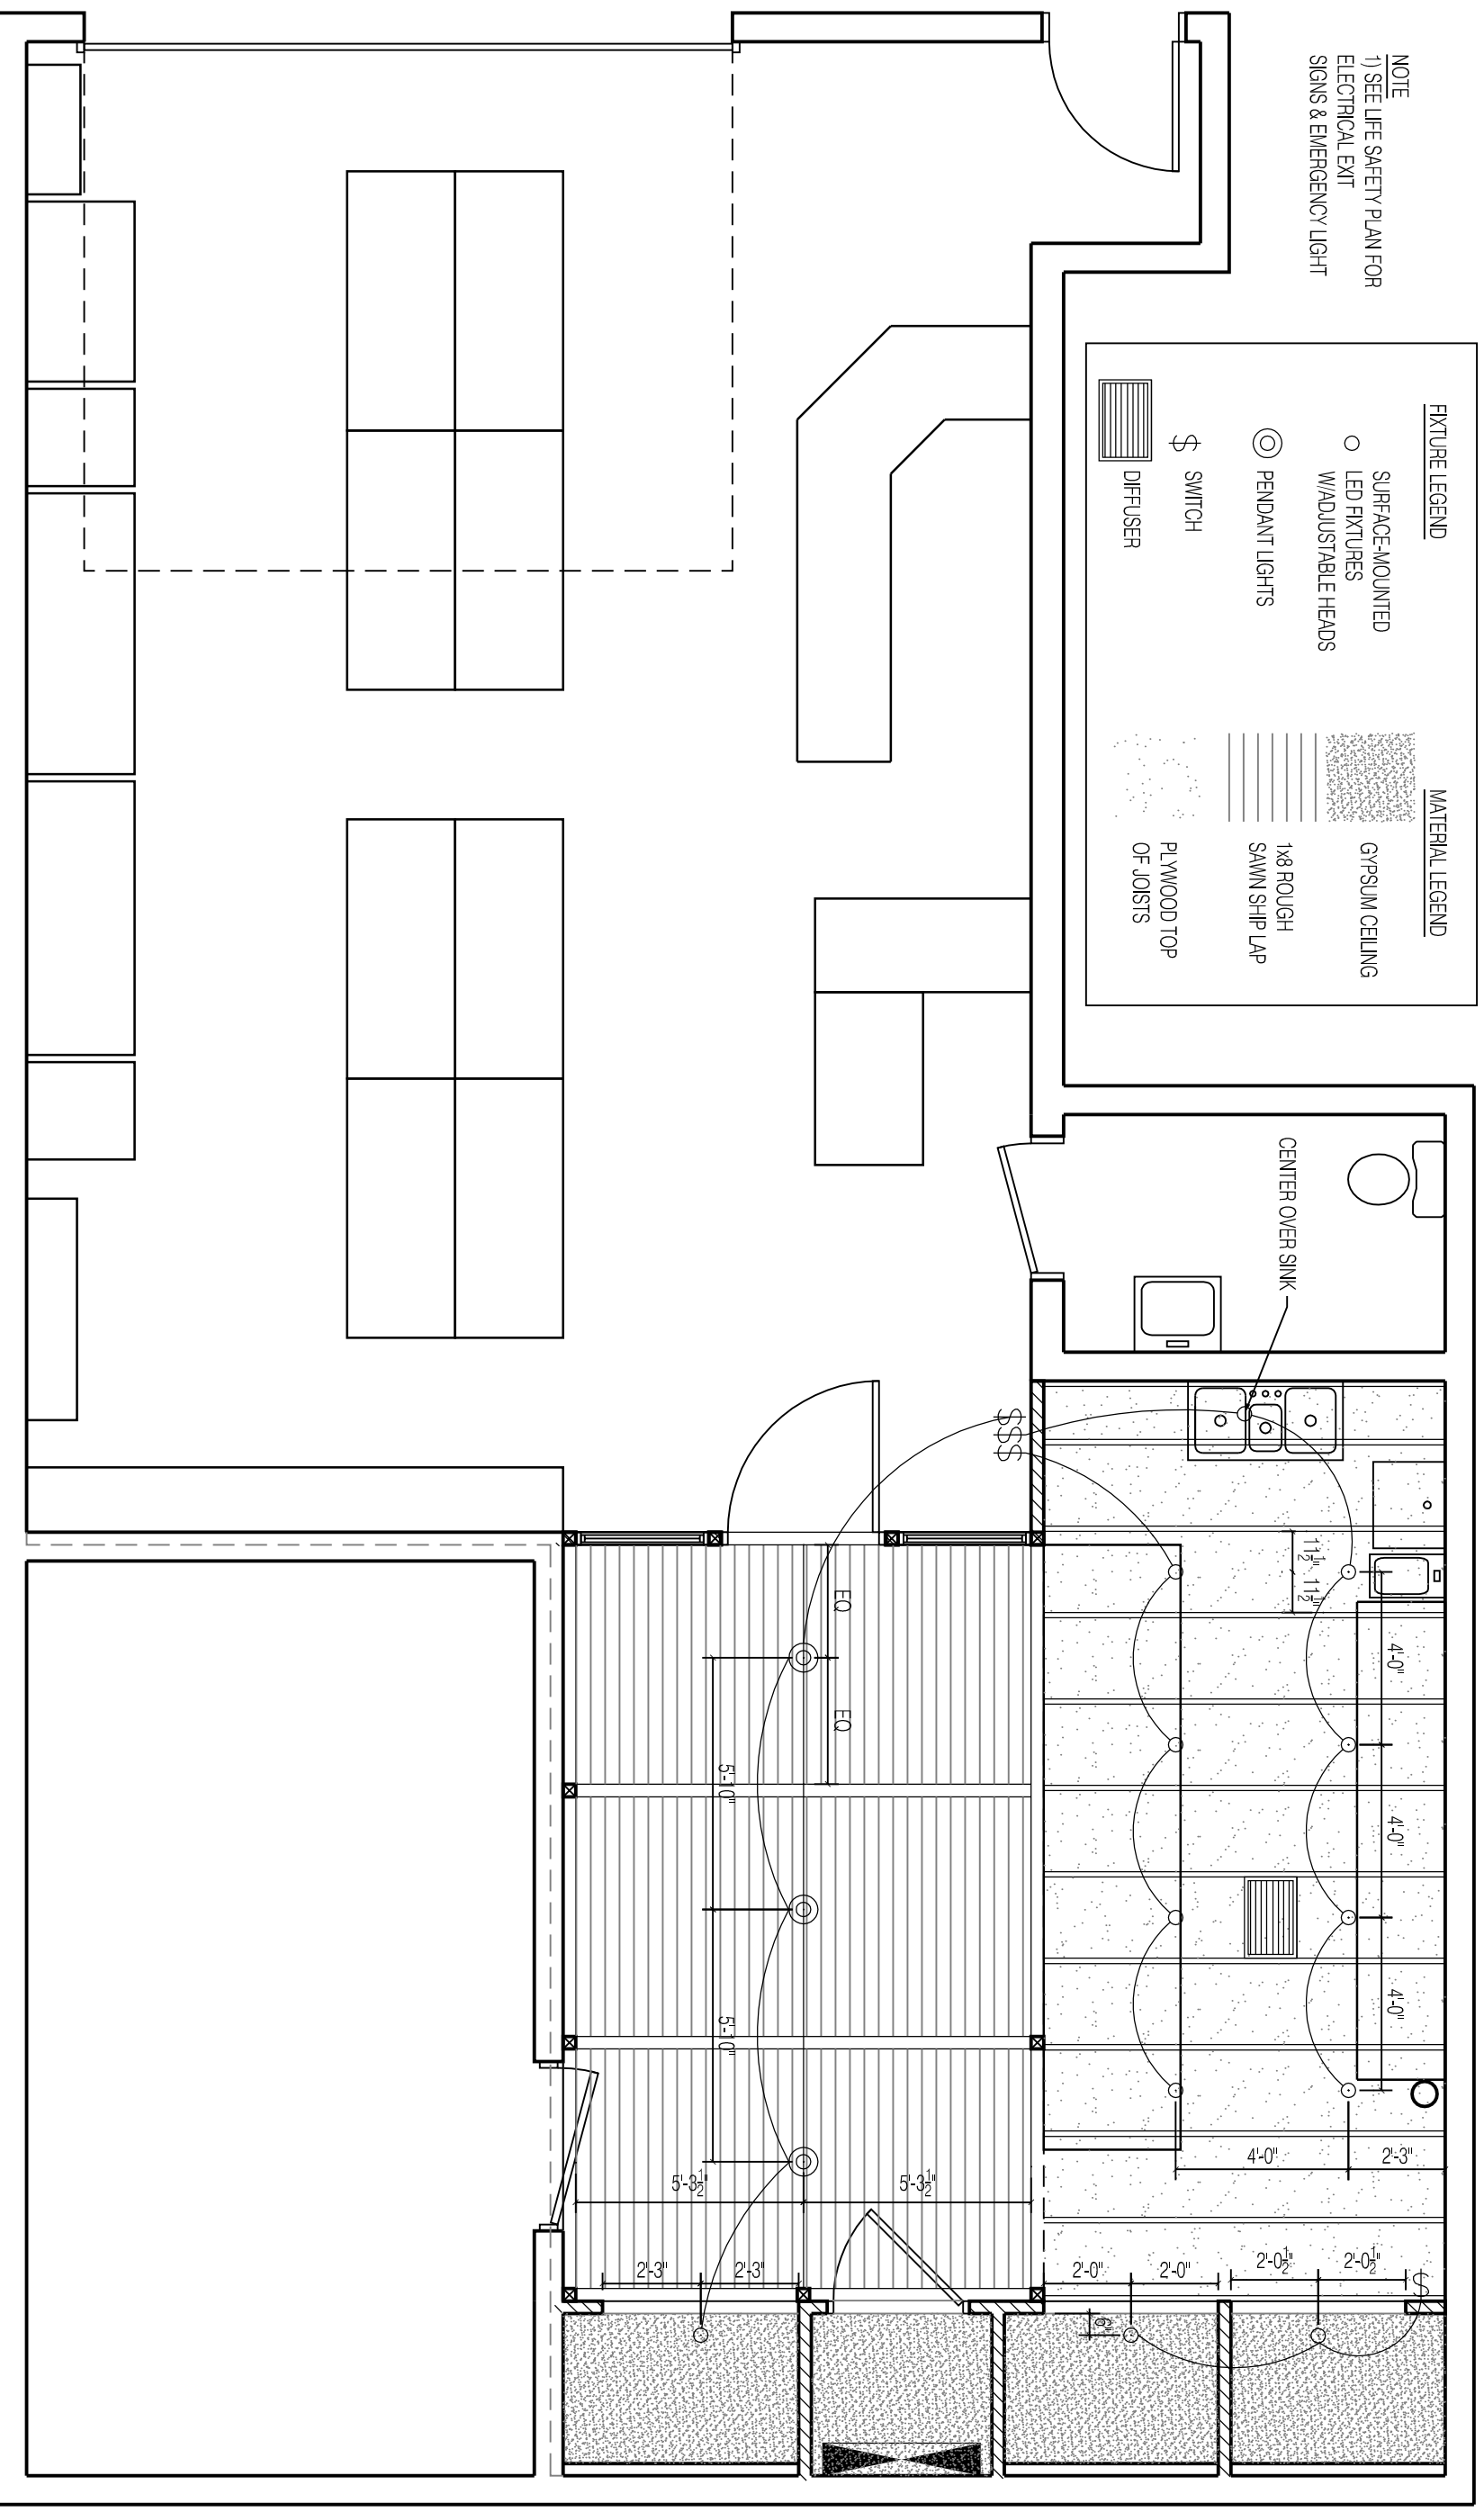

1 REFLECTED CEILING & ELECTRIC PLAN  
1/4" = 1'-0"



REFLECTED CEILING PLAN  
ROSEMONT MARKET | 5 COMMERCIAL STREET (SPACE B)

DATE:	5.15.2014
DRAWN BY:	JPH
	-
	A-1.3

