


SYMBOLS & LINE TYPES		
⊕	WALL CLEANOUT	SANITARY / WASTE PIPING ABOVE SLAB
⊙	ROOF DRAIN	SANITARY / WASTE PIPING BELOW SLAB
⊙	VENT THROUGH ROOF	INDIRECT WASTE PIPING ABOVE SLAB
⊙	WATER METER	VENT PIPING ABOVE SLAB
XX-1	PLUMBING FIXTURE / EQUIPMENT NUMBER TAG	STORM (ROOF DRAIN) PIPING BELOW SLAB
		STORM (ROOF DRAIN) PIPING ABOVE SLAB
		COLD WATER PIPING
		COLD WATER PIPING BELOW SLAB
		GAS PIPING


DRAIN SPEC. SCHEDULE				
TAG	ITEM	WASTE	VENT	REMARKS
RD-1	MAIN ROOF DRAIN	4"	-	PRIMARY DRAINAGE
WCO-1	WALL CLEAN OUT	SIZE OF PIPE	-	
BWV-1	EXTENDABLE BACKWATER VALVE	SIZE OF PIPE	-	CLEAN CHECK OR EQUAL

WATER SPEC. SCHEDULE					
TAG	ITEM	CW	HW	OUTLET	REMARKS
BFP-1	TENANT #1 WATER ENTRANCE BACKFLOW PREVENTER	1/2"	-	SAME	RPZ TYPE, 1/2" IDW
BFP-2	TENANT #2 WATER ENTRANCE BACKFLOW PREVENTER	1"	-	SAME	RPZ TYPE, 1" IDW


PUMP SCHEDULE							
TAG	ITEM	SERVICE	GPM	HEAD	HP	VOLTS	REMARKS
SP-1	ELEVATOR SUMP PUMP	ELEVATOR SHAFT	50	10'	1/2	115	OIL MINDER ELEC. BY EC

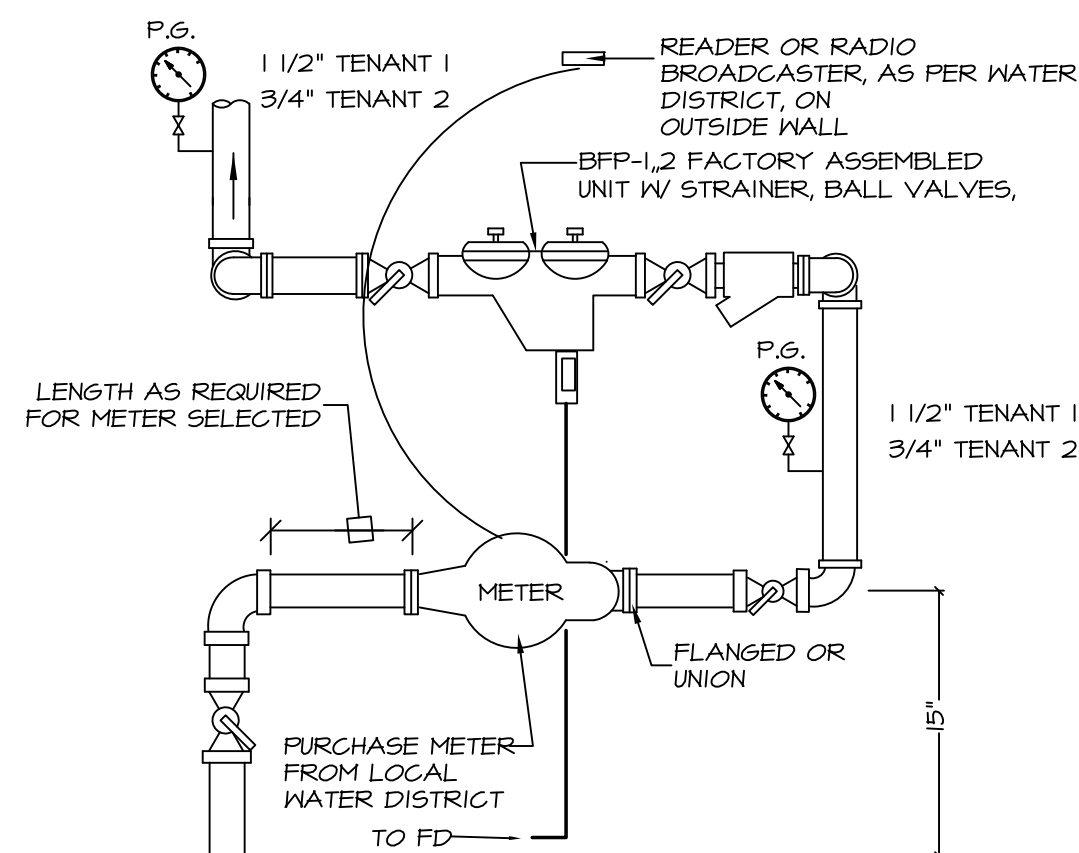


1 DOMESTIC WATER ENTRANCE TYPICAL TENANT #1 & #2
SCALE: NONE

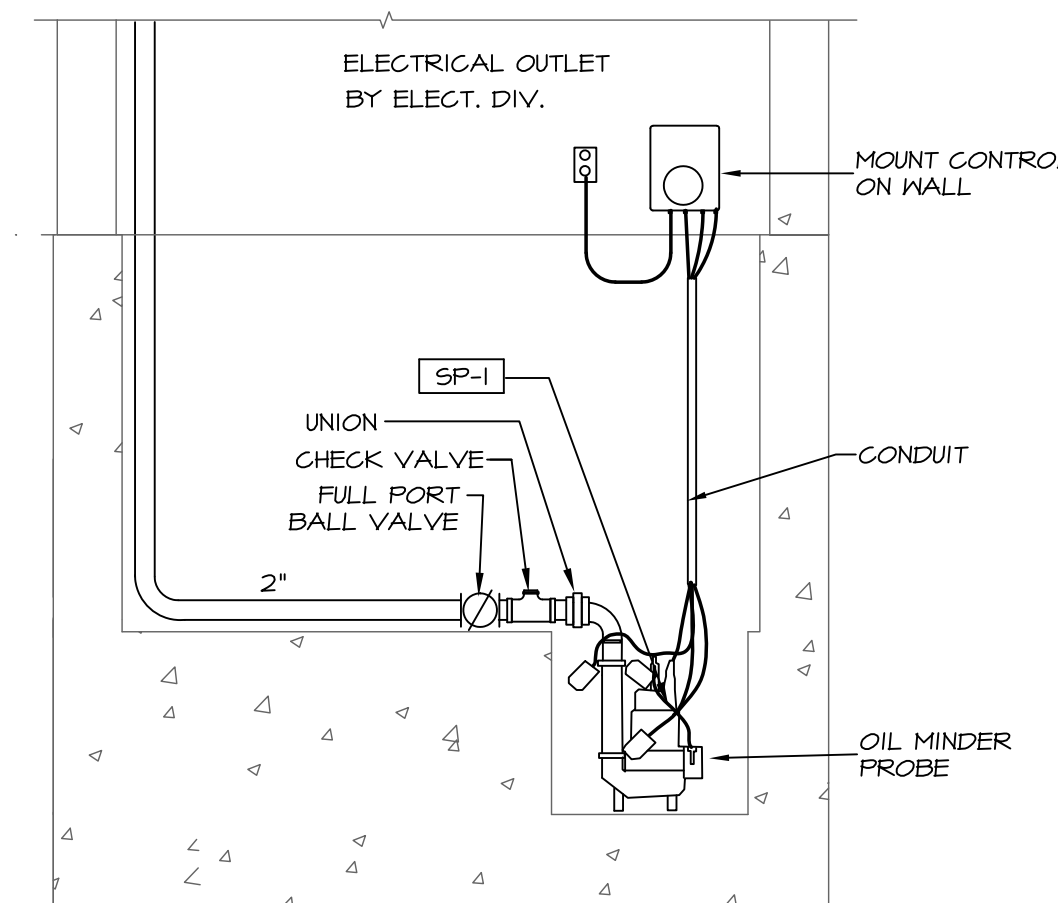

2 ELEVATOR SUMP PUMP DETAIL
SCALE: NONE

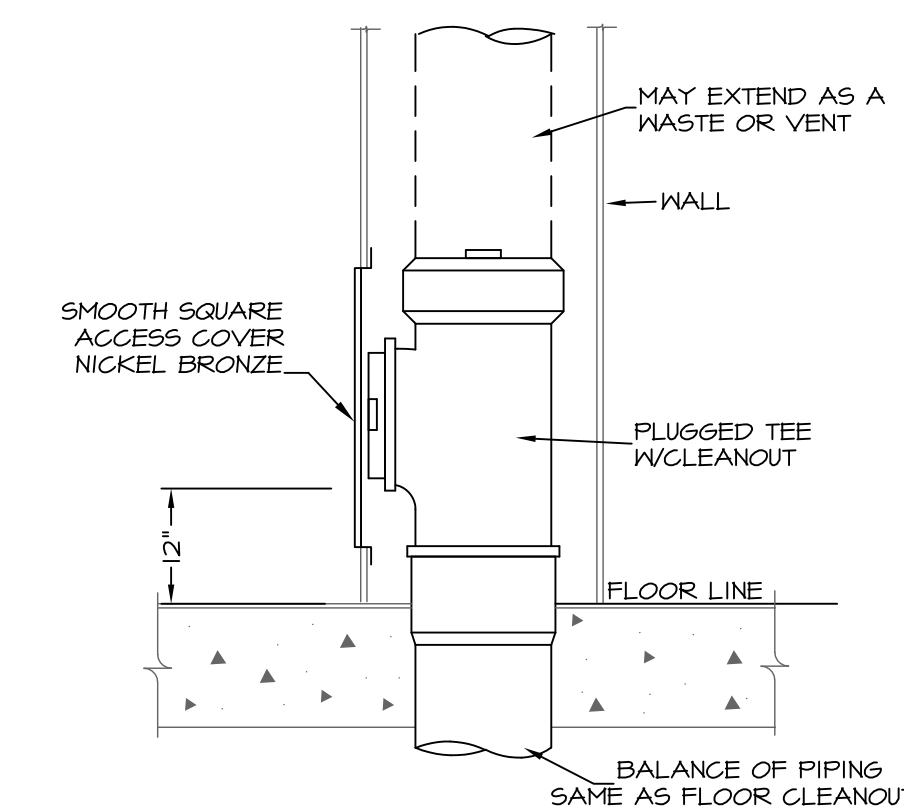

3 WALL CLEAN OUT DETAIL
SCALE: NONE

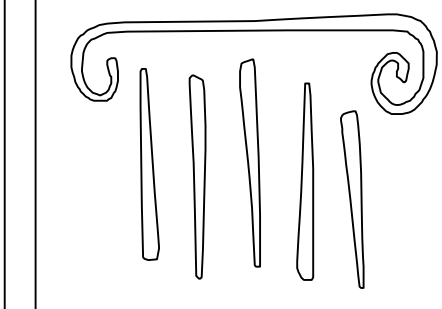

PORT CITY ARCHITECTURE

65 NEWBURY STREET
PORTLAND, ME 04101
207.761.9000
fax: 207.761.2010
info@portcityarch.com



CONSULTANTS

Swiftcurrent Engineering Services Inc.
10 Forest Fall Drive - unit 4B
Yarmouth, Maine 04096
(207) 847-9280
contact: Tim Matthews, P.E.
tim@swiftcurrenteng.com

Mechanical Systems Engineers
10 Forest Fall Drive - suite 10
Yarmouth, Maine 04096
(207) 846-9441
contact: Kurt Magnusson, P.E.
kurt@mechanicalsystemseng.com

PERMIT SET
10-21-16

NOT FOR CONSTRUCTION

NEWPORT DEVELOPMENT ASSOCIATES

164 Middle St
Portland, Maine

#	DATE	DESCRIPTION

DATE ISSUED OCTOBER 21, 2016

PROJECT NUMBER 16207

DRAWING SCALE AS NOTED

SHEET NAME

SCHEDULES & DETAILS

DRAWN BY
KFM

CHECKED BY
KFM

P1.2