

LIGHTING SCHEDULE

TYPE	DESCRIPTION	MANUFACTURER	LAMPS	MOUNTING	NOTES
A	4' LED WRAP AROUND 120V	COLUMBIA LIGHTING	48W LED 3500K 4700 LUMENS	CEILING SURFACE	MODEL #: LAW4-35ML-EU
B	2' LED WRAPAROUND 120V	COLUMBIA LIGHTING	25W LED 3500K 2600 LUMENS	CEILING SURFACE	MODEL #: LAW2-35LW-EU
C	VAPOR-TIGHT ELEVATOR PIT FIXTURE 120V	HUBBELL LIGHTING	11W LED 4100K 757 LUMENS	WALL SURFACE	MODEL #: VWGL-1
D	4" LED RECESSED DOWNLIGHT 120V	COOPER LIGHTING	22.4W LED 3500K 1300 LUMENS	CEILING RECESSED	MODEL #: LD4A-13-D010TE-ERM4A-13-835-4LM1-H-WF
D2	4" LED RECESSED DOWNLIGHT WITH EMERGENCY MODULE AND REMOTE TEST SWITCH. 120V	COOPER LIGHTING	22.4W LED 3500K 1300 LUMENS	CEILING RECESSED	MODEL #: LD4A-13-D010TE-EMBOD-ERM4A-13-835-4LM1-H-WF
E	LED SIGN LIGHT. WITH WIDE BEAM AND 24" STEM LENGTH. 120V	COOPER LIGHTING	10W LED 3000K 245 LUMENS	WALL MOUNTED	MODEL #: 922-10LED3041-12-BK-SA24 FURNISH REMOTE 12V TRANSFORMER
F	LED WALL PACK. BRONZE FINISH. 120V	LUMARK LIGHTING	18W LED 3500K 1633 LUMENS	WALL SURFACE	MODEL #: XTOR2A
C	CEILING MOUNTED DUAL TECHNOLOGY ULTRASONIC AND PASSIVE INFRARED OCCUPANCY SENSOR 120V	HUBBELL	N/A	CEILING SURFACE	MODEL #: OMNIDT500 FURNISH RELAYS/POWER PACKS AS REQUIRED FOR A COMPLETE AND OPERABLE INSTALLATION
W	WALL MOUNT PASSIVE INFRARED OCCUPANCY SENSOR 120V	HUBBELL	N/A	WALL	MODEL #: LHIRS11
	EMERGENCY BATTERY UNIT 120V	DUAL-LITE	2W LED	WALL SURFACE	MODEL #: EV4D-02L
WP	WEATHER PROOF REMOTE HEAD. WHITE FINISH. 120V	DUAL-LITE	(2) 1W LED	WALL SURFACE	MODEL #: EVO-D-W
	LED EXIT SIGN EMERGENCY BATTERY UNIT COMBINATION WITH REMOTE CAPACITY 120V	DUAL-LITE	(2) 1W LED	CEILING SURFACE	MODEL #: EVCU-R-W-D4
	LED EXIT SIGN EMERGENCY BATTERY UNIT 120V	DUAL-LITE	2W LED	CEILING SURFACE	MODEL #: EVEU-R-W


1 LIGHTING SCHEDULE

NOTES:

1. SEE E0.0 FOR LEGEND, ABBREVIATIONS AND GENERAL NOTES.

KEYED NOTES:

① CONTRACTOR TO FURNISH AES WIRELES TRANSMITTER MODEL 7788, 12V/ 7AH STANDBY BATTERY, 1640 PLUG-IN TRANSFORMER. SENTROL TAMPER SWITCH TO ALLOW SERVICING WITHOUT SENDING SYSTEM INTO ALARM. SYSTEM COORDINATE WITH DICK ANDREWS, PORTLAND FIRE DEPARTMENT.

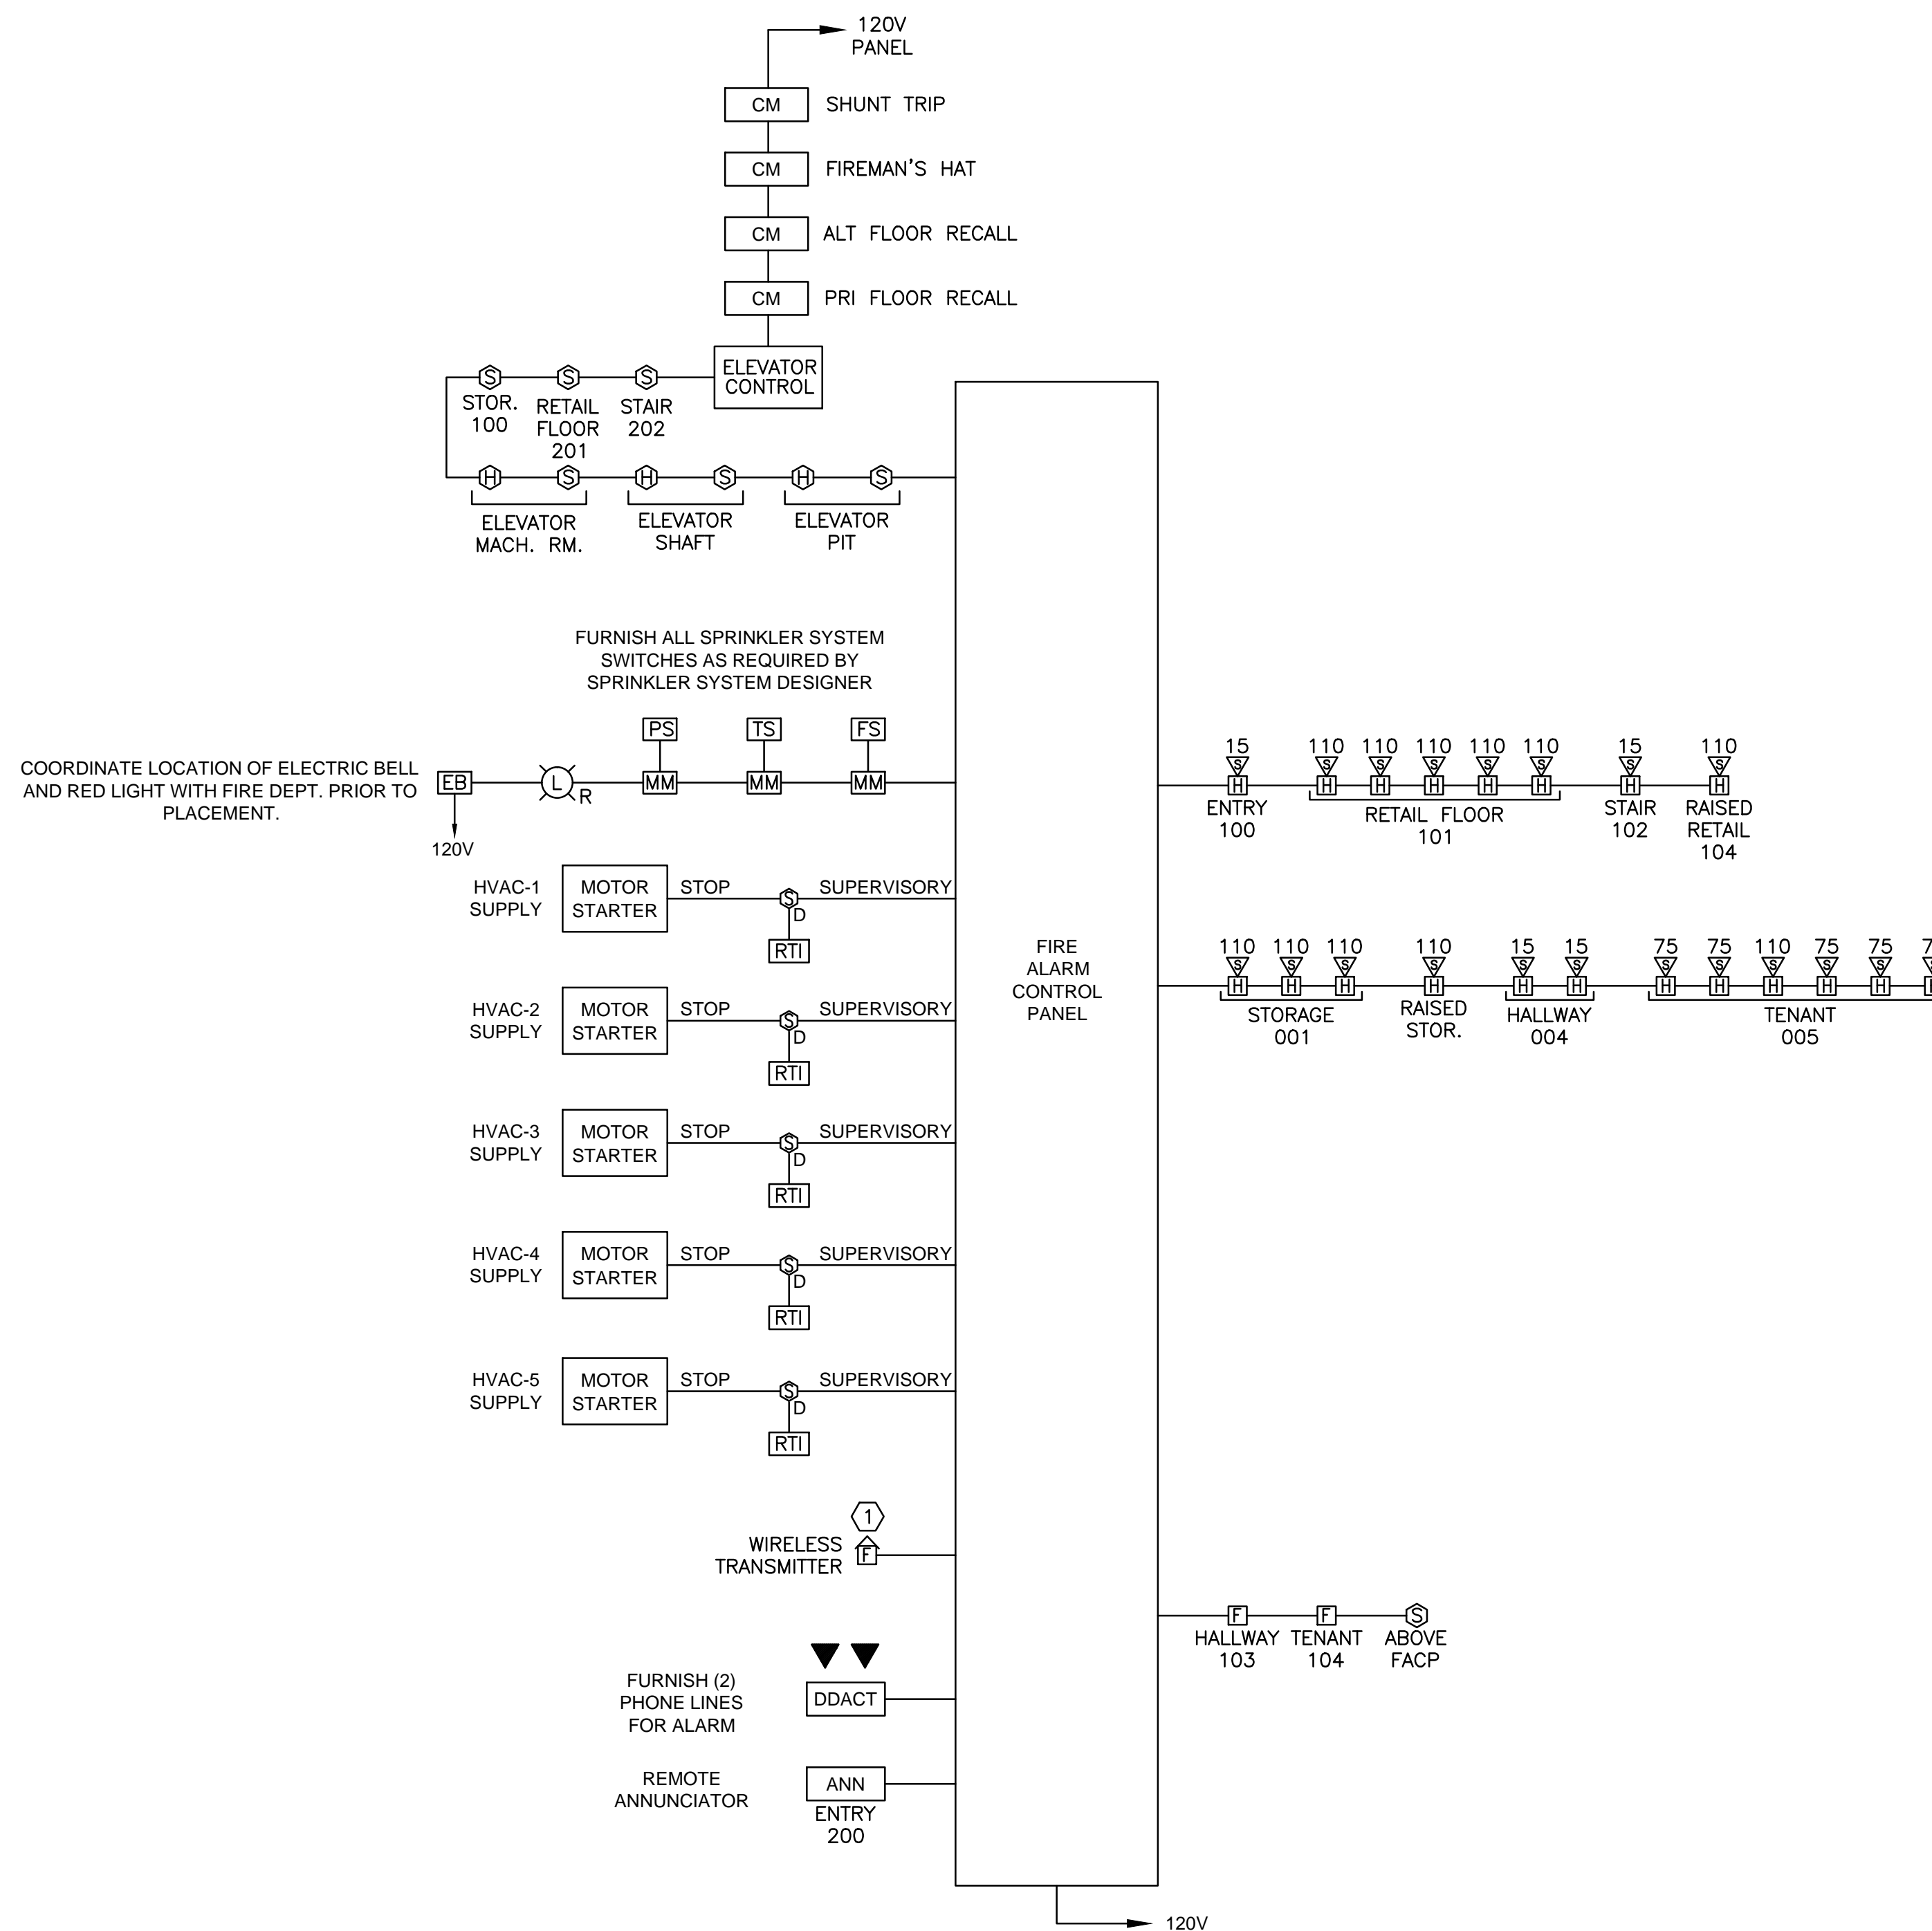


2 FIRE ALARM RISER DIAGRAM



PORT CITY ARCHITECTURE

65 NEWBURY STREET
PORTLAND, ME 04101
207.761.9000

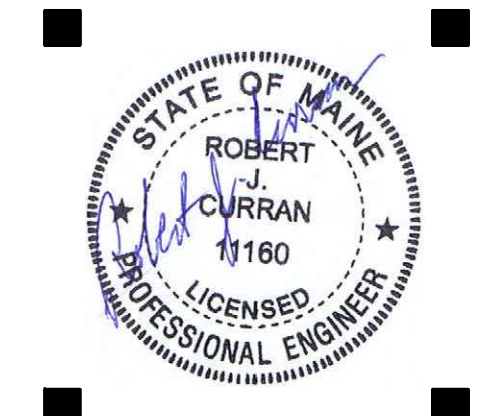

Consultants:

Swiftcurrent Engineering Services, Inc.
10 Forest Falls Dr. - Unit 48
Yarmouth, ME 04096
(207) 847-9280
contact: Timothy D. Matthews, P.E.
tim@swiftcurrenteng.com

PERMIT SET
11-1-16

NOT FOR CONSTRUCTION

NEWPORT DEVELOPMENT ASSOCIATES

164 Middle St
Portland, Maine

#	DATE	DESCRIPTION

Date Issued: October 26th, 2016
Project Number: 16202
Drawing Scale: AS NOTED

ELECTRICAL LIGHTING SCHEDULE & FIRE ALARM RISER DIAGRAM

Drawn By: JMD
Checked By: TDM

E1.5