


NOTES:
 1. SEE E0.0 FOR LEGEND, ABBREVIATIONS AND GENERAL NOTES.

KEYED NOTES:
 ① DEDICATED ELEVATOR PIT RECEPTACLE.
 ② ELEVATOR SUMP PUMP RECEPTACLE.
 ③ DEDICATED TEL/DATA RECEPTACLE.
 ④ COORDINATE QUANTITY AND LOCATION OF MONITOR MODULES WITH SPRINKLER SYSTEM DESIGNER. PROVIDE AS MANY AS NEEDED TO MONITOR ALL SPRINKLER SWITCHES.

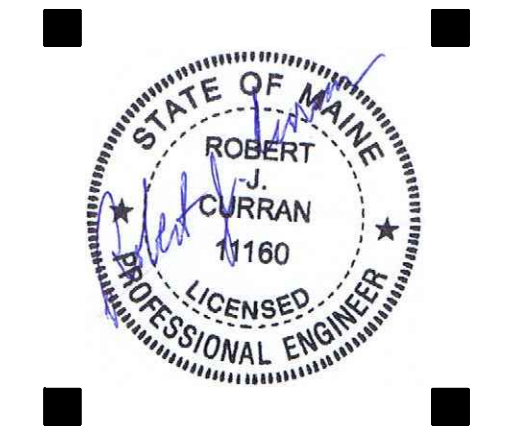

Consultants:
 Swiftcurrent Engineering Services, Inc.
 10 Forest Falls Dr. - Unit 4B
 Yarmouth, ME 04096
 (207) 847-9280
 contact Timothy D. Matthews, P.E.
 tim@swiftcurrenteng.com

PERMIT SET
 11-1-16

NOT FOR
 CONSTRUCTION

NEWPORT
 DEVELOPMENT
 ASSOCIATES


164 Middle St
 Portland, Maine

#	DATE	DESCRIPTION

Date issued October 26th, 2016
 Project Number 16202
 Drawing Scale AS NOTED

ELECTRICAL PLAN - FIRST FLOOR

Drawn By JMD
 Checked By TDM
E1.1

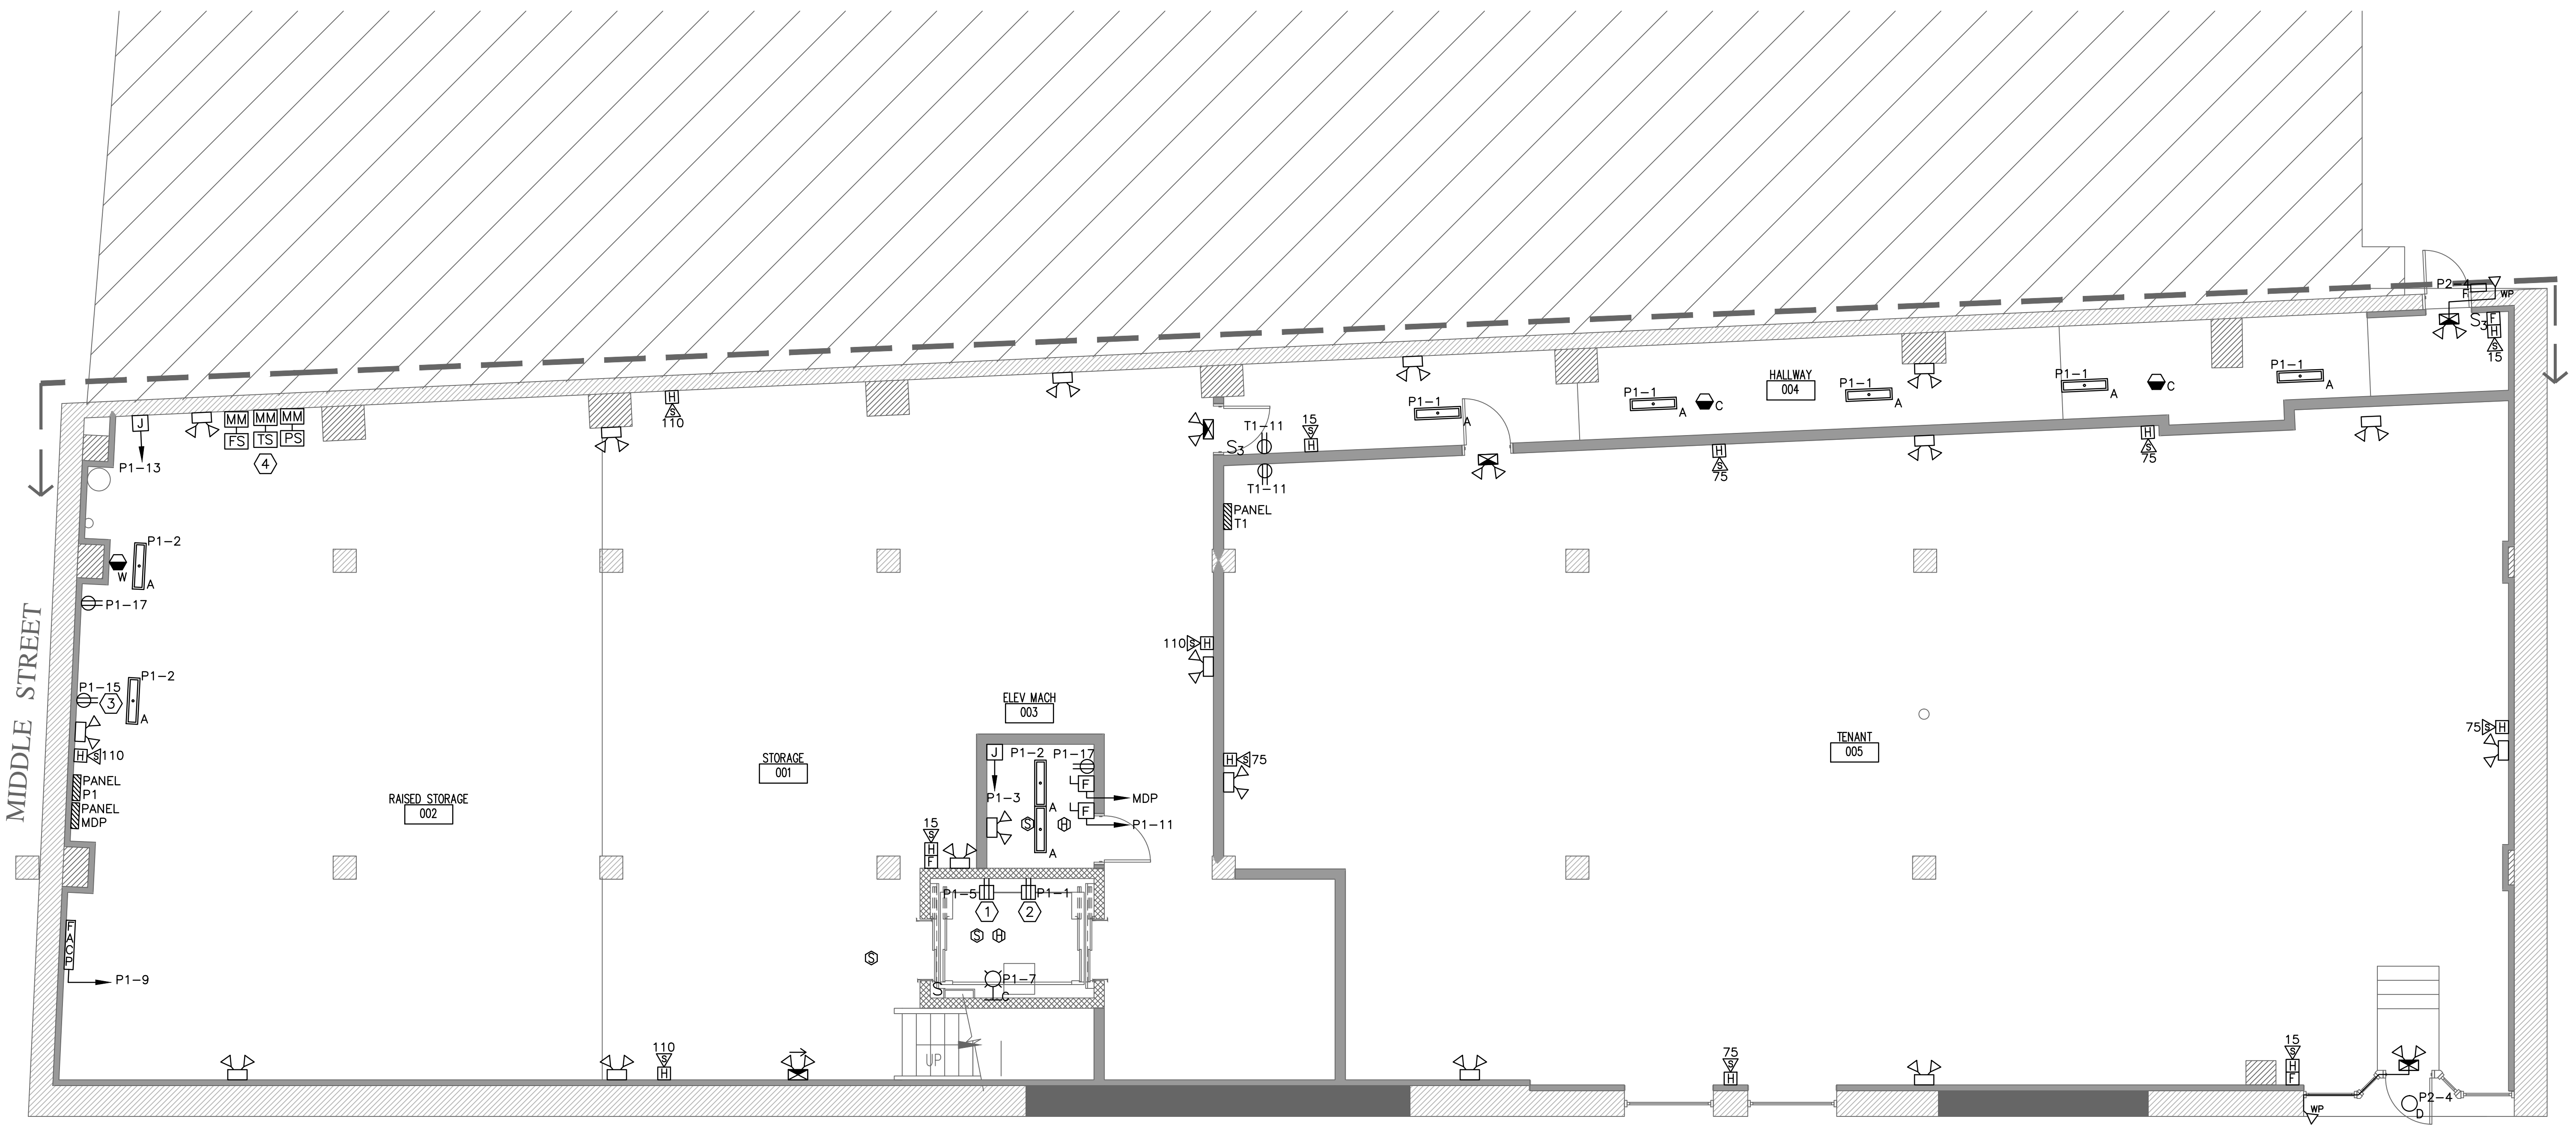

1 ELECTRICAL POWER & FIRE ALARM PLAN - LOWER LEVEL
 SCALE: 3/16"=1'-0"