 




1 2 3 4 5 6 7 8 9 10

F
E
D
C
B
A

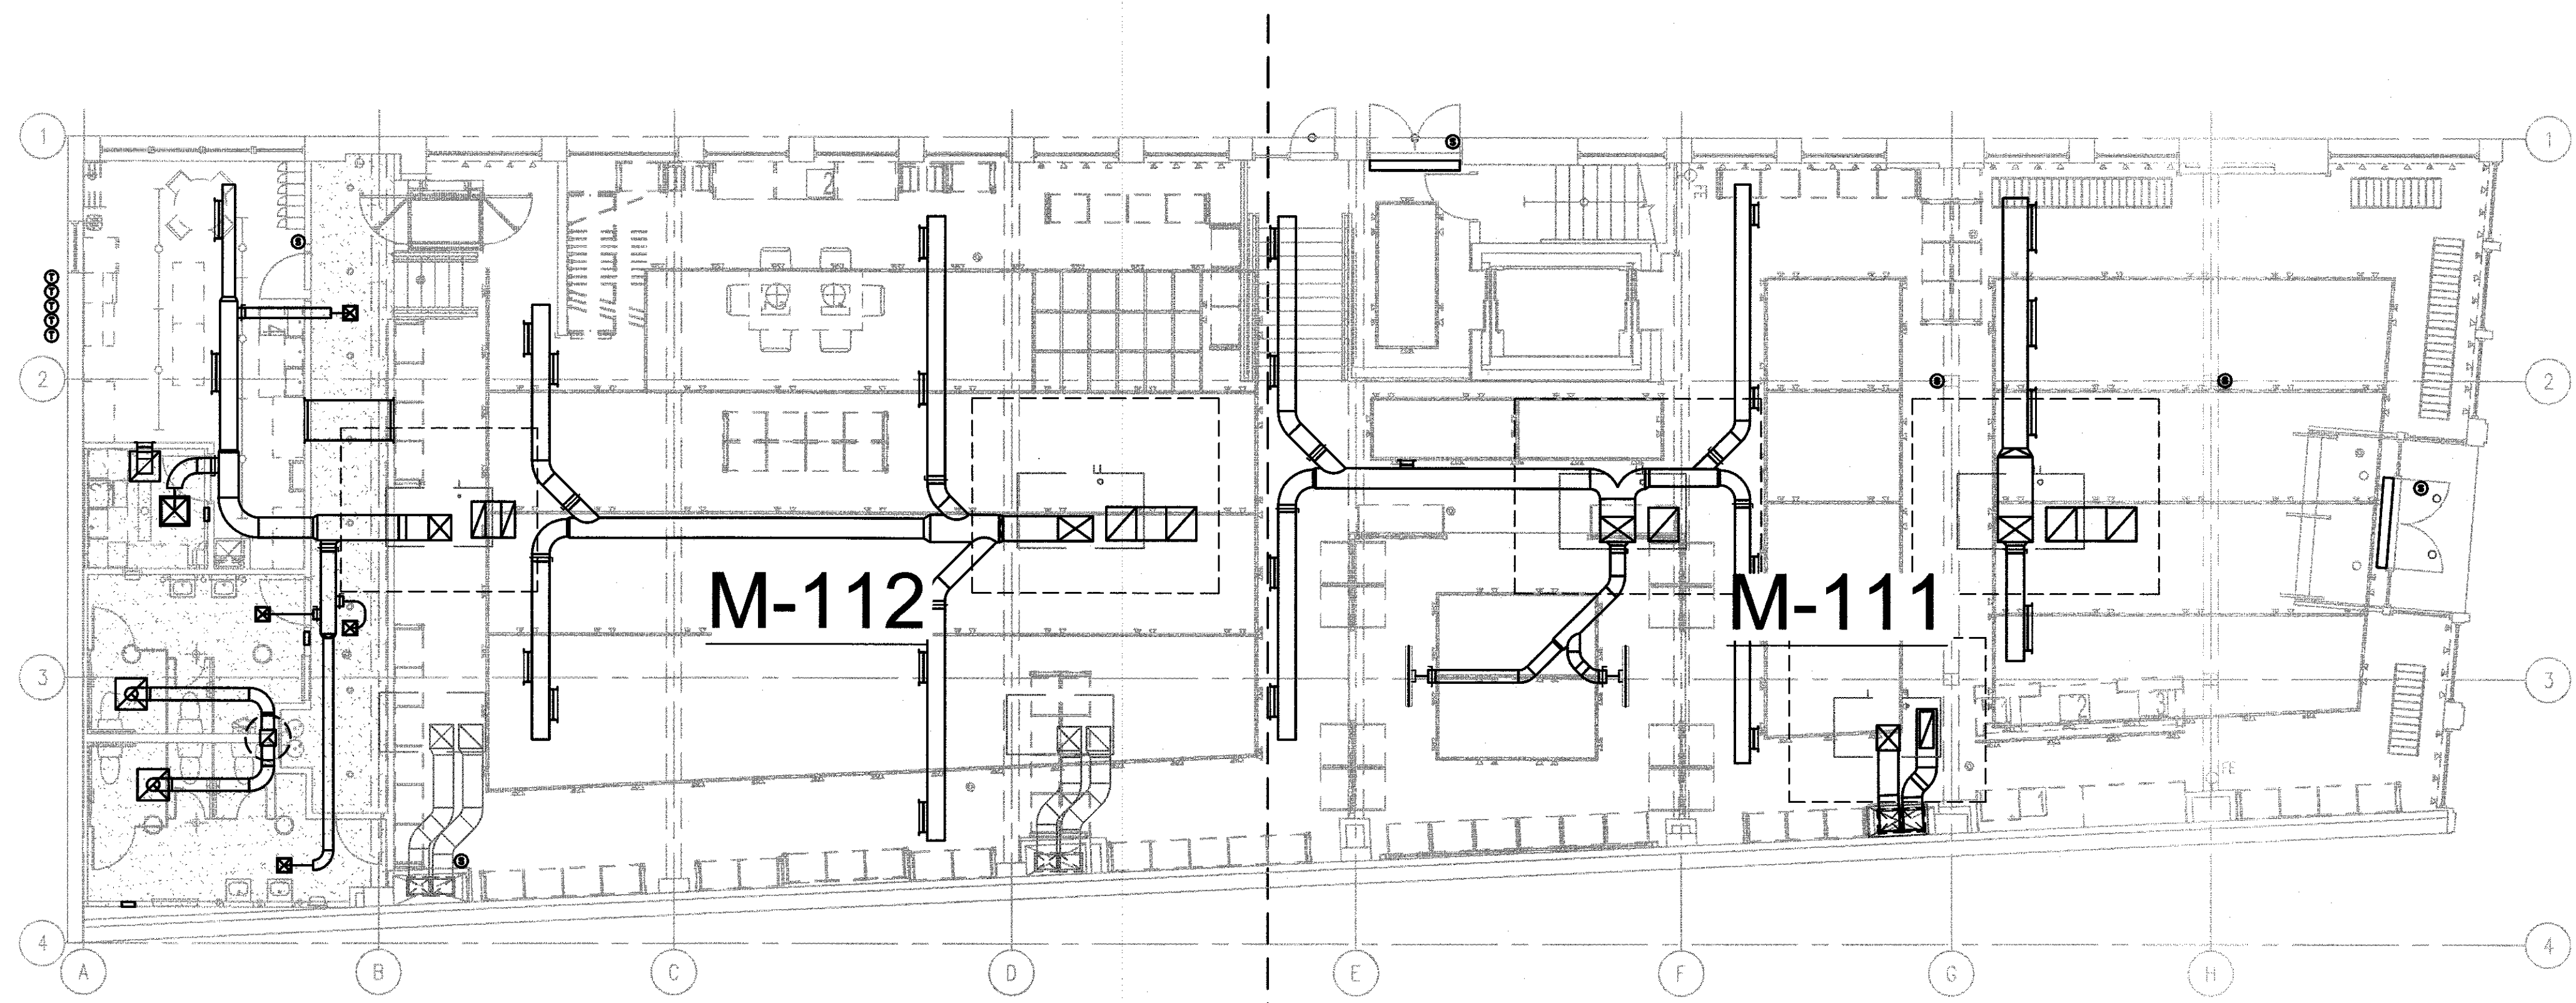

SCALE: 1/8" = 1'-0" @ FULL SIZE

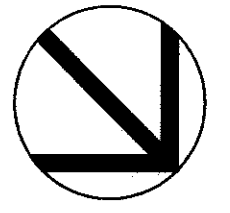

OVERALL HVAC PLAN


OWNER: **WILLIAMS-SONOMA, INC.**
 3250 Van Ness Avenue
 San Francisco, CA 94109
 T 415 616 8602
 F 415 439 8164
 www.williams-sonoma.com



EEA Consulting Engineers
 6615 Vaughn Ranch Road, Suite 200
 Austin, Texas 78729-2314 USA
 512.744.4400 main 512.744.4444 fax
 www.eeac.com

State of Registration: MAINE
 Firm Registration No. N/A
 EEA Project No. 20166538

DRAWN BY: ARC
 CHECKED BY: BKK

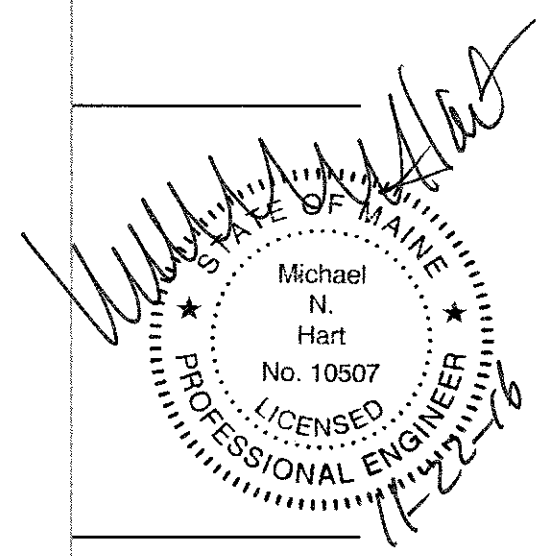

west elm
 Downtown Portland
 164 Middle Street
 Portland, ME 04101

PROJECT #006-160335.00

ISSUED / REVISED	DATE
PRELIMINARY SET	09/08/16
LL COORDINATION SET	11/08/16
LL/PERMIT SET	11/21/16

OVERALL HVAC PLAN

M-110