

1 2 3 4 5 6 7 8 9 10

F


E

D

C


B

A

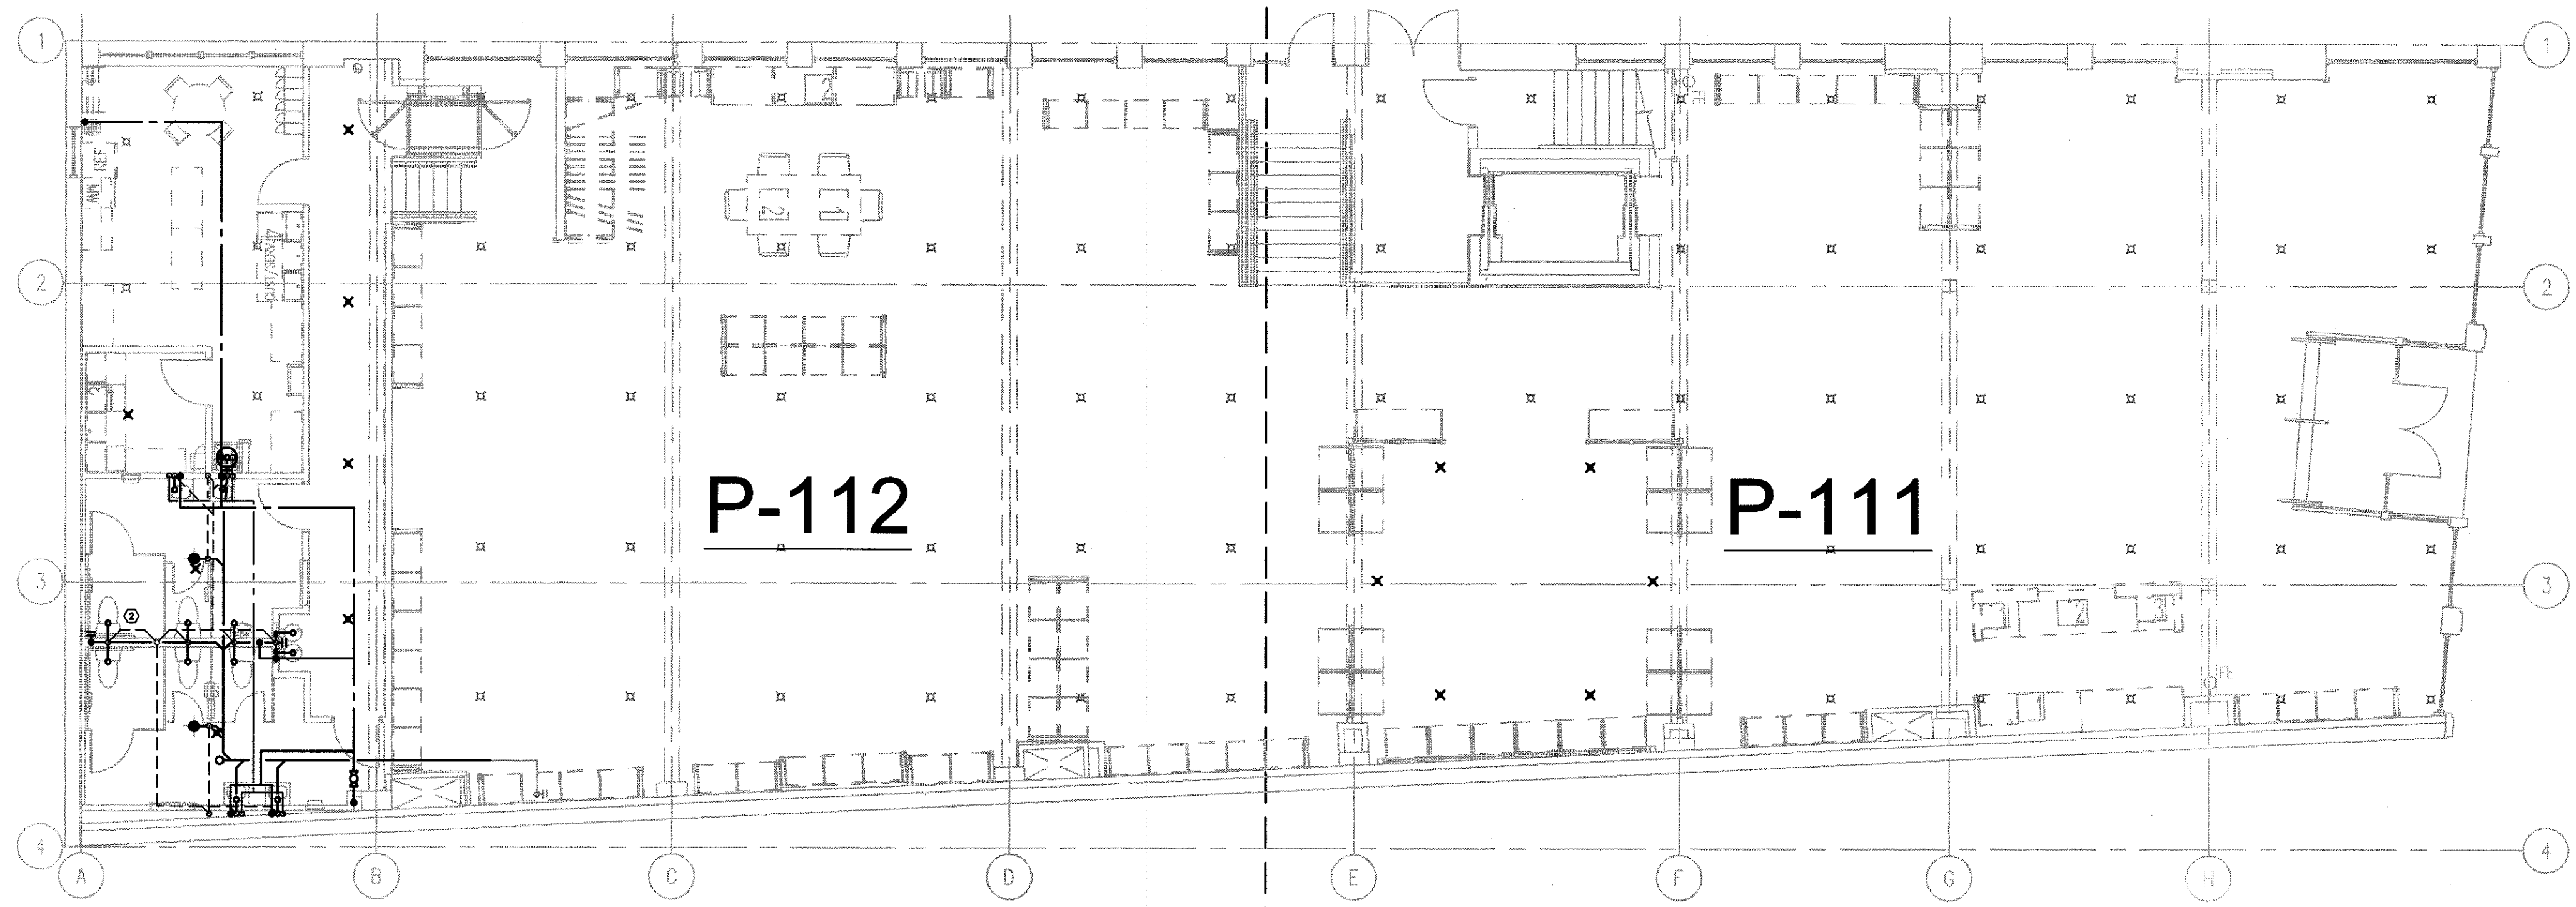


P-112

 P-111



SCALE: 1/8" = 1'-0" @ FULL SIZE

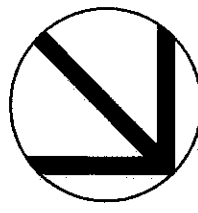


OWNER:  
**WILLIAMS-SONOMA, INC.**  
 3250 Van Ness Avenue  
 San Francisco, CA 94109  
 T 415 616 8602  
 F 415 439 8164  
 www.williams-sonoma.com



EEA Consulting Engineers  
 6615 Vaught Ranch Road, Suite 200  
 Austin, Texas 78726-2314 USA  
 512.744.4400 main 512.744.4444 fax  
 www.eeace.com

State of Registration MAINE  
 Firm Registration No. N/A  
 EEA Project No. 20166538

DRAWN BY: ARC  
 CHECKED BY: BKK

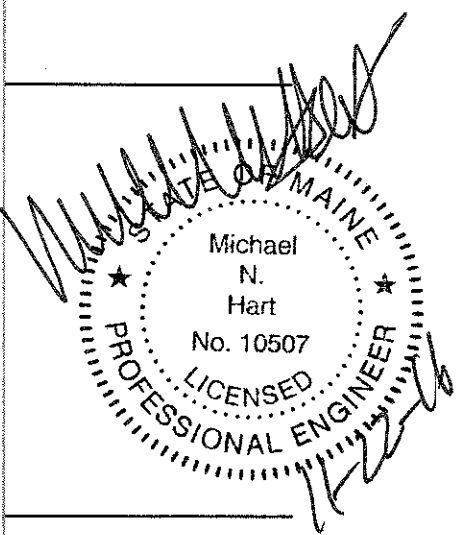

**west elm**

Downtown Portland  
 164 Middle Street  
 Portland, ME 04101

PROJECT #006-160335.00

ISSUED / REVISED	DATE
PRELIMINARY SET	09/08/16
LL COORDINATION SET	11/08/16
LL/PERMIT SET	11/21/16

OVERALL FIRST FLOOR PLUMBING PLAN

**P-110**