

F

 

E

D


C

B

A

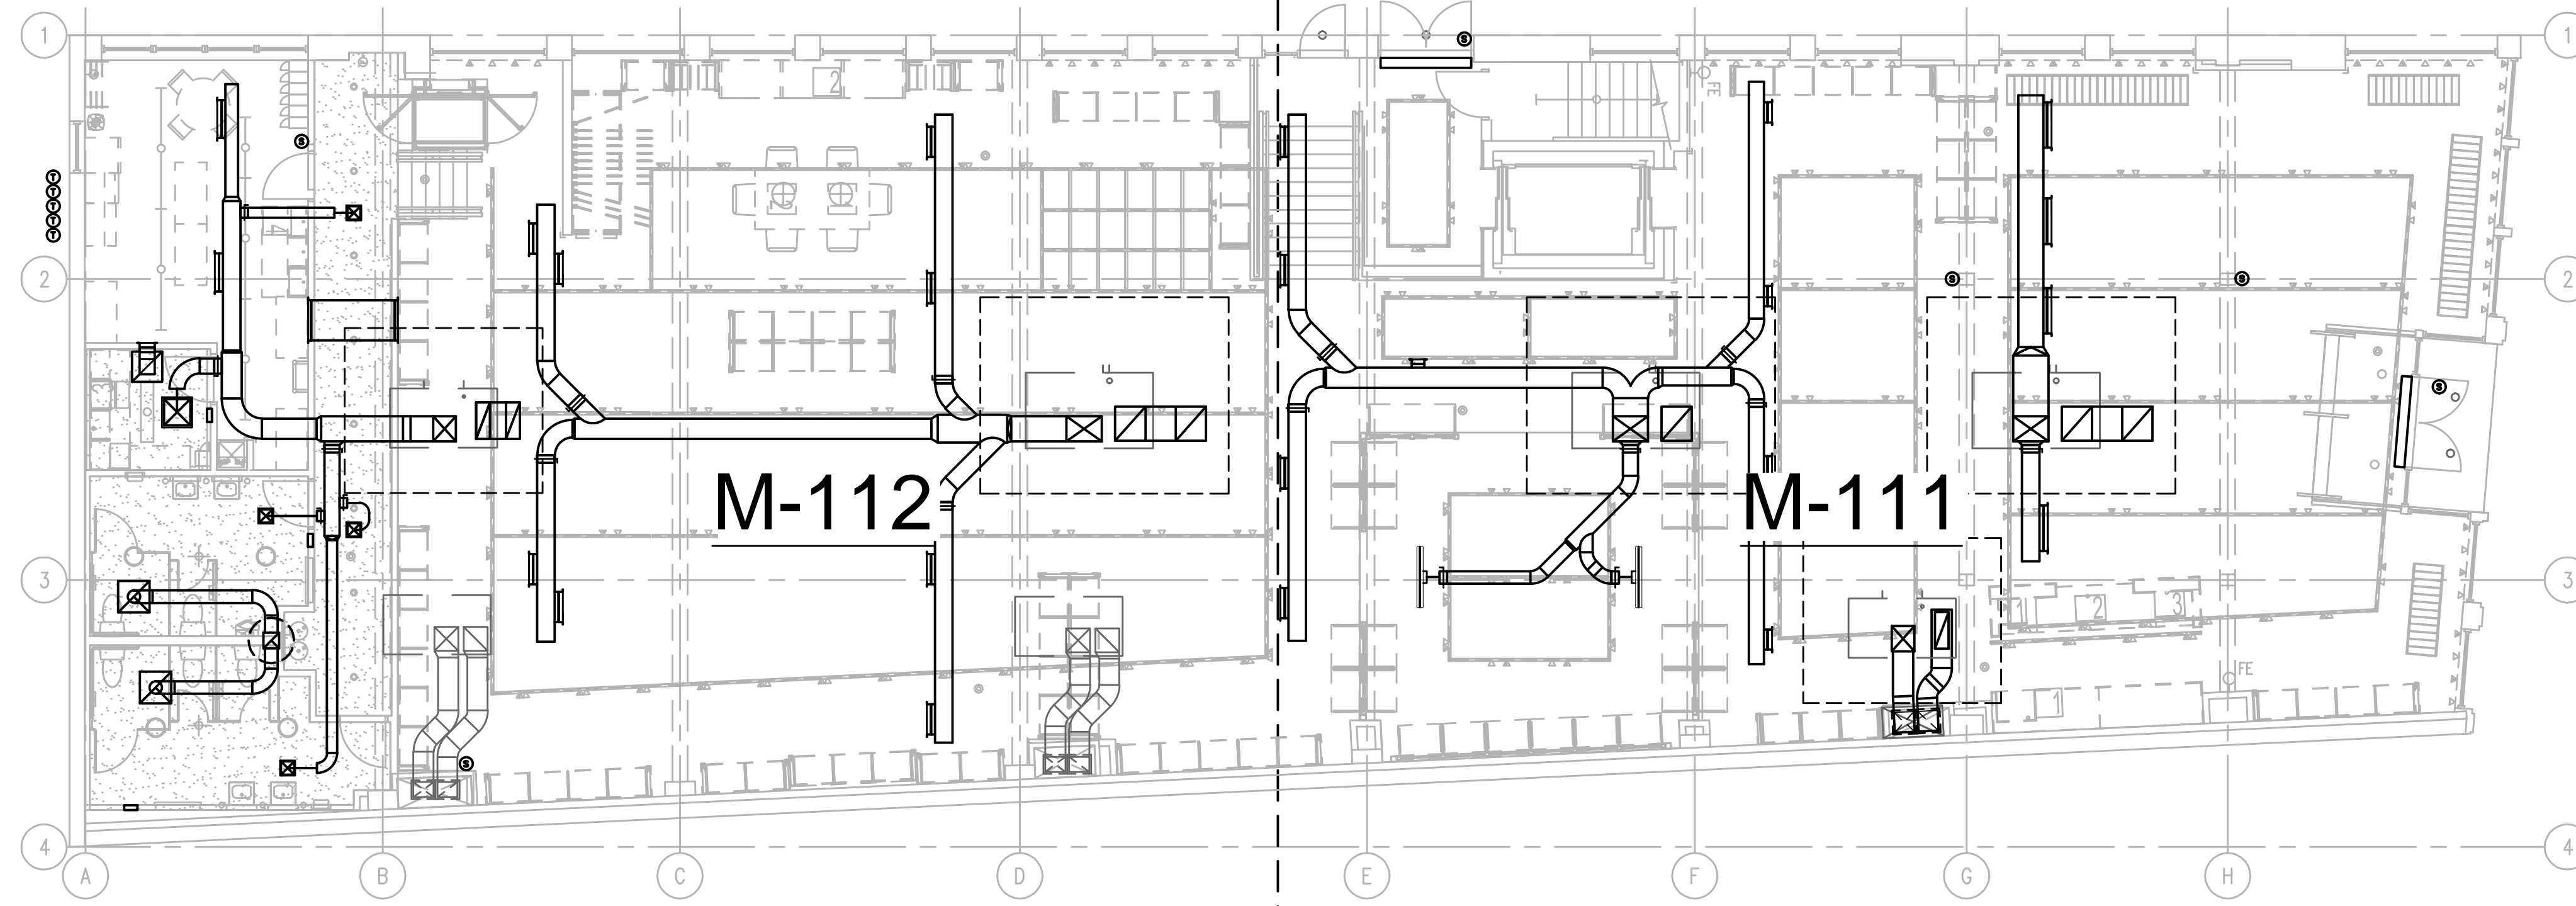

SCALE: 1/8" = 1'-0" @ FULL SIZE

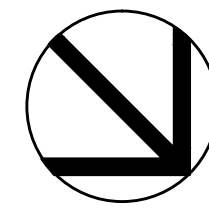

OVERALL HVAC PLAN



EEA Consulting Engineers  
6615 Yaught Ranch Road, Suite 200  
Austin, Texas 78730-2314 USA  
512.744.4400 main 512.744.4444 fax  
www.eeac.com

State of Registration: MAINE  
Firm Registration No: N/A  
EEA Project No: 20166538

DRAWN BY: ARC  
CHECKED BY: BKK

OWNER:  
**WILLIAMS-SONOMA, INC.**  
3250 Van Ness Avenue  
San Francisco, CA 94109  
T 415 616 8602  
F 415 439 8164  
www.williams-sonomainc.com

**west elm**  
Downtown Portland  
164 Middle Street  
Portland, ME 04101  
PROJECT #006-160335-00

ISSUED / REVISED	DATE
PRELIMINARY SET	09/08/16
LL COORDINATION SET	11/08/16
LL/PERMIT SET	11/21/16

OVERALL HVAC PLAN

**M-110**