



©2011 STARBUCKS COFFEE COMPANY

STARBUCKS COFFEE COMPANY
2401 UTAH AVENUE SOUTH
SEATTLE, WASHINGTON 98134
(206) 318-1575

THESE DRAWINGS AND SPECIFICATIONS ARE CONFIDENTIAL AND SHALL REMAIN THE SOLE PROPERTY OF STARBUCKS CORPORATION, WHICH IS THE OWNER OF THE COPYRIGHT IN THIS WORK. THEY SHALL NOT BE REPRODUCED (IN WHOLE OR IN PART), SHARED WITH THIRD PARTIES OR USED IN ANY MANNER ON OTHER PROJECTS OR EXTENSIONS TO THIS PROJECT WITHOUT THE PRIOR WRITTEN CONSENT OF STARBUCKS CORPORATION. THESE DRAWINGS AND SPECIFICATIONS ARE INTENDED TO EXPRESS DESIGN INTENT FOR A PROTOTYPICAL STARBUCKS STORE (WHICH IS SUBJECT TO CHANGE AT ANYTIME) AND DO NOT REFLECT ACTUAL SITE CONDITIONS. NEITHER PARTY SHALL HAVE ANY OBLIGATION NOR LIABILITY TO THE OTHER (EXCEPT STATED ABOVE) UNTIL A WRITTEN AGREEMENT IS FULLY EXECUTED BY BOTH PARTIES.

ARCHITECT OF RECORD



NORR

ARCHITECTS PLANNERS
328 N. LaSalle St. Suite 700 Chicago, IL 60654
312.424.2400 | 312.424.2424 | www.norr.com



353 Marshall Avenue
St. Louis, Missouri 63119
Phone (314) 772-1782
Fax (314) 573-3514

Engineering Consultants
Mechanical - Electrical - Plumbing

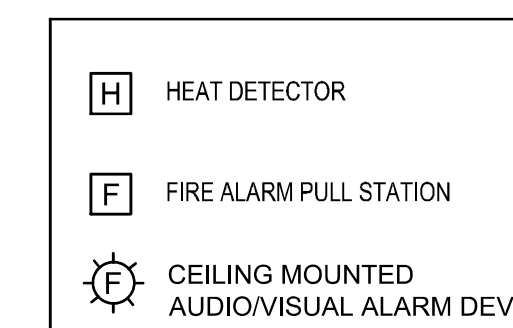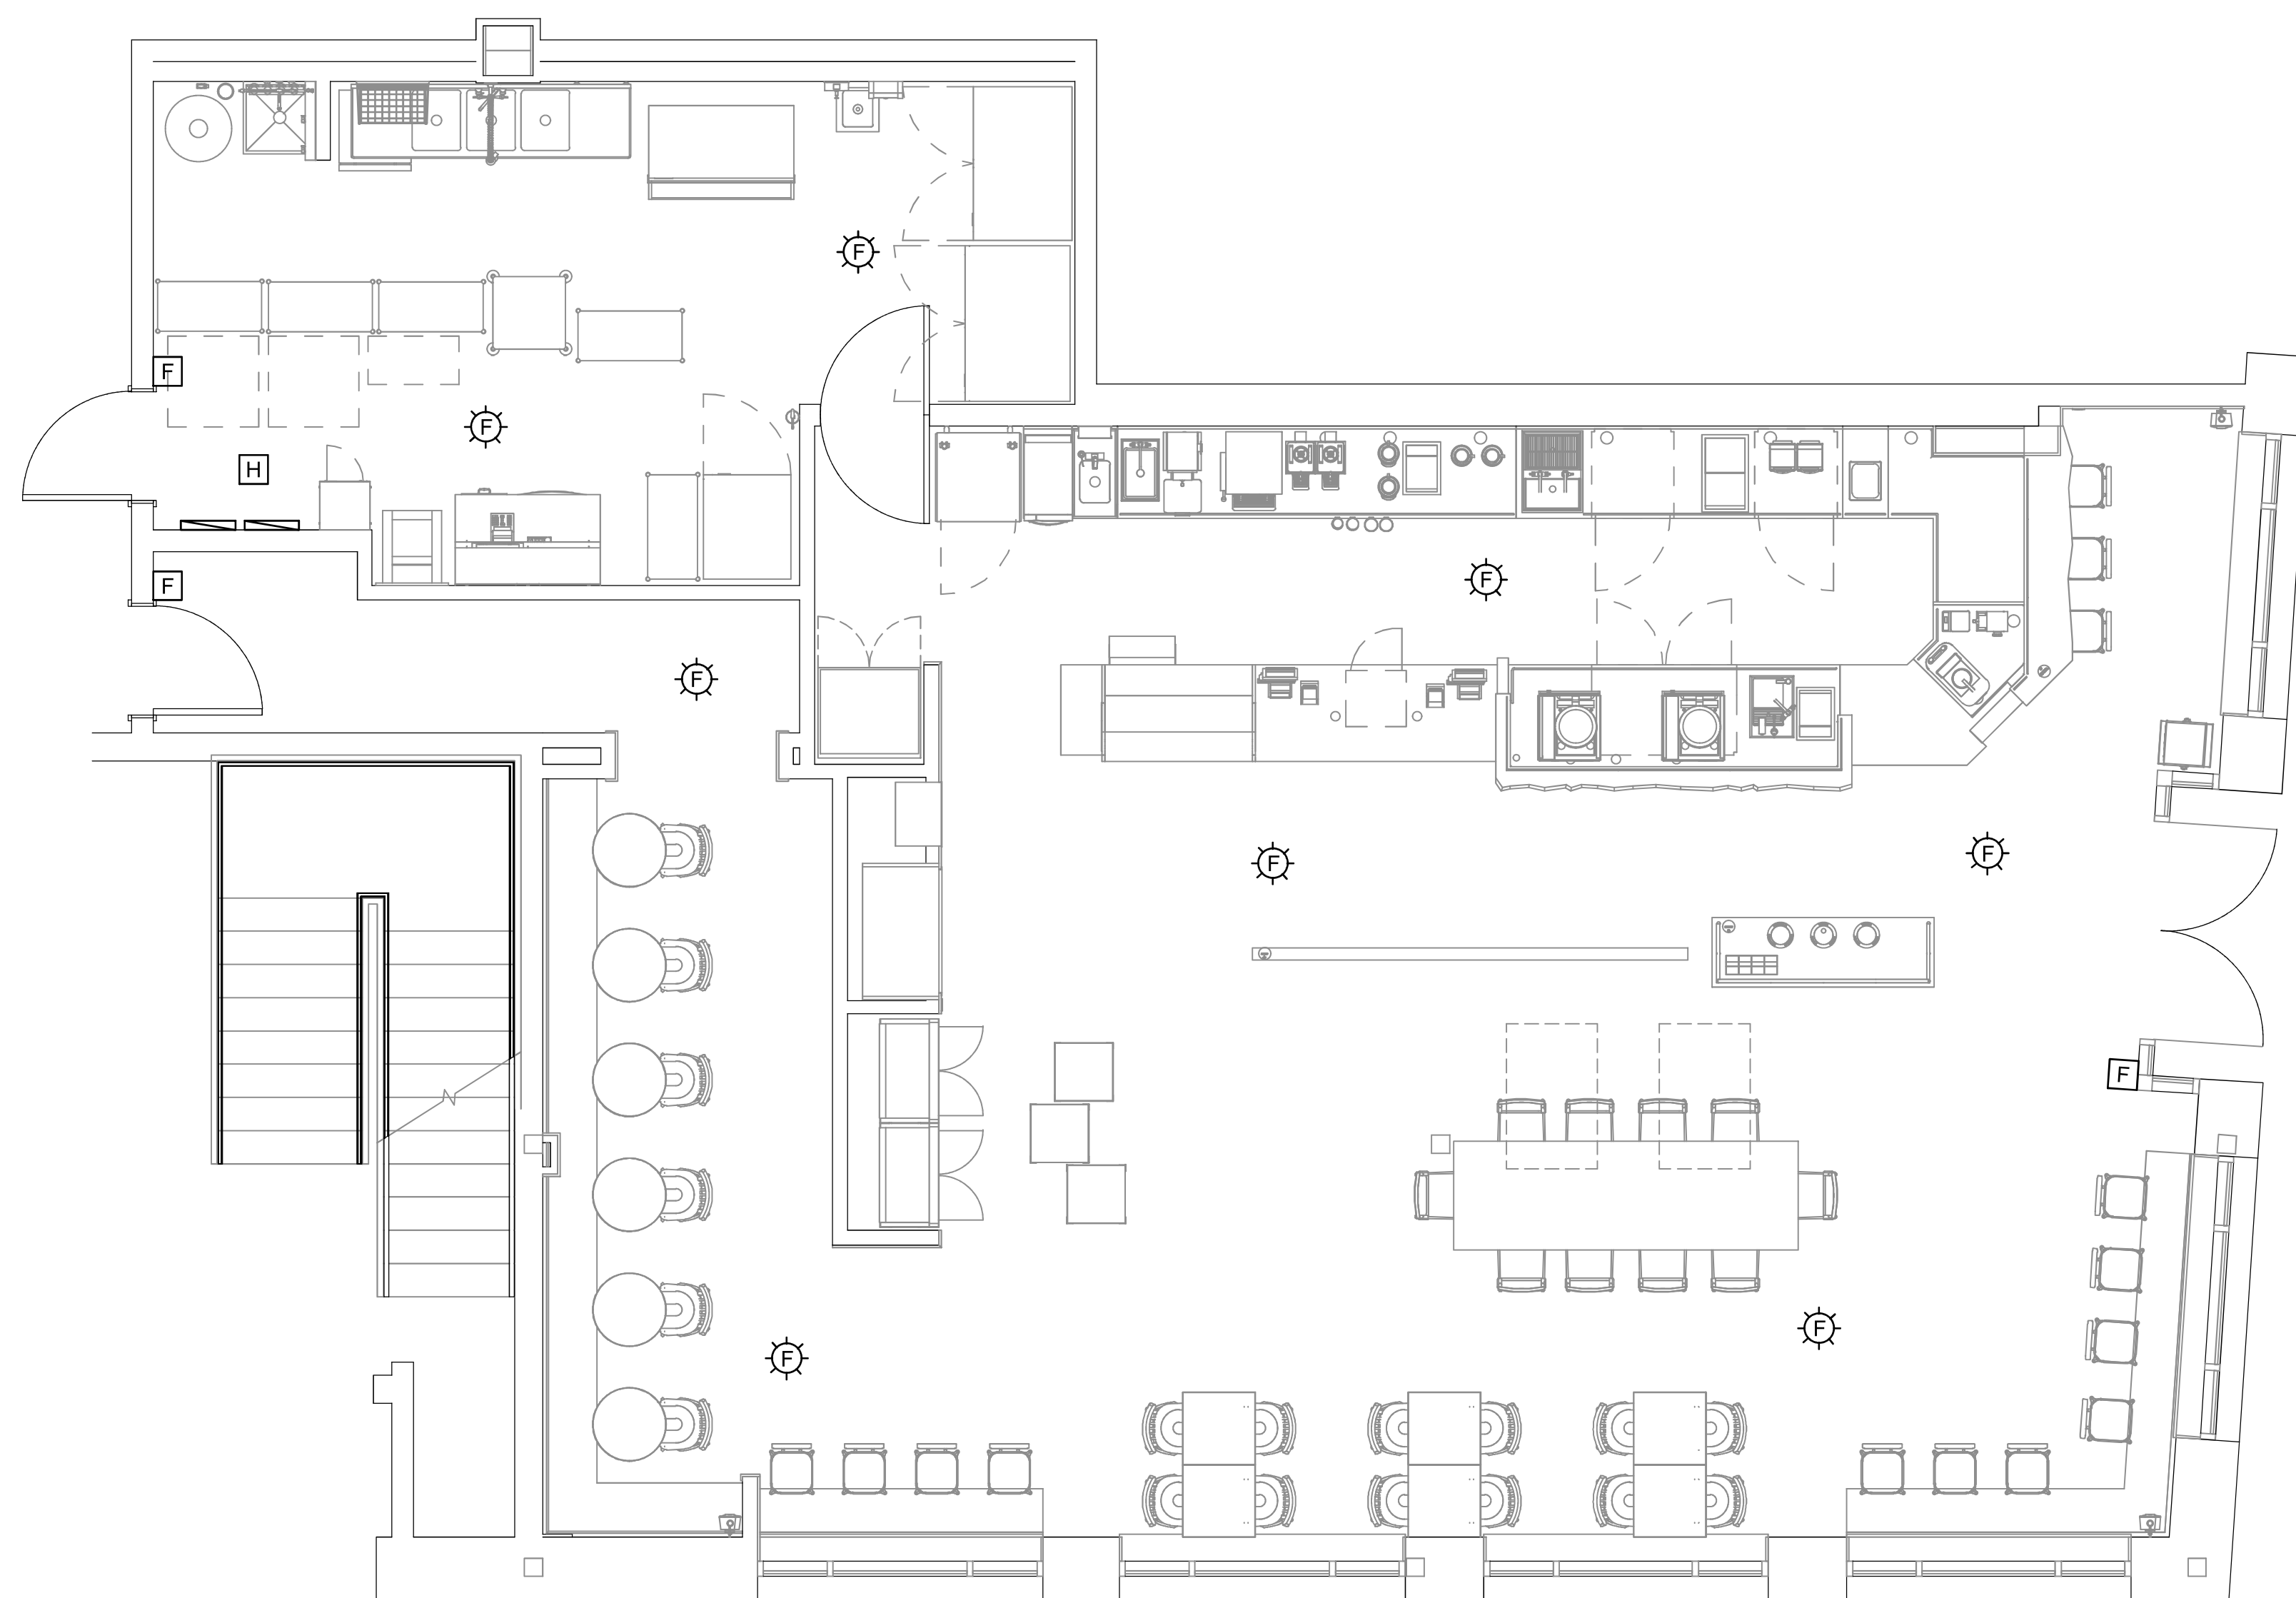

NOTE: CONTRACTOR TO SUPPLY AND INSTALL ALL DEVICES AND WIRING. ENTIRE INSTALLATION SHALL BE IN ACCORDANCE WITH LOCAL JURISDICTION REQUIREMENTS. VERIFY CONNECTION REQUIREMENTS WITH THE BUILDING SYSTEM. COORDINATE ANY WORK REQUIRED ON BUILDING SYSTEM WITH OWNER PRIOR TO WORK.

2 FIRE ALARM SYSTEM LEGEND

Scale: NTS

1 FIRE ALARM PLAN

Scale: 1/4" = 1'-0"



PROJECT NAME:
COMMERCIAL STREET
PROJECT ADDRESS:
**145 COMMERCIAL STREET
PORTLAND, ME 04101
CUMBERLAND COUNTY**

STORE #: 19384
PROJECT #: 58862-001
CONCEPT: MCS
PALETTE: HERITAGE
ISSUE DATE: JAN. 11, 2013
DESIGN MANAGER: E. ZAKAMAREK
LEED® AP:
PRODUCTION DESIGNER: NORR ILLINOIS
CHECKED BY: JAK / CJS

SHEET TITLE:
Fire Alarm Plan

SCALE: 1/4" = 1'-0"

SHEET NUMBER:
FA-001