



FIRE ALARM SYSTEM LAYOUT – FIRST FLOOR

SCALE: 1/8"=1'

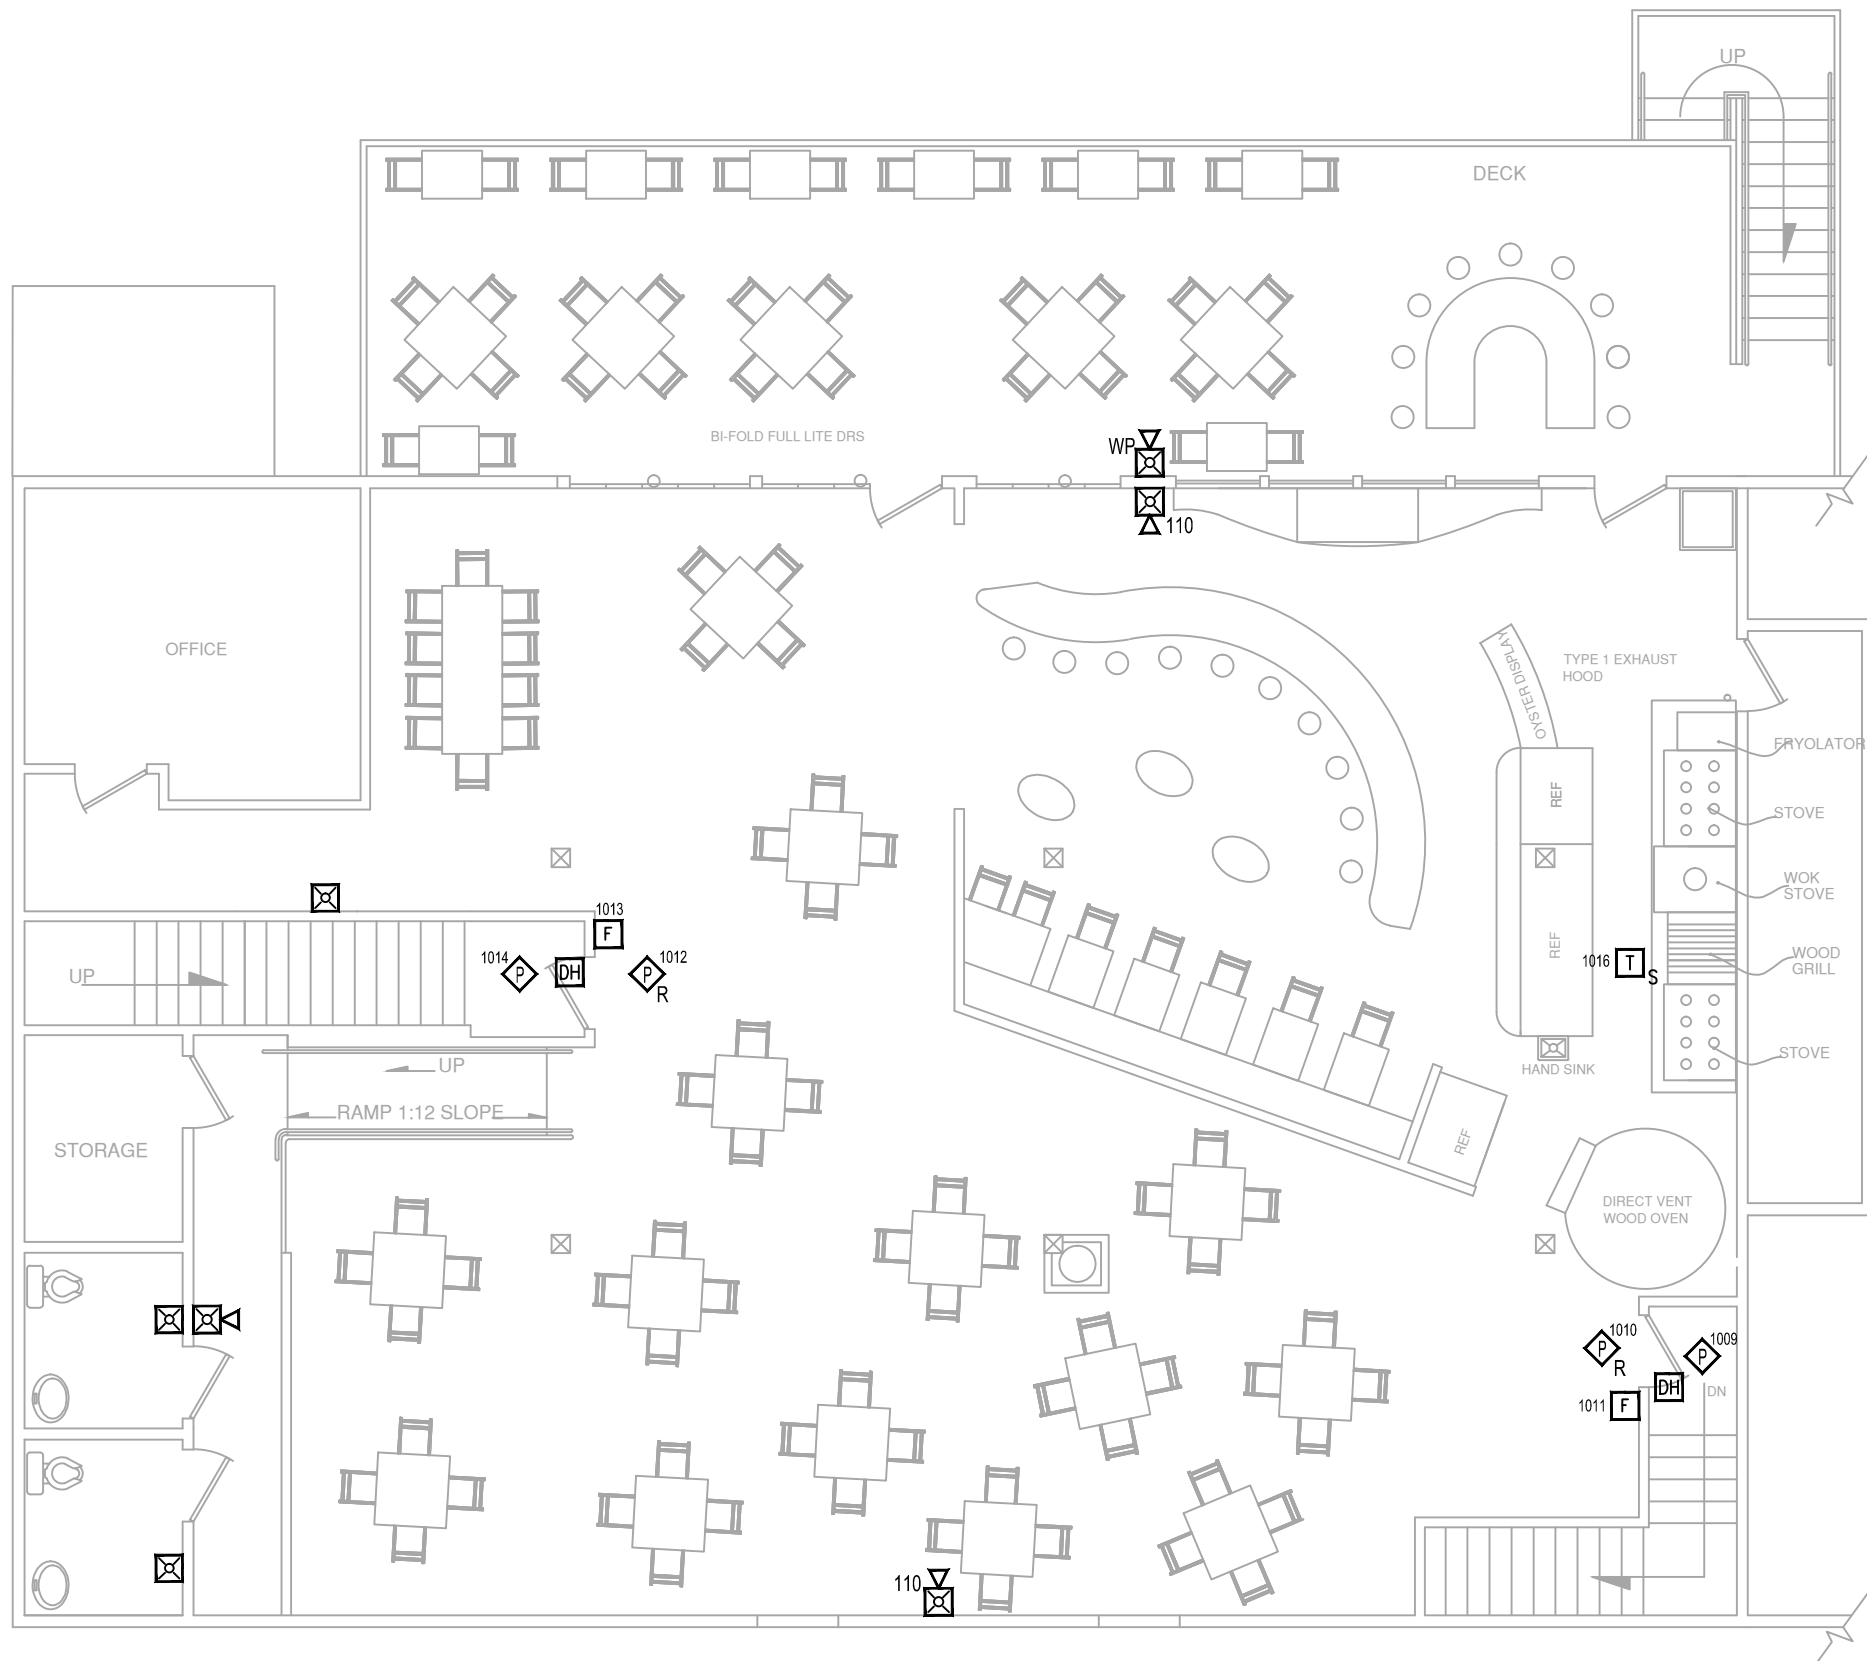


FIRE ALARM SYSTEM LAYOUT – SECOND FLOOR

SCALE: 1/8"=1'

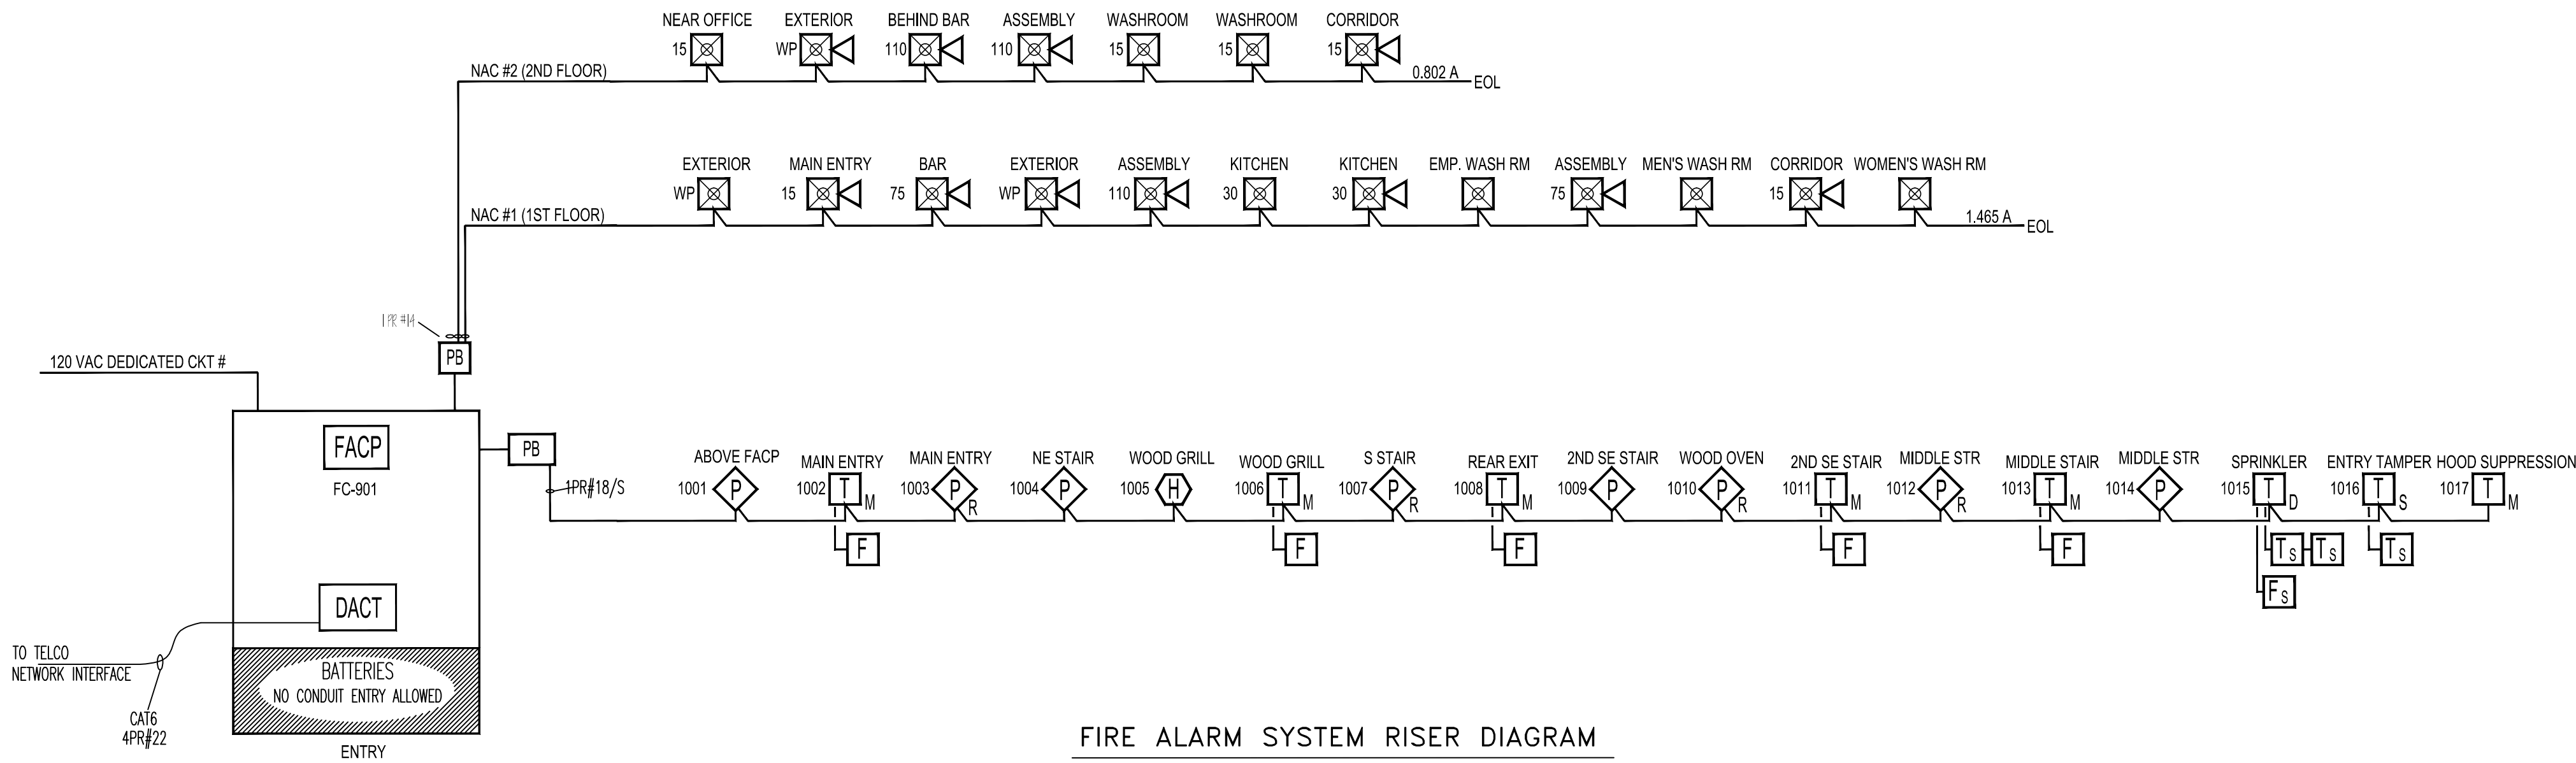


FIRE ALARM SYSTEM RISER DIAGRAM

SCALE: N.T.S.


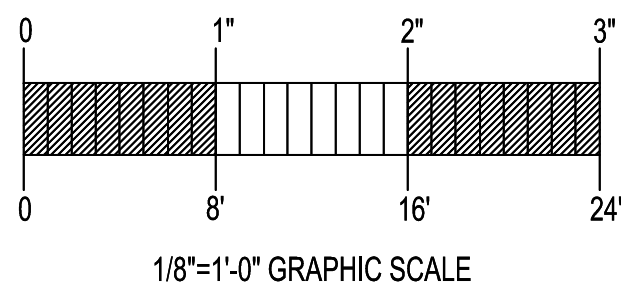


1/8"=1'-0" GRAPHIC SCALE

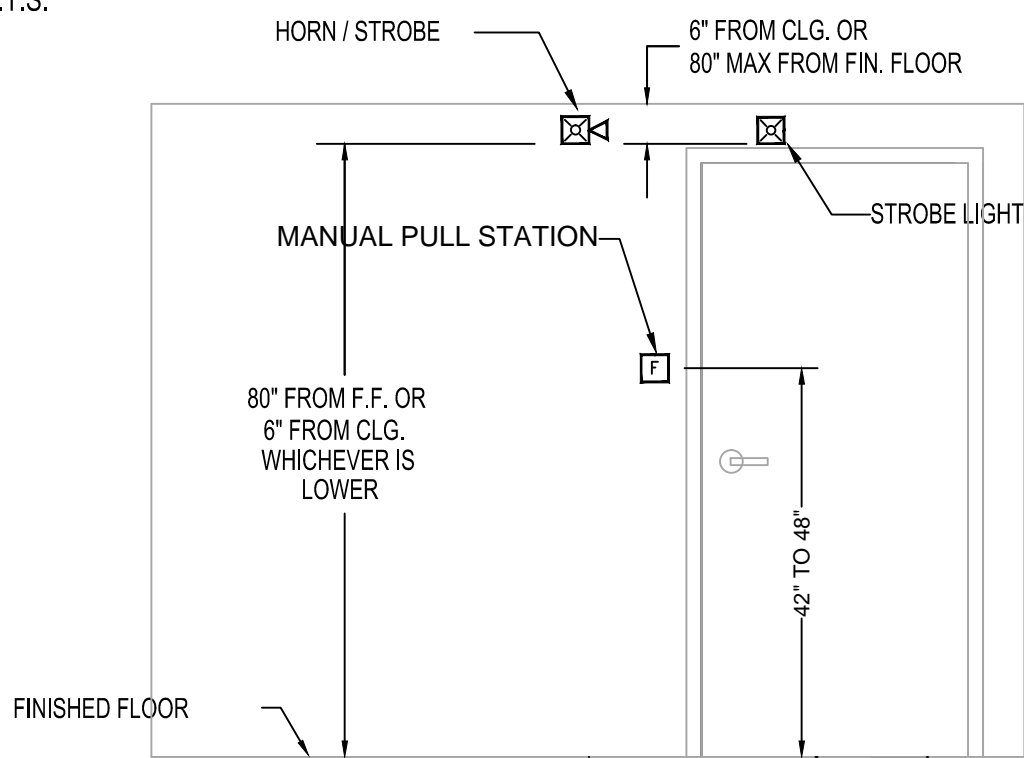


DEVICE ELEVATION DETAIL  
NOT TO SCALE

QUANT.	SYM.	DESCRIPTION	MODEL	BACK BOX
1	FACP	FIRE ALARM CONTROL PANEL	FC-901	ENCLOSURE
4	◇	CEILING SMOKE DETECTOR/BASE	OH921/DB-11	SINGLE GANG OR OCTAGON BOX
4	◇ <sub>R</sub>	SMOKE DETECTOR W/ RELAY BASE	OH921/DB-HR	SINGLE GANG OR OCTAGON BOX
1	H	THERMAL DETECTOR/ BASE	HI921/DB-11	SINGLE GANG OR OCTAGON BOX
5	F	MANUAL PULL STATION	MSM-KD/HTRI-M	3.5" DEEP SINGLE GANG
3	T <sub>I</sub>	SINGLE INPUT MONITOR MODULE	HTRI-S	4" SQUARE BOX
1	T <sub>D</sub>	DUAL INPUT MONITOR MODULE	HTRI-D	4" SQUARE BOX
7	⊠	FIRE ALARM MULTI CANDELLA STROBE	ZR-MC-R	4" SQUARE
9	⊠ <sub>R</sub>	FIRE ALARM MULTI CANDELLA HORN/STROBE	ZH-MC-R	4" SQUARE
2	WP ⊠ <sub>R</sub>	WEATHERPROOF HORN/STROBE	AS-75-R-WP	WPBBS-R
1	WP ⊠	FIRE ALARM MULTI CANDELLA STROBE	ST-75-R-WP	WPBBS-R

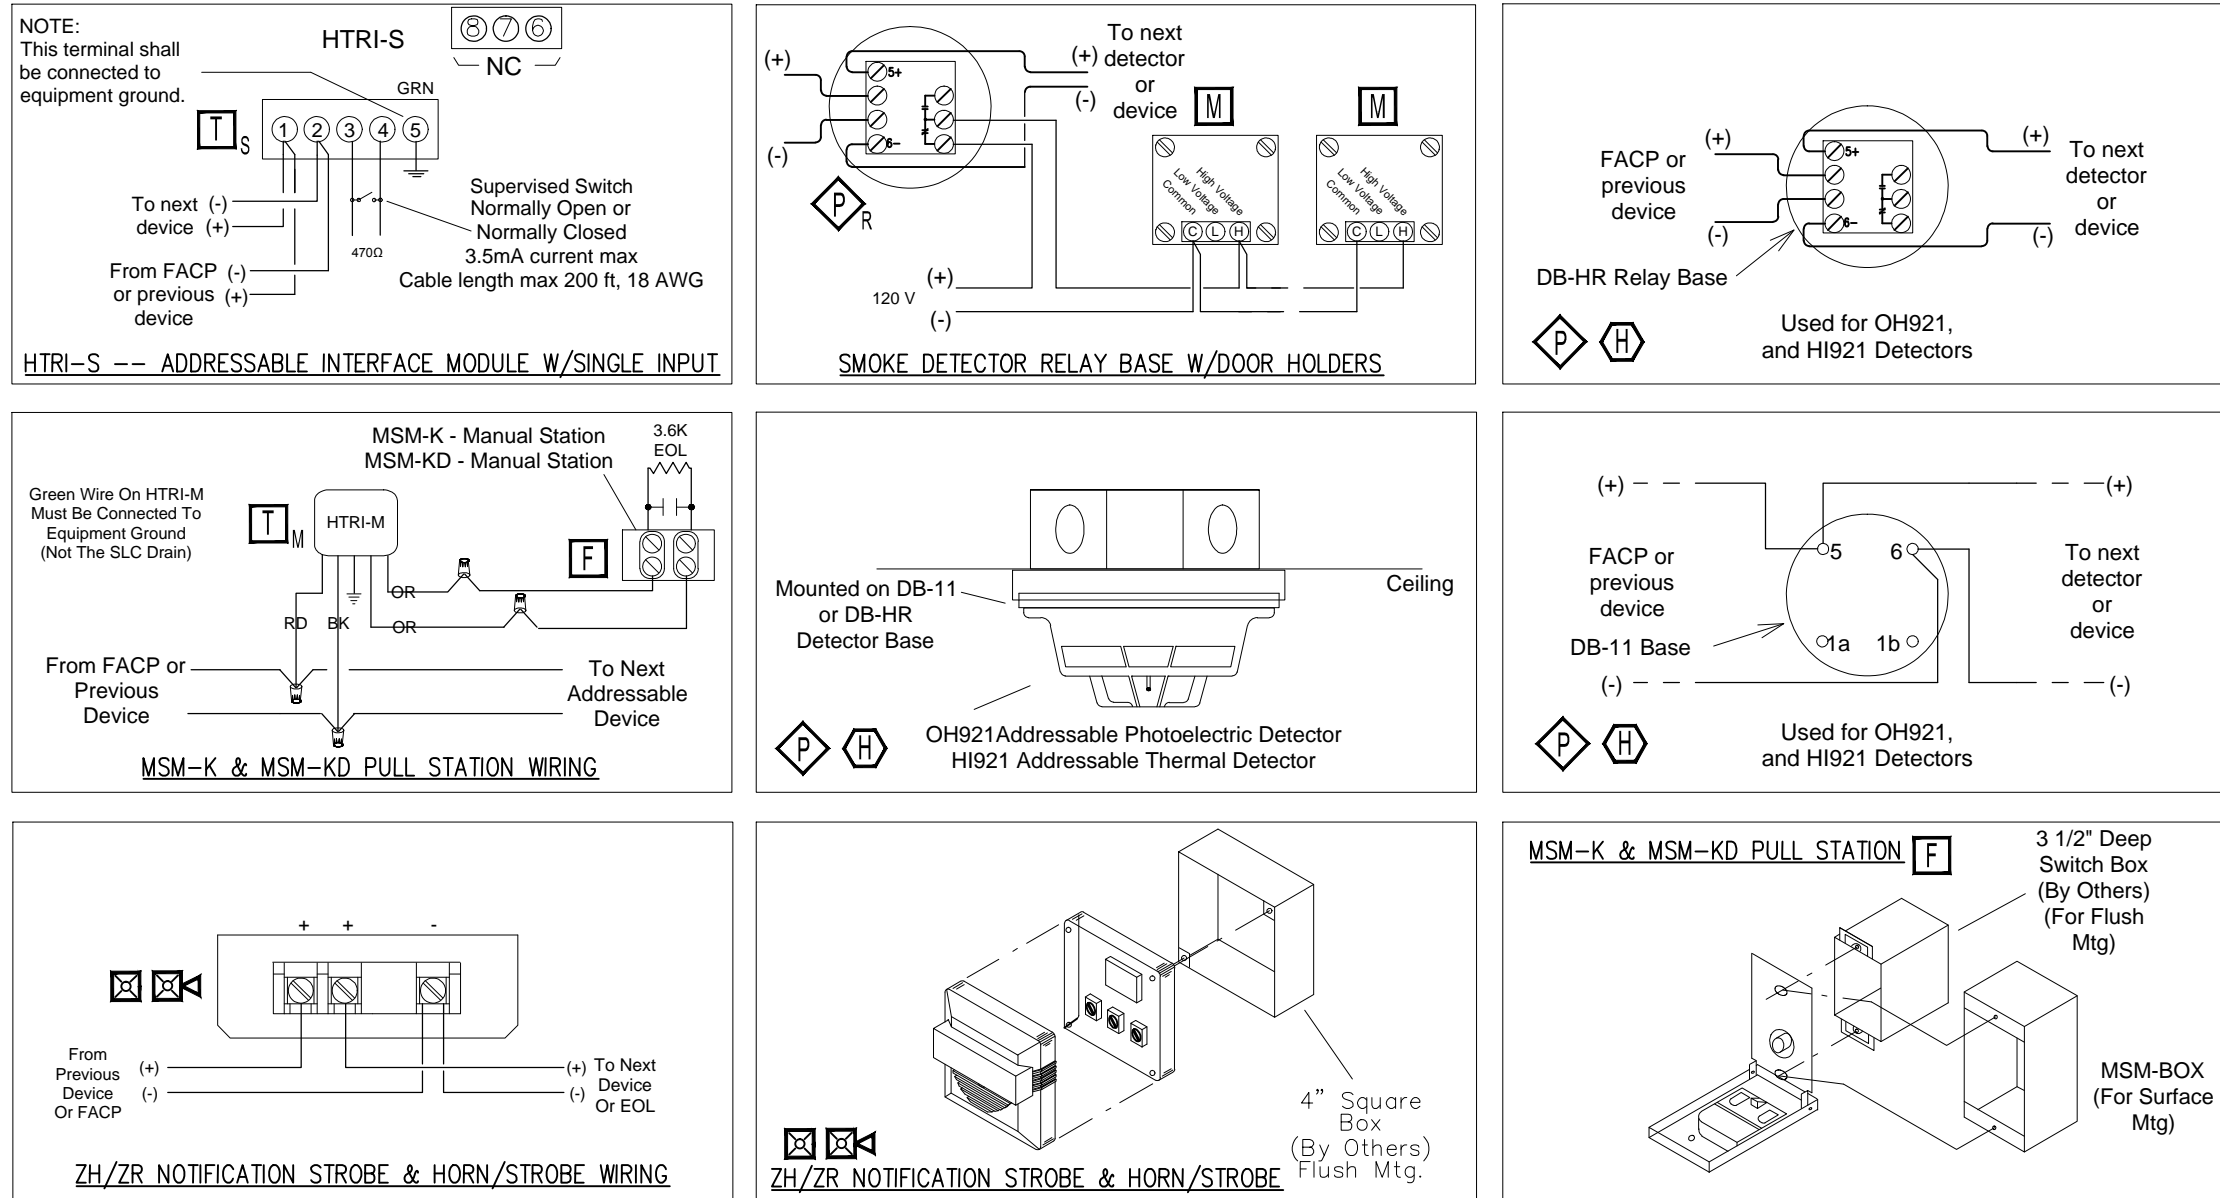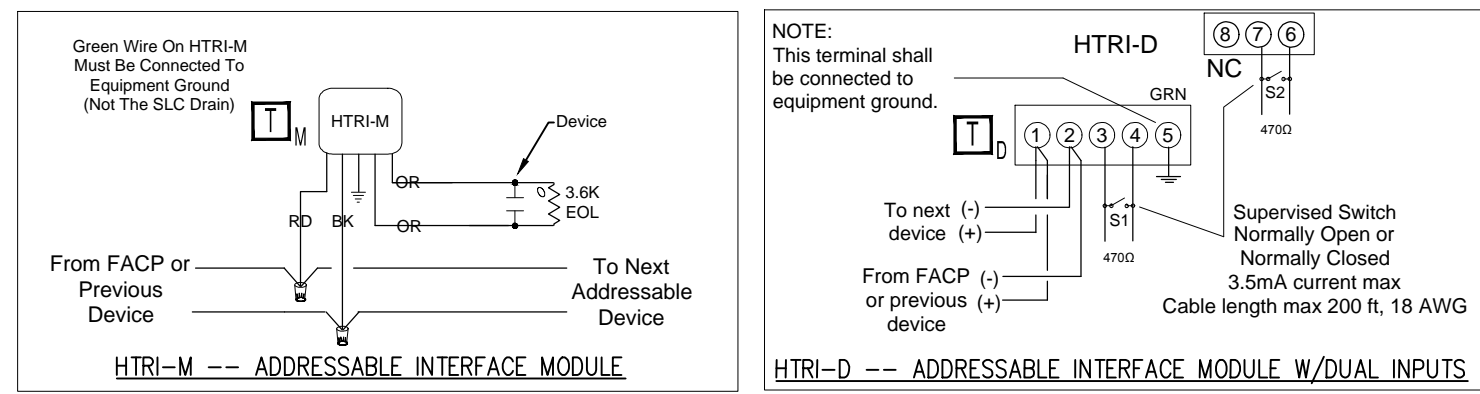

DEVICE MOUNTING & WIRING DETAIL

SCALE: N.T.S.

GENERAL NOTES	DATE	REVISIONS	REQUIRED APPROVALS	POPPLY'S FISH SHACK PORTLAND, ME	FIRE ALARM SYSTEM
SCOPE OF WORK: INSTALL NEW ADDRESSABLE FIRE ALARM SYSTEM. ALL INSTALLATION PRACTICES SHALL COMPLY WITH NFPA 70, 72	3/22/13	REVISED FOR SUBMITTAL	OWNER PORTLAND FIRE DEPARTMENT		PLANS & DETAILS
OCCUPANCY CLASSIFIED AS ASSEMBLY WITH OCCUPANT LOAD AT 287			DRAWN BY CRM	CONTRACT WITH: OWNER	DWG. NO. 1 OF 1
			CHECKED BY BWB	 <b>EASTERN FIRE SERVICES, INC.</b> AUBURN/LEWISTON INDUSTRIAL AIRPARK, AUBURN, MAINE 04210	JOB NUMBER
			CONTRACTOR LICENSE #		SCALE AS SHOWN
					DATE 2/21/13