



Roof Plan

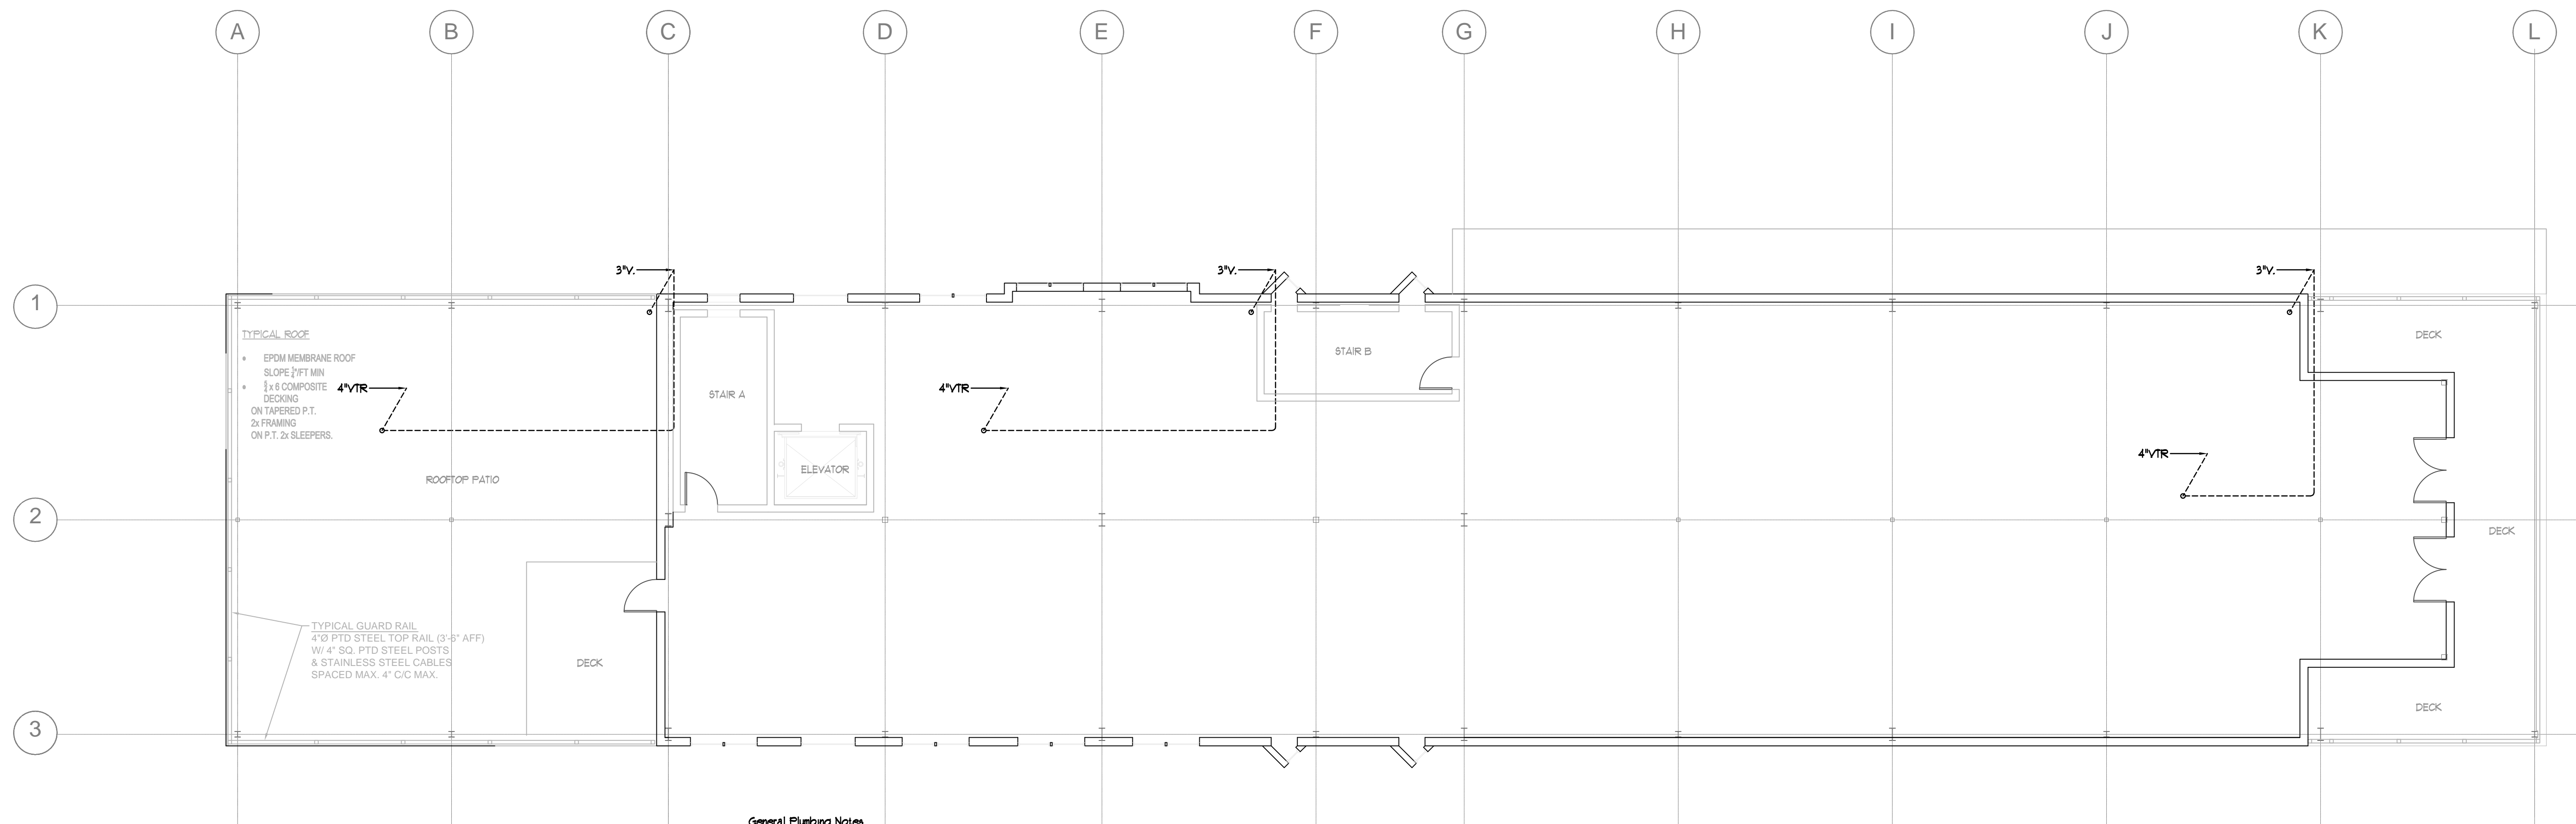

3rd Floor Plan

PROGRESS PRINT
NOT FOR CONSTRUCTION

Prepared For:	MAINE WHARF LLC	
	72 COMMERCIAL STREET PORTLAND, ME 04101	
Consulting Engineer:	 BENNETT ENGINEERING MECHANICAL - ELECTRICAL (207) 865-5475	
	ARCHETYPE architects 48 Union Wharf Portland, Maine 04101 (207) 772-6022 Fax (207) 772-4056	
Project:	MAINE WHARF	
Revisions:	68 COMMERCIAL STREET PORTLAND, MAINE	
Date:	Scale: 1/8" = 1'-0" or As Noted	First Floor Tenant Fit-Up Plumbing 3rd Floor Plan and Roof Plan
P.2		