

Revisions

Maine Wharf LLC

72 Commercial Street  
Portland, ME


Building A - Maine Wharf  
HVAC and Plumbing Plans  
Portland Science Center



Job No.: 3732  
Date: 5/19/15  
Scale: 1/8" = 1'-0" or A.N.  
Drawn by: SP Doel  
Checked by: SP Doel

Drawing Title:  
**Mechanical Ground  
Level Plan**

**M.3**

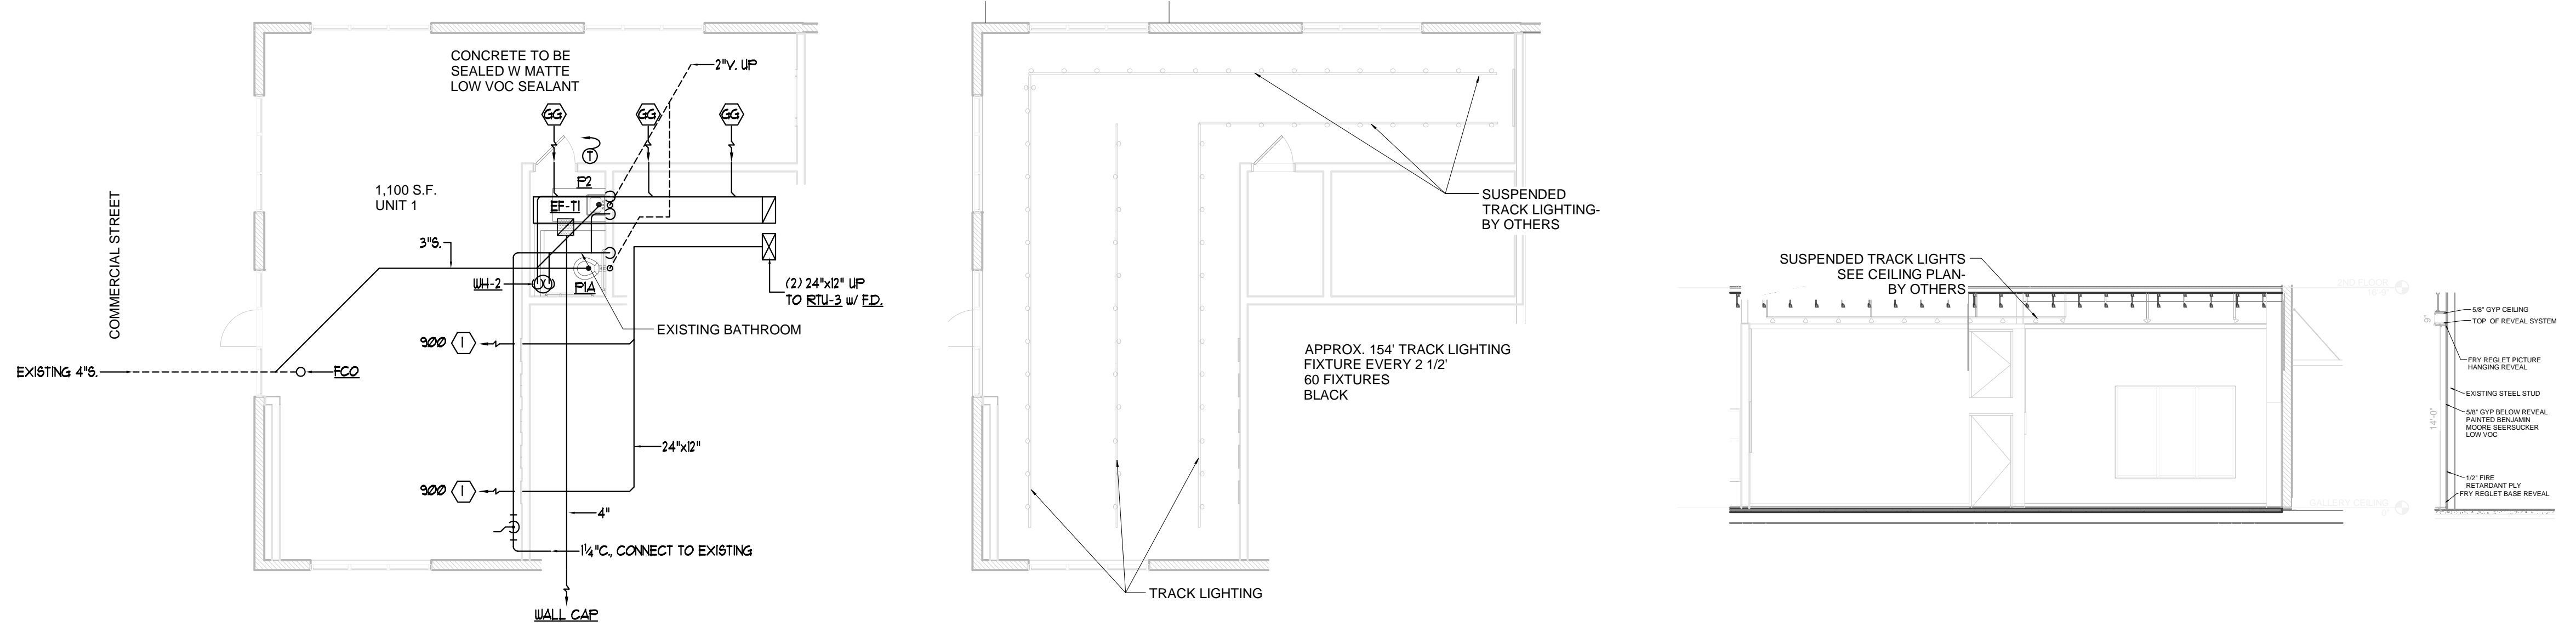

HVAC / Plumbing Lower Level Gallery Plan

**Atlantic Comfort  
Systems, Inc.**  
Mechanical Contractor • 207-884-8860  
882 Hill Street Biddeford, ME 04005  
www.atlanticcomfort.com