
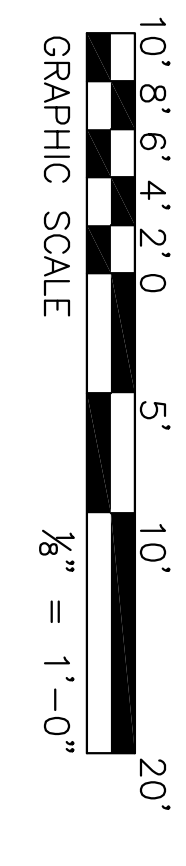


LIGHTING SCHEDULE	
10	Knight-Ridder Medium 2x5 Surface Angle 2x5 Watt Arm in FF Flat Bronze Finish with 6 inch mounting Plate
20	Lincoln QLAW23 LED Area / WAH BZ (Bronze Finish)
30	Philips Stoneman LxWxHx LxPT7 Titanium

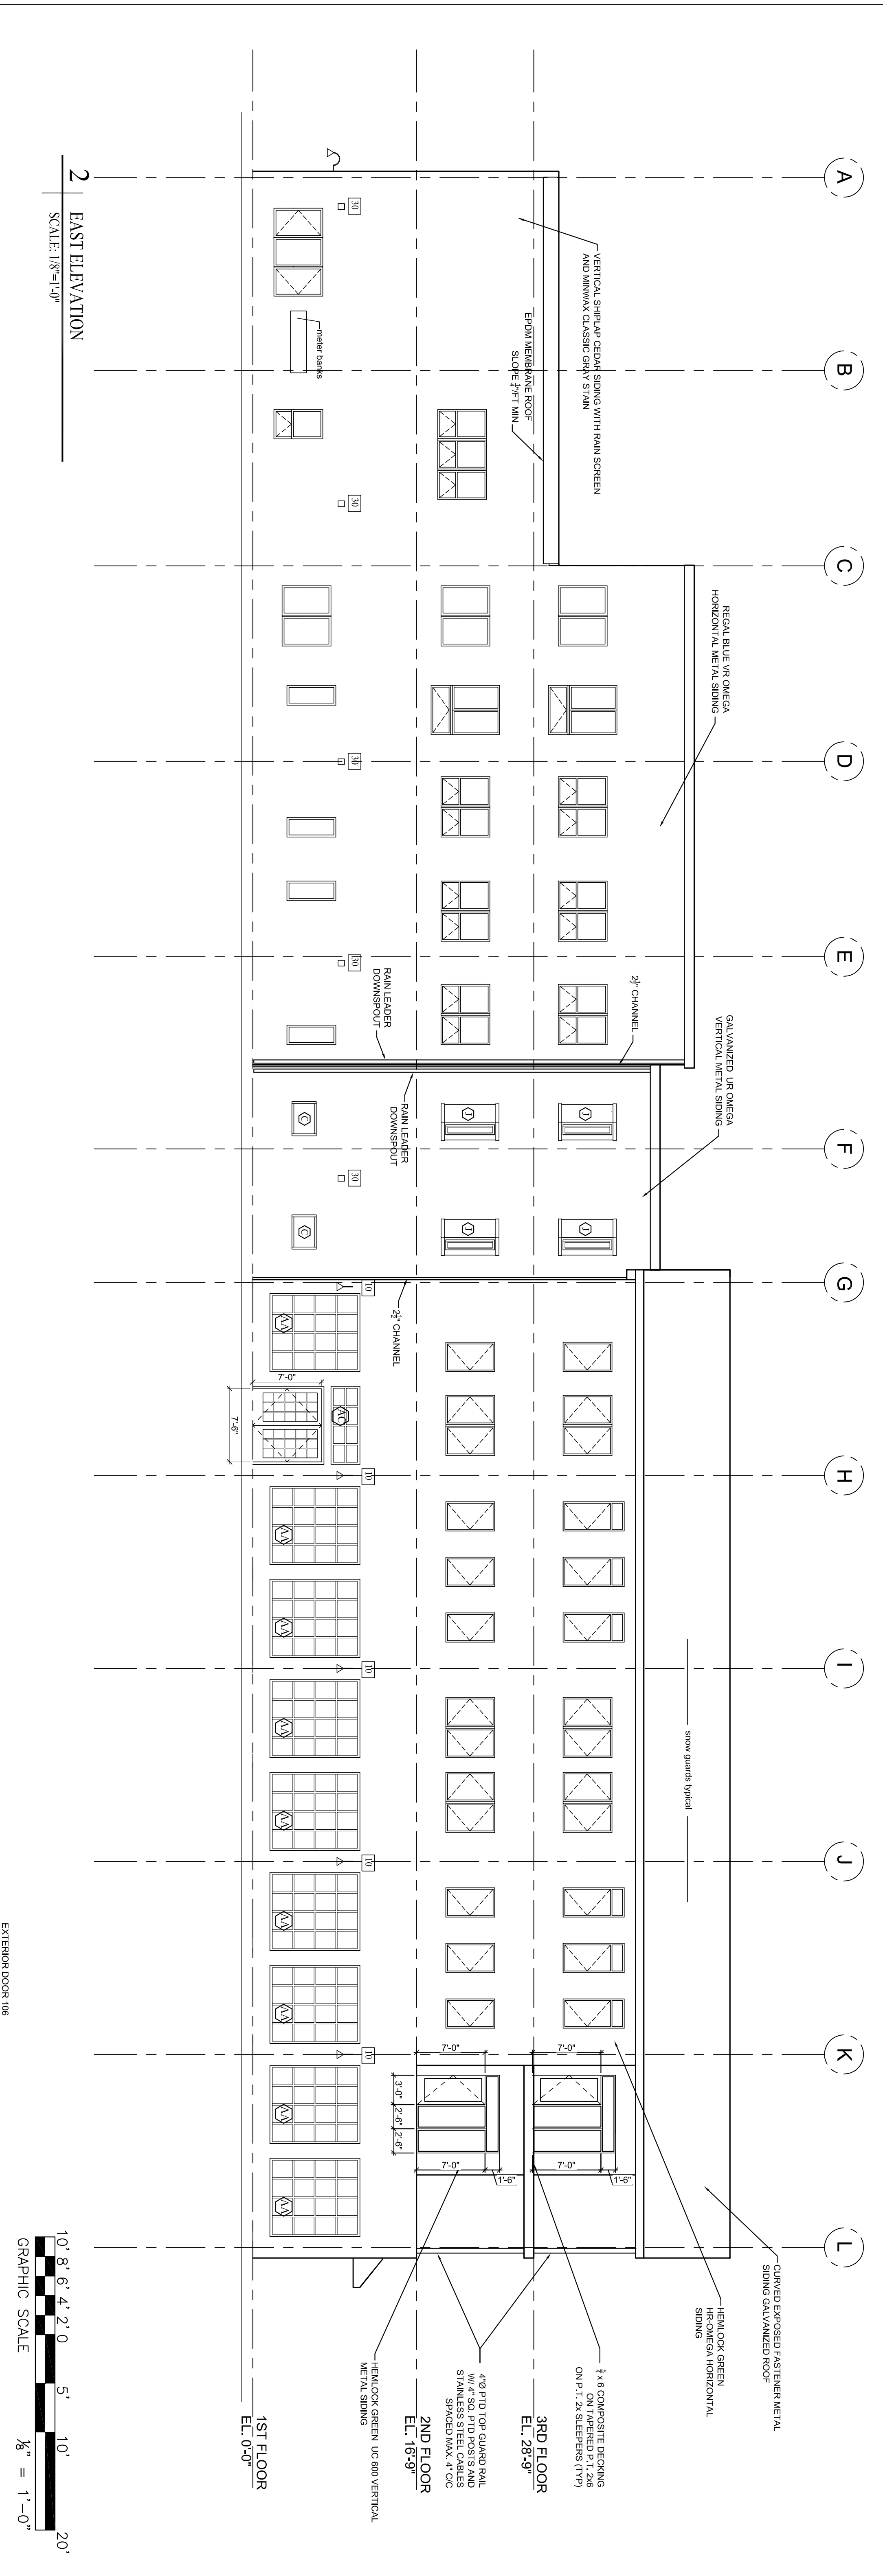

A2.01	Date: 31 OCT 2013	Scale: 1/8" = 1'-0"	Revisions: 12 NOV. 2013 31 MARCH 2014 11 APRIL 2014 23 APRIL 2014 6 OCTOBER 2014	Project: MAINE WHARF 68 COMMERCIAL STREET PORTLAND, MAINE	Architect: ARCHETYPE architects 48 Union Wharf Portland, Maine 04101 (207) 772-6022 Fax (207) 772-4056	Consulting Engineer:	Prepared For: MAINE WHARF LLC 72 COMMERCIAL STREET PORTLAND, ME 04101
	EAST AND WEST ELEVATIONS						