



HVAC and Plumbing Third Floor Plan

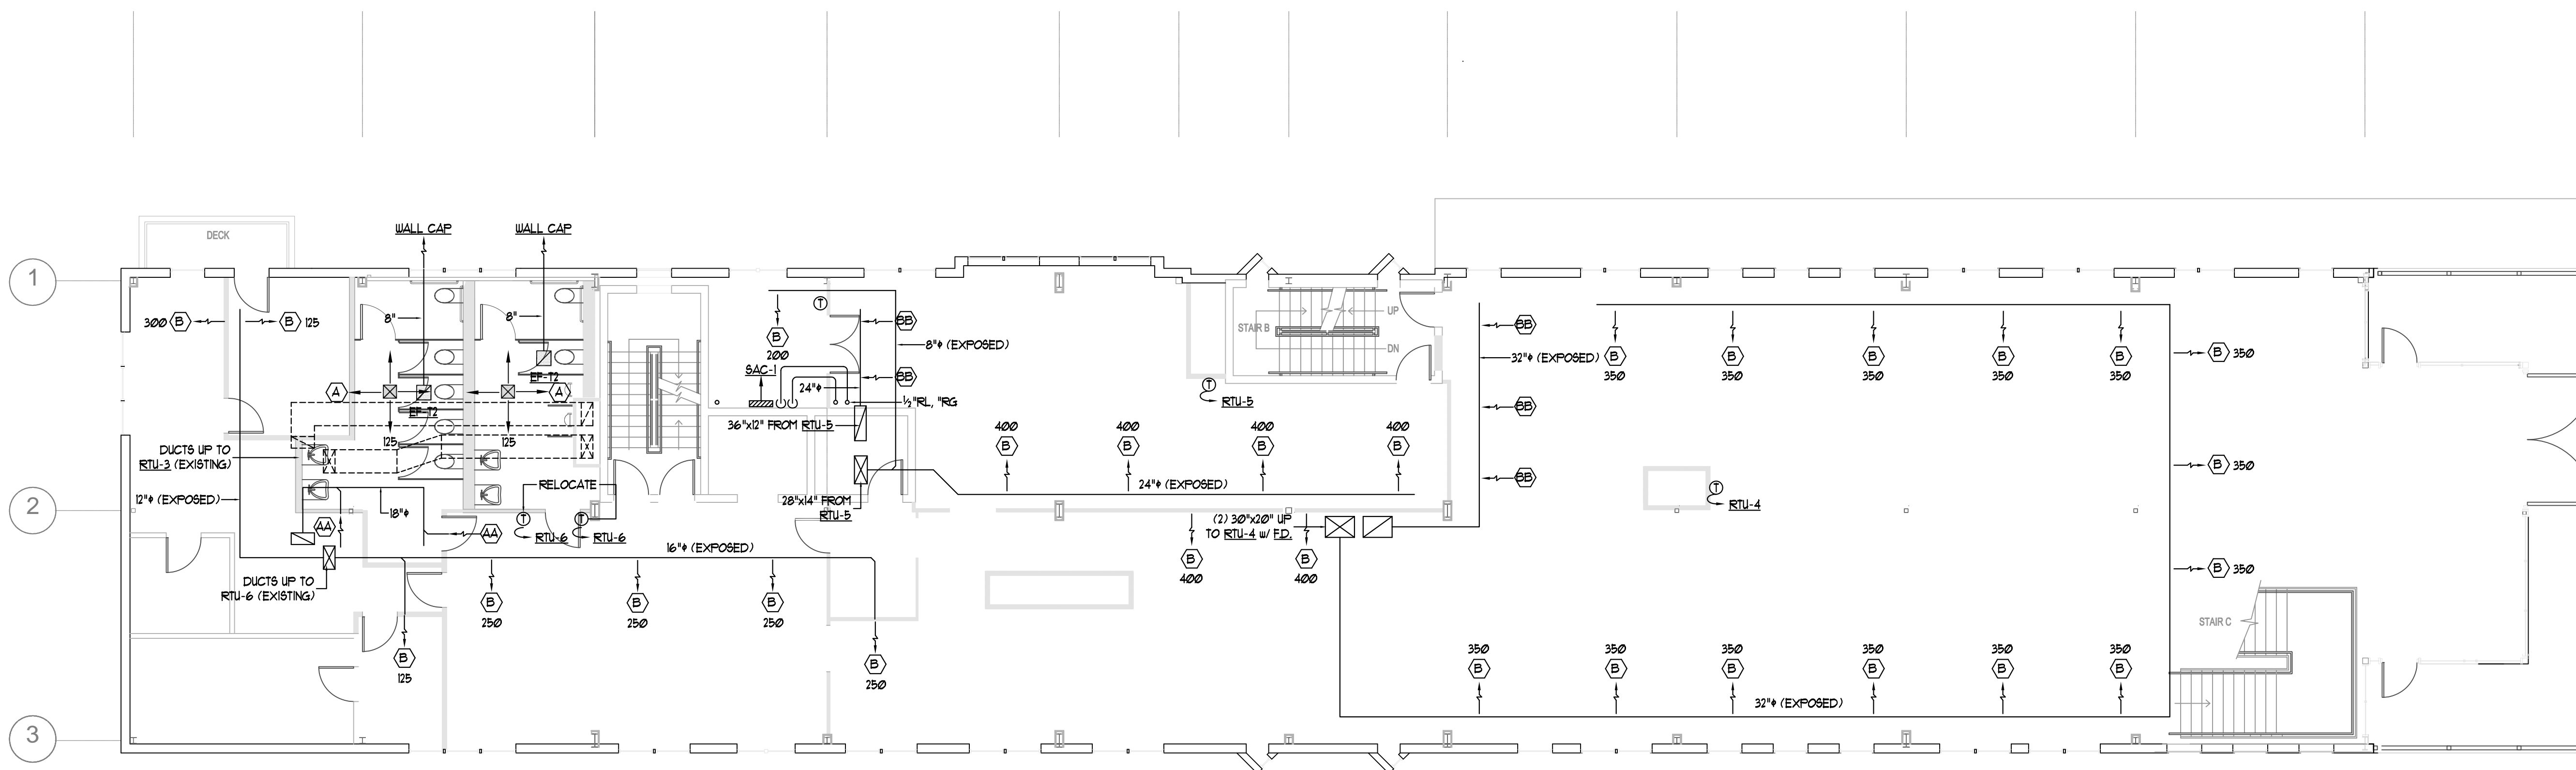

HVAC Second Floor Plan

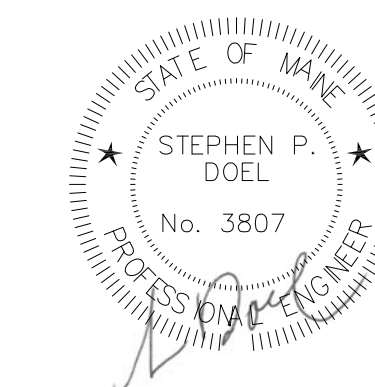


Revisions

Maine Wharf LLC

72 Commercial Street
Portland, ME

Building A - Maine Wharf
HVAC and Plumbing Plans
Portland Science Center

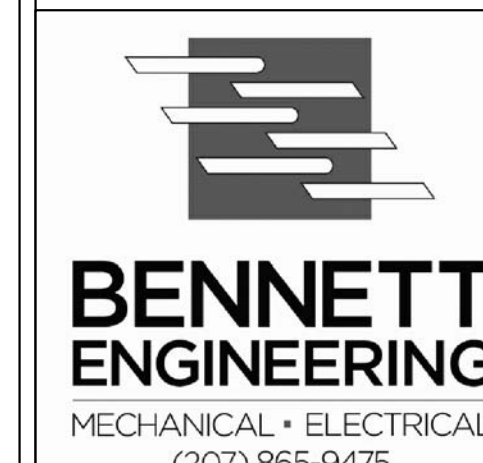

Job No.: 3732
Date: 5/19/15
Scale: 1/8" = 1'-0" or A.N.
Drawn by: SP Doel
Checked by: SP Doel

Drawing Title:
**HVAC / Plumbing
2nd and 3rd Floor Plans**

**Atlantic Comfort
Systems, Inc.**
Mechanical Contractor • 207-284-8380
882 Hill Street Biddeford, ME 04005
www.atlanticcomfort.com

M.1