


LEGEND:

WALL SECTION	
PLAN DETAIL	
FIRE EXTINGUISHER CABINET - SURFACE MTD.	
2 HEAD EMERGENCY LIGHT	
EXIT SIGN	
EXISTING WALL	
NEW WALL	

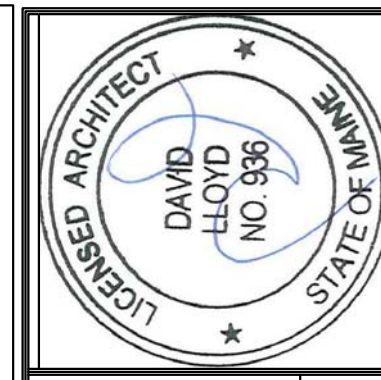

Prepared For:

Architect:
ARCHETYPE architects
 48 Union Wharf Portland, Maine 04101
 (207) 772-6022 Fax (207) 772-4056


Project:
250 COMMERCIAL STREET
 PORTLAND, MAINE

Revisions:


Date: 14 March 2013
 Scale: 1/4" = 1'-0"

FLOOR PLAN, FRAMING PLAN AND EGRESS


A1.00

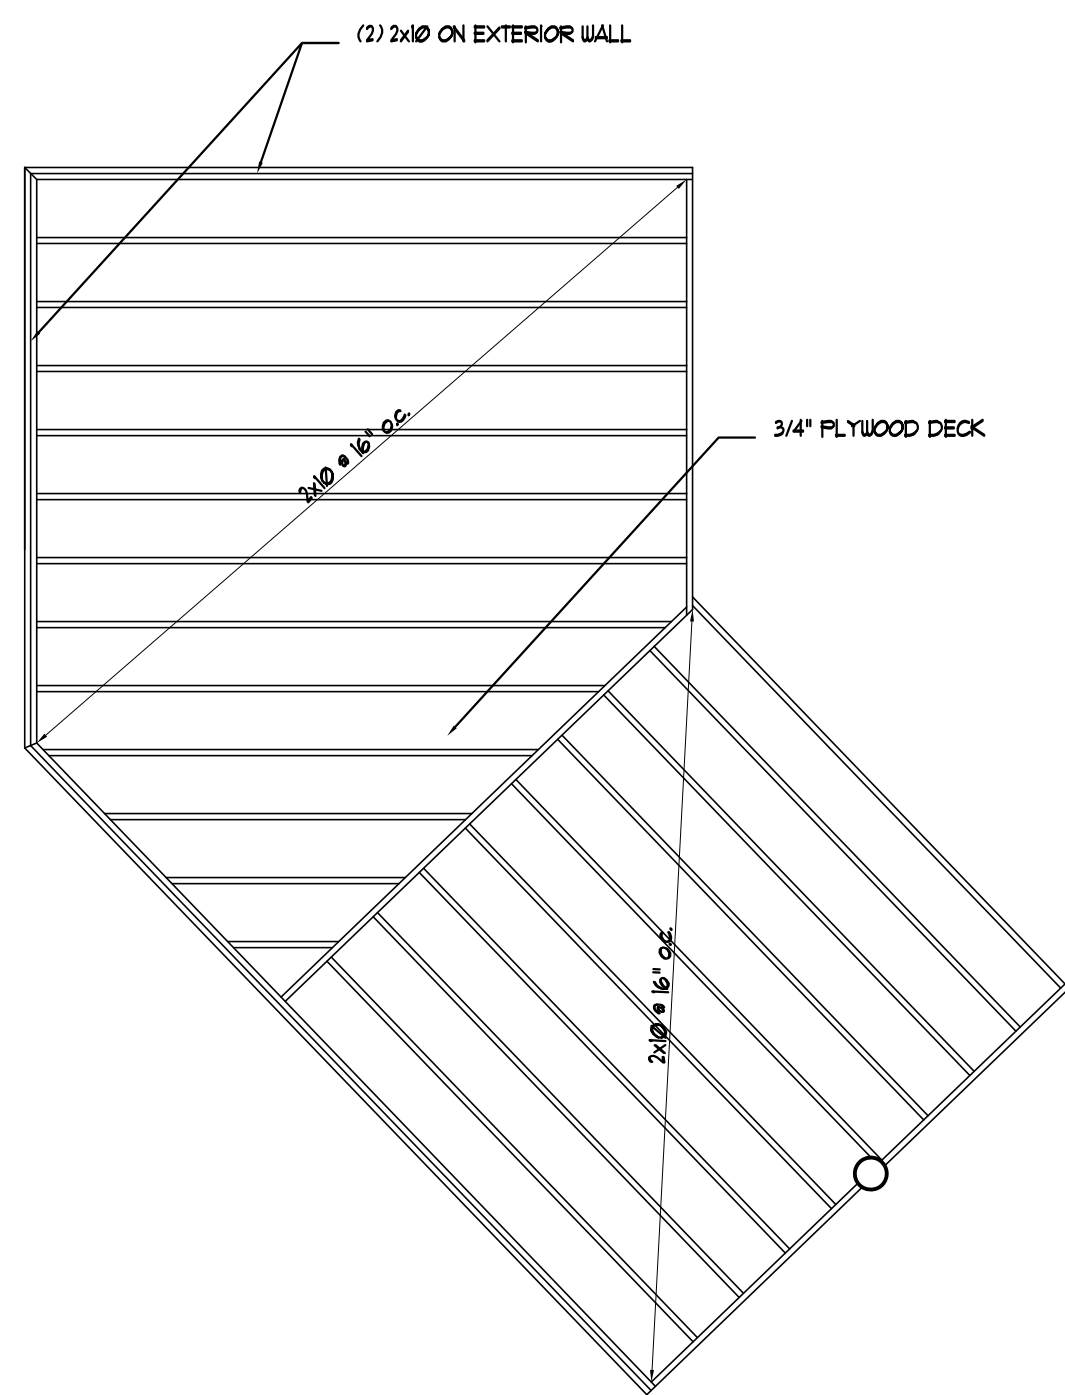


2 | FRAMING PLAN
 SCALE: 1/4"=1'-0"

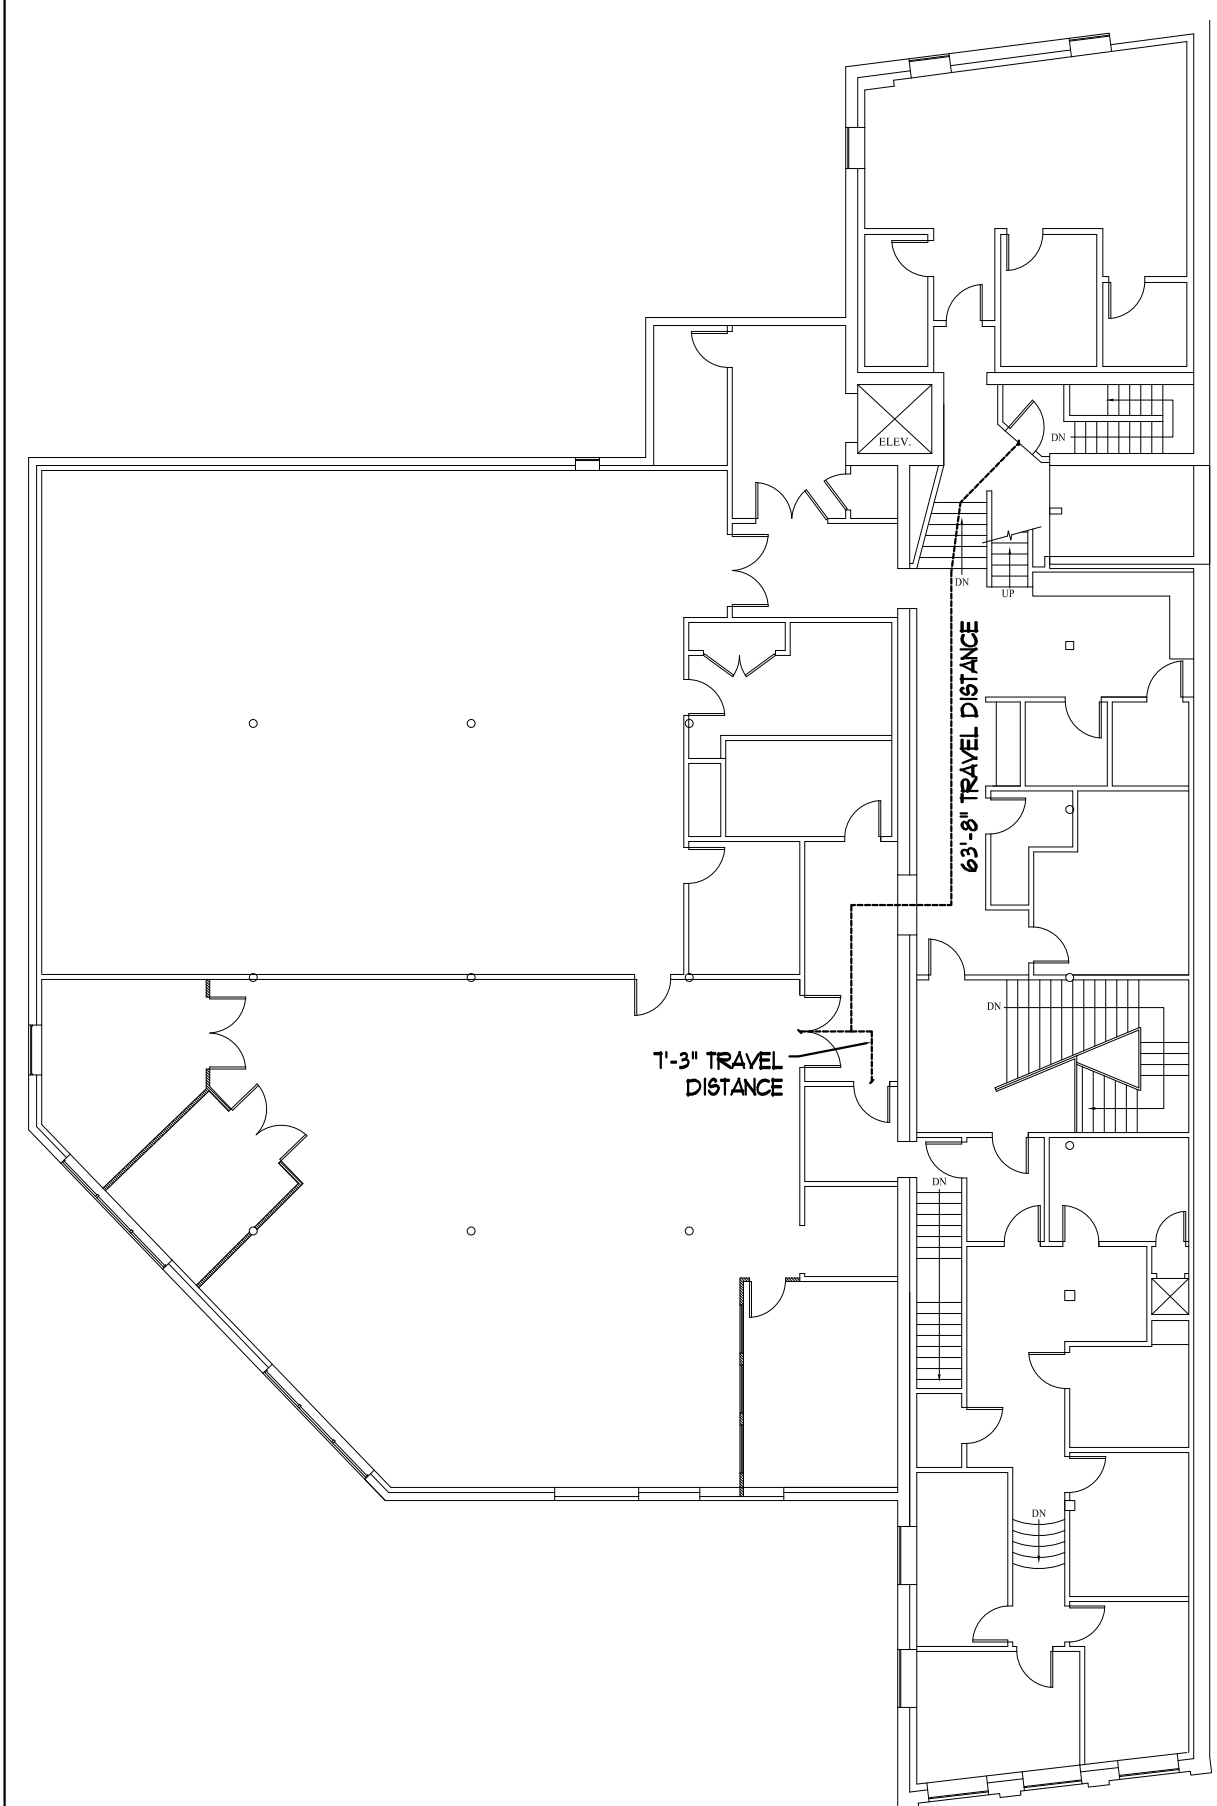

4 | SECOND FLOOR EGRESS PLAN
 SCALE: 1/16"=1'-0"

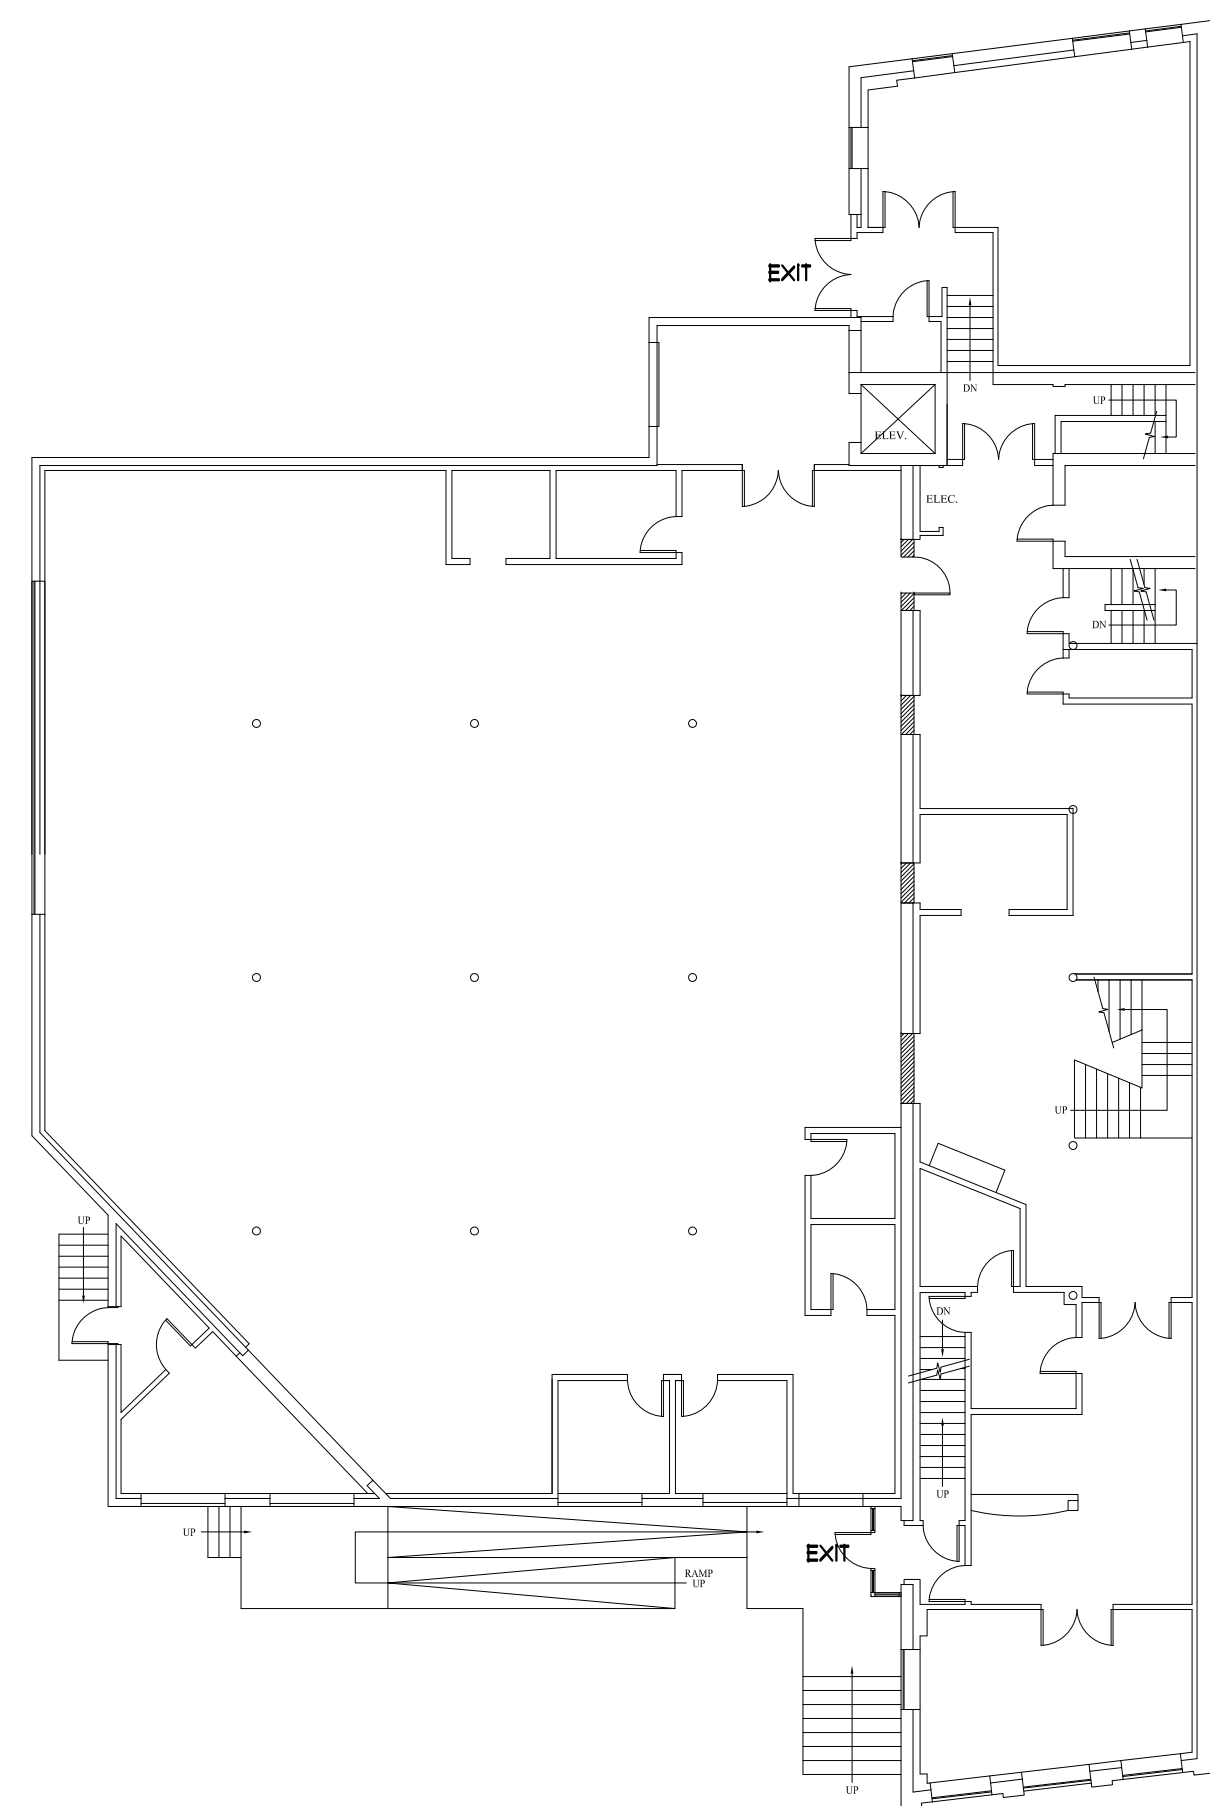

3 | FIRST FLOOR EGRESS PLAN
 SCALE: 1/16"=1'-0"

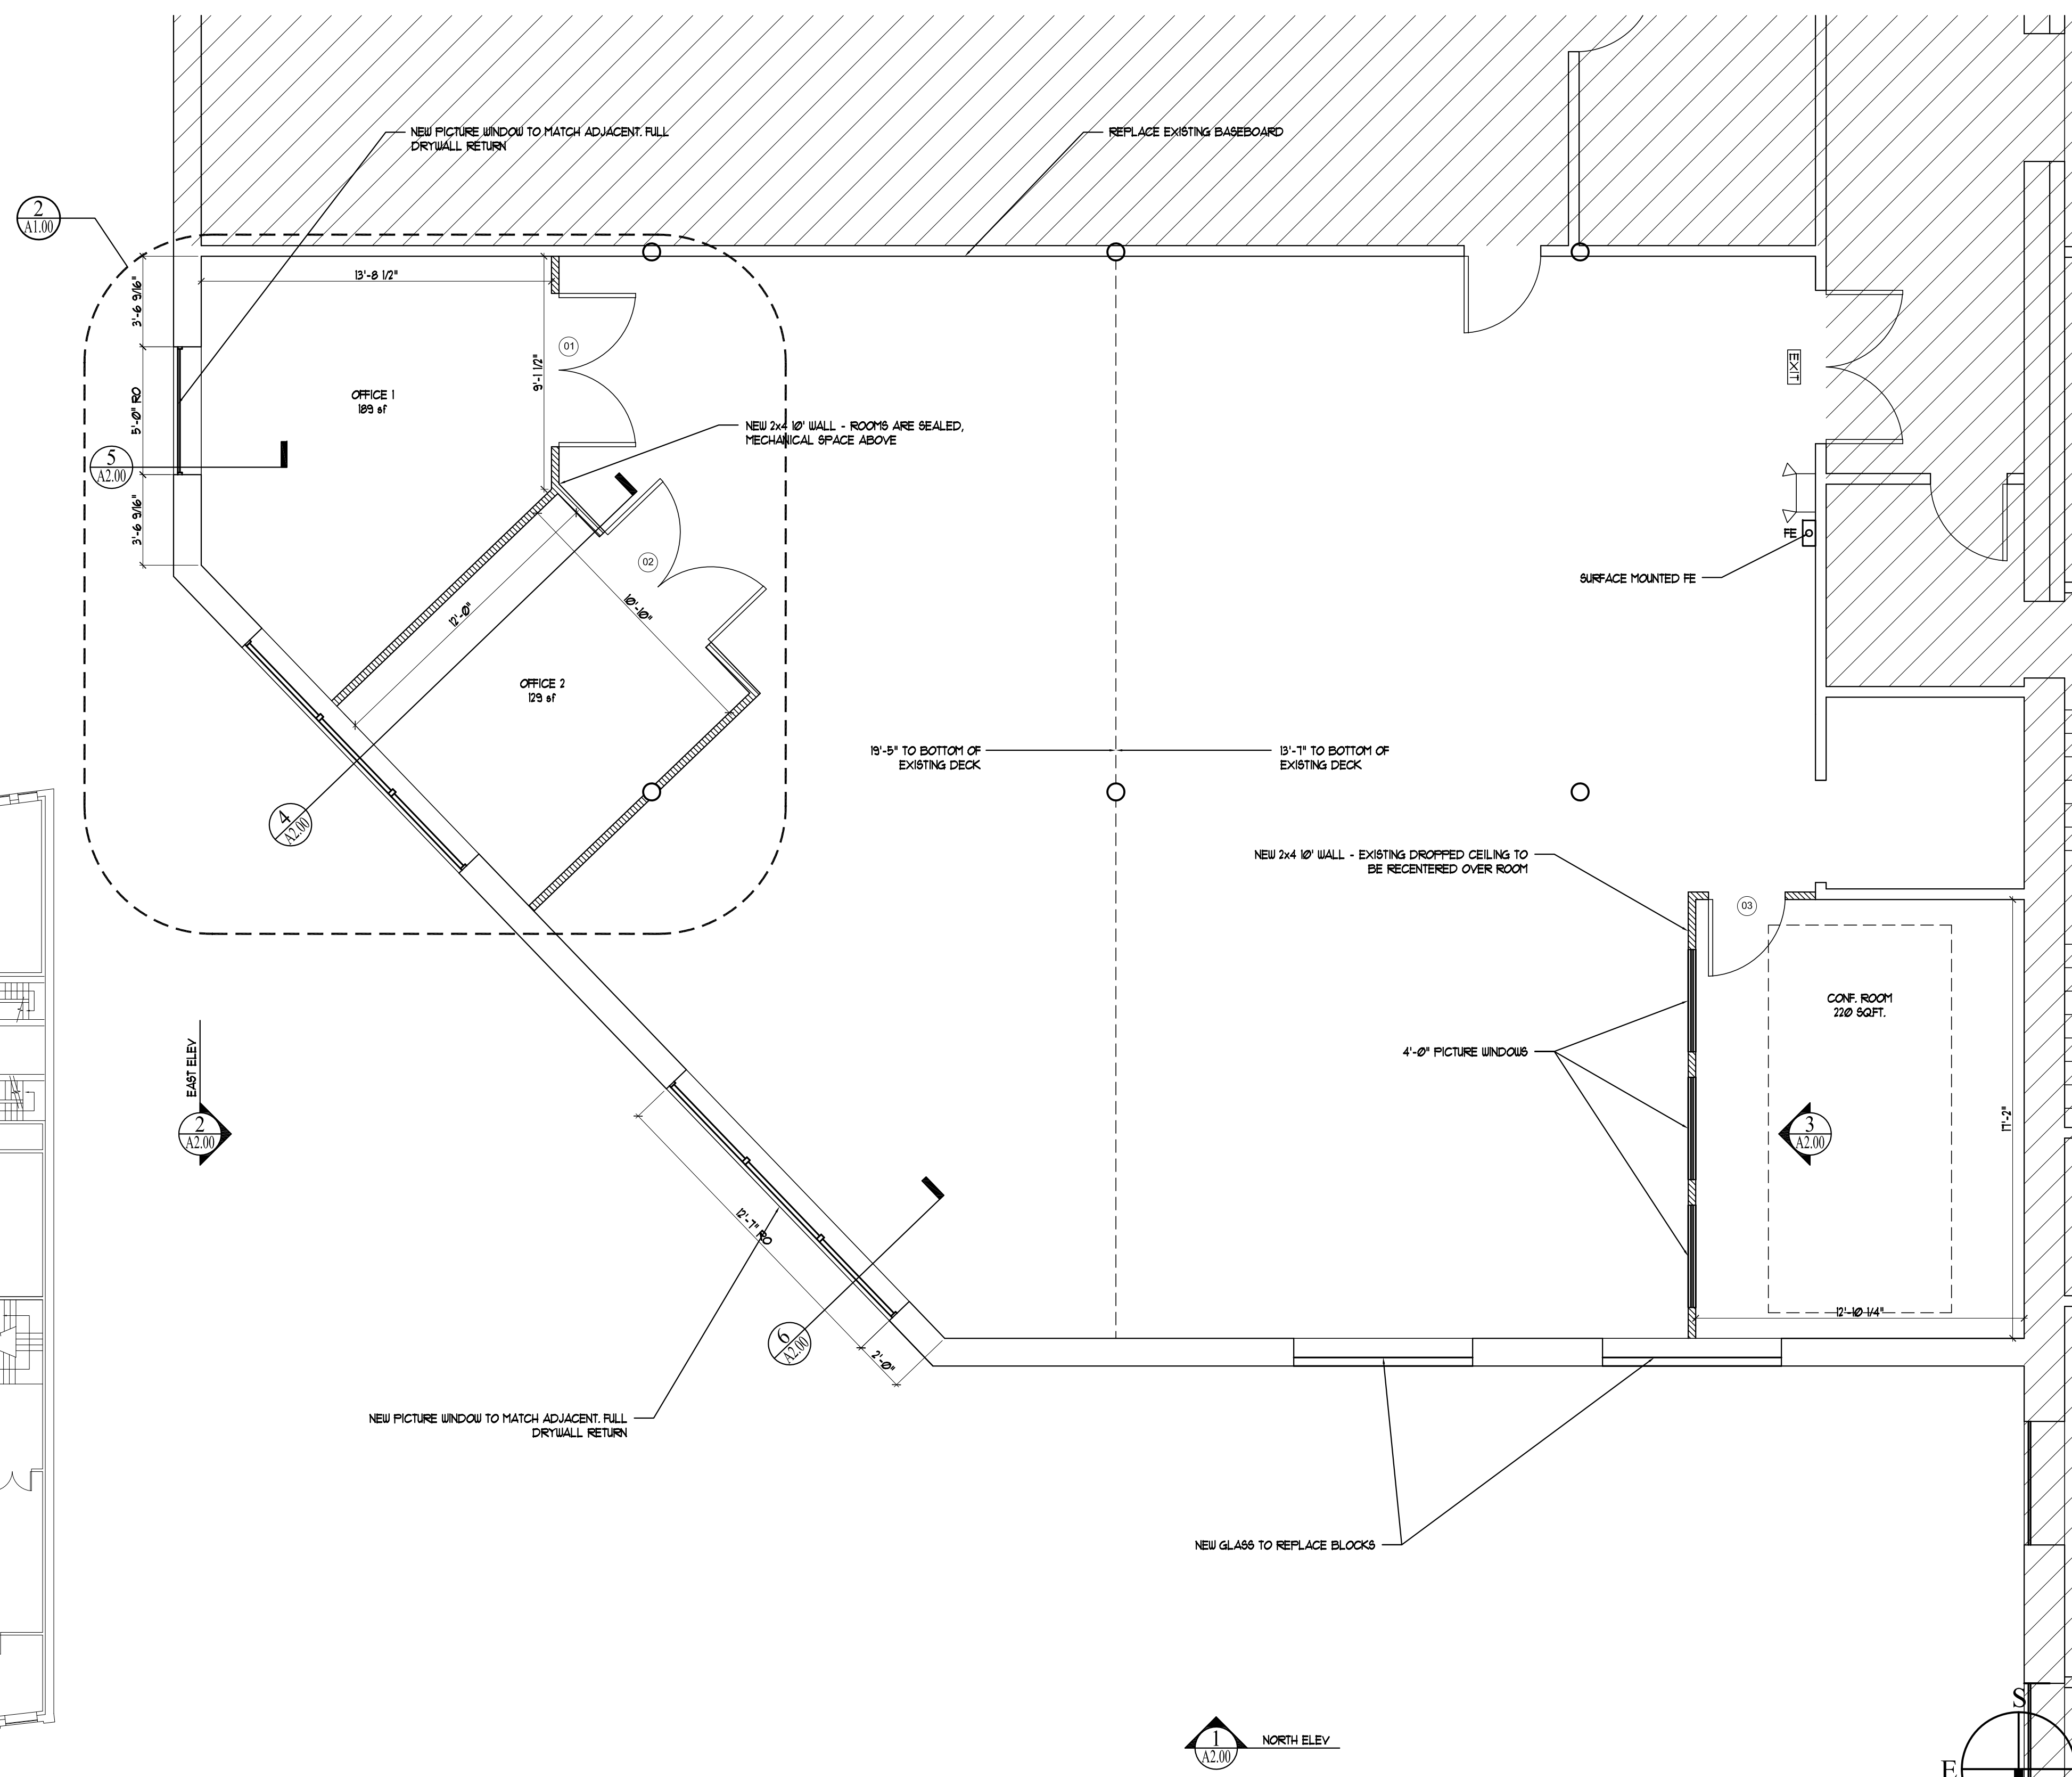

1 | FLOOR PLAN
 SCALE: 1/4"=1'-0"

