




WATER SOURCE HEAT PUMP UNIT - HORIZONTAL
NO SCALE

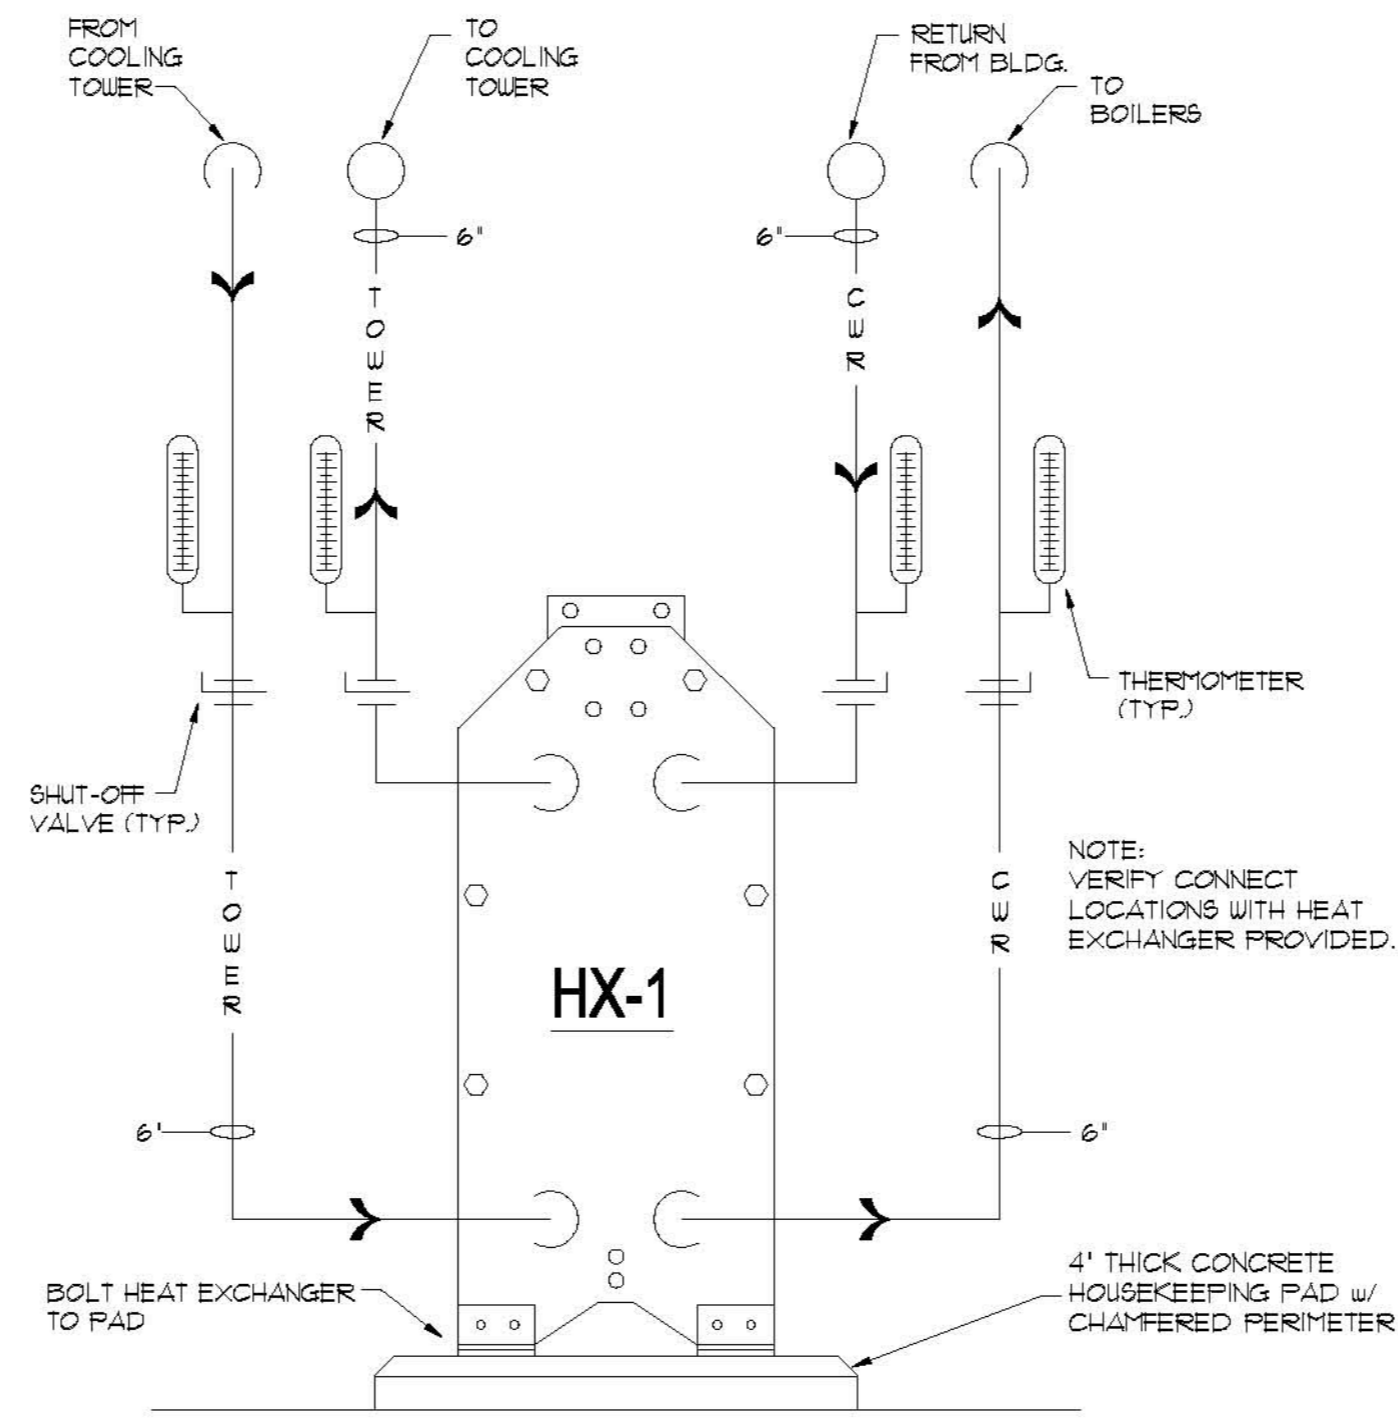


HEAT EXCHANGER DETAIL
NO SCALE

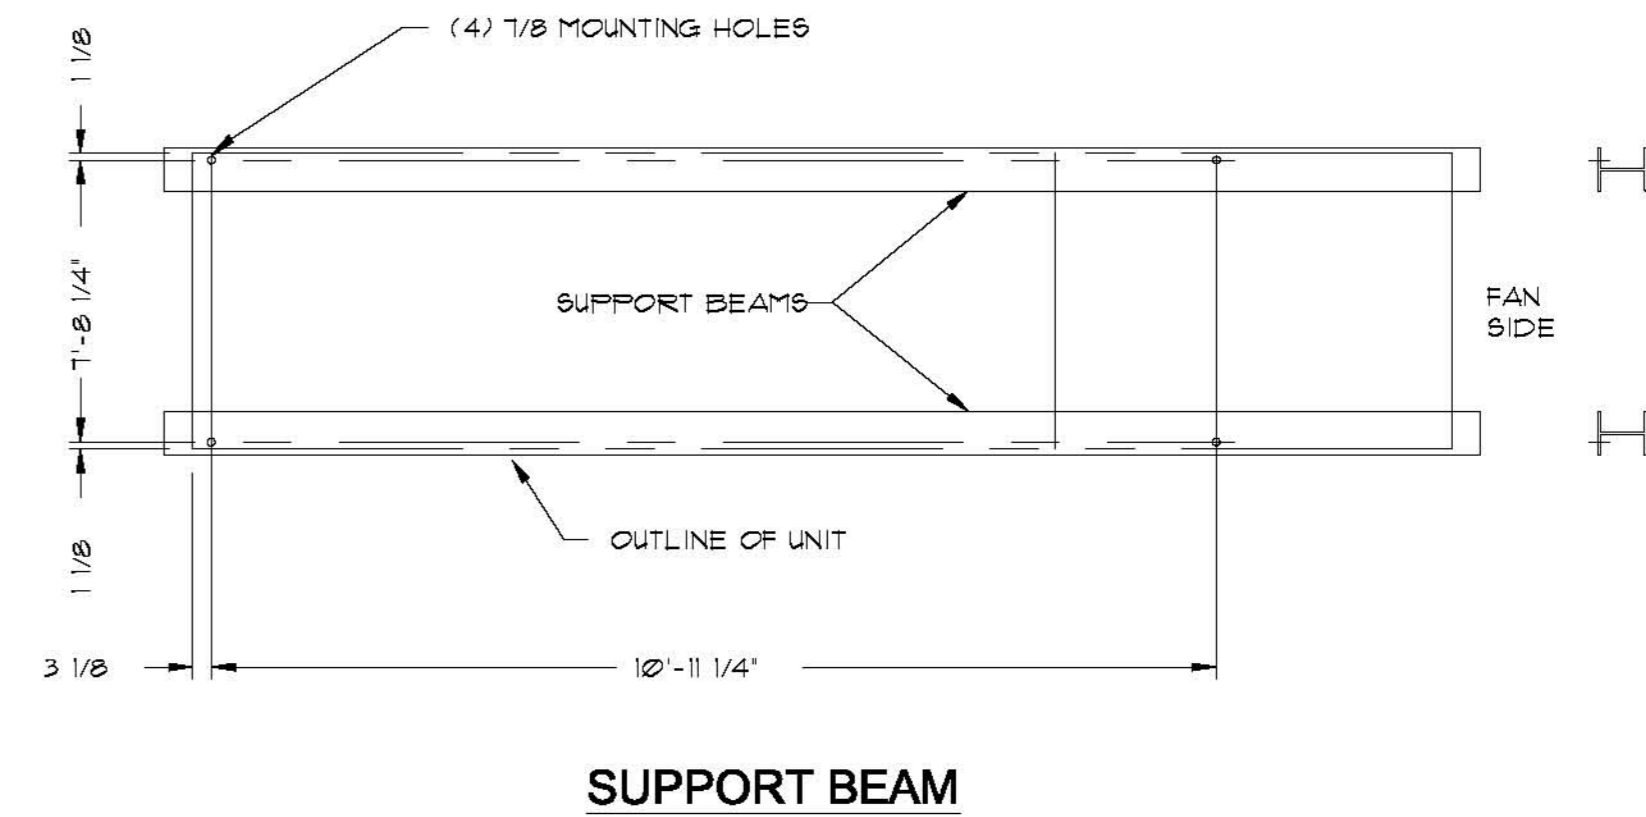

COOLING TOWER DETAIL
NO SCALE

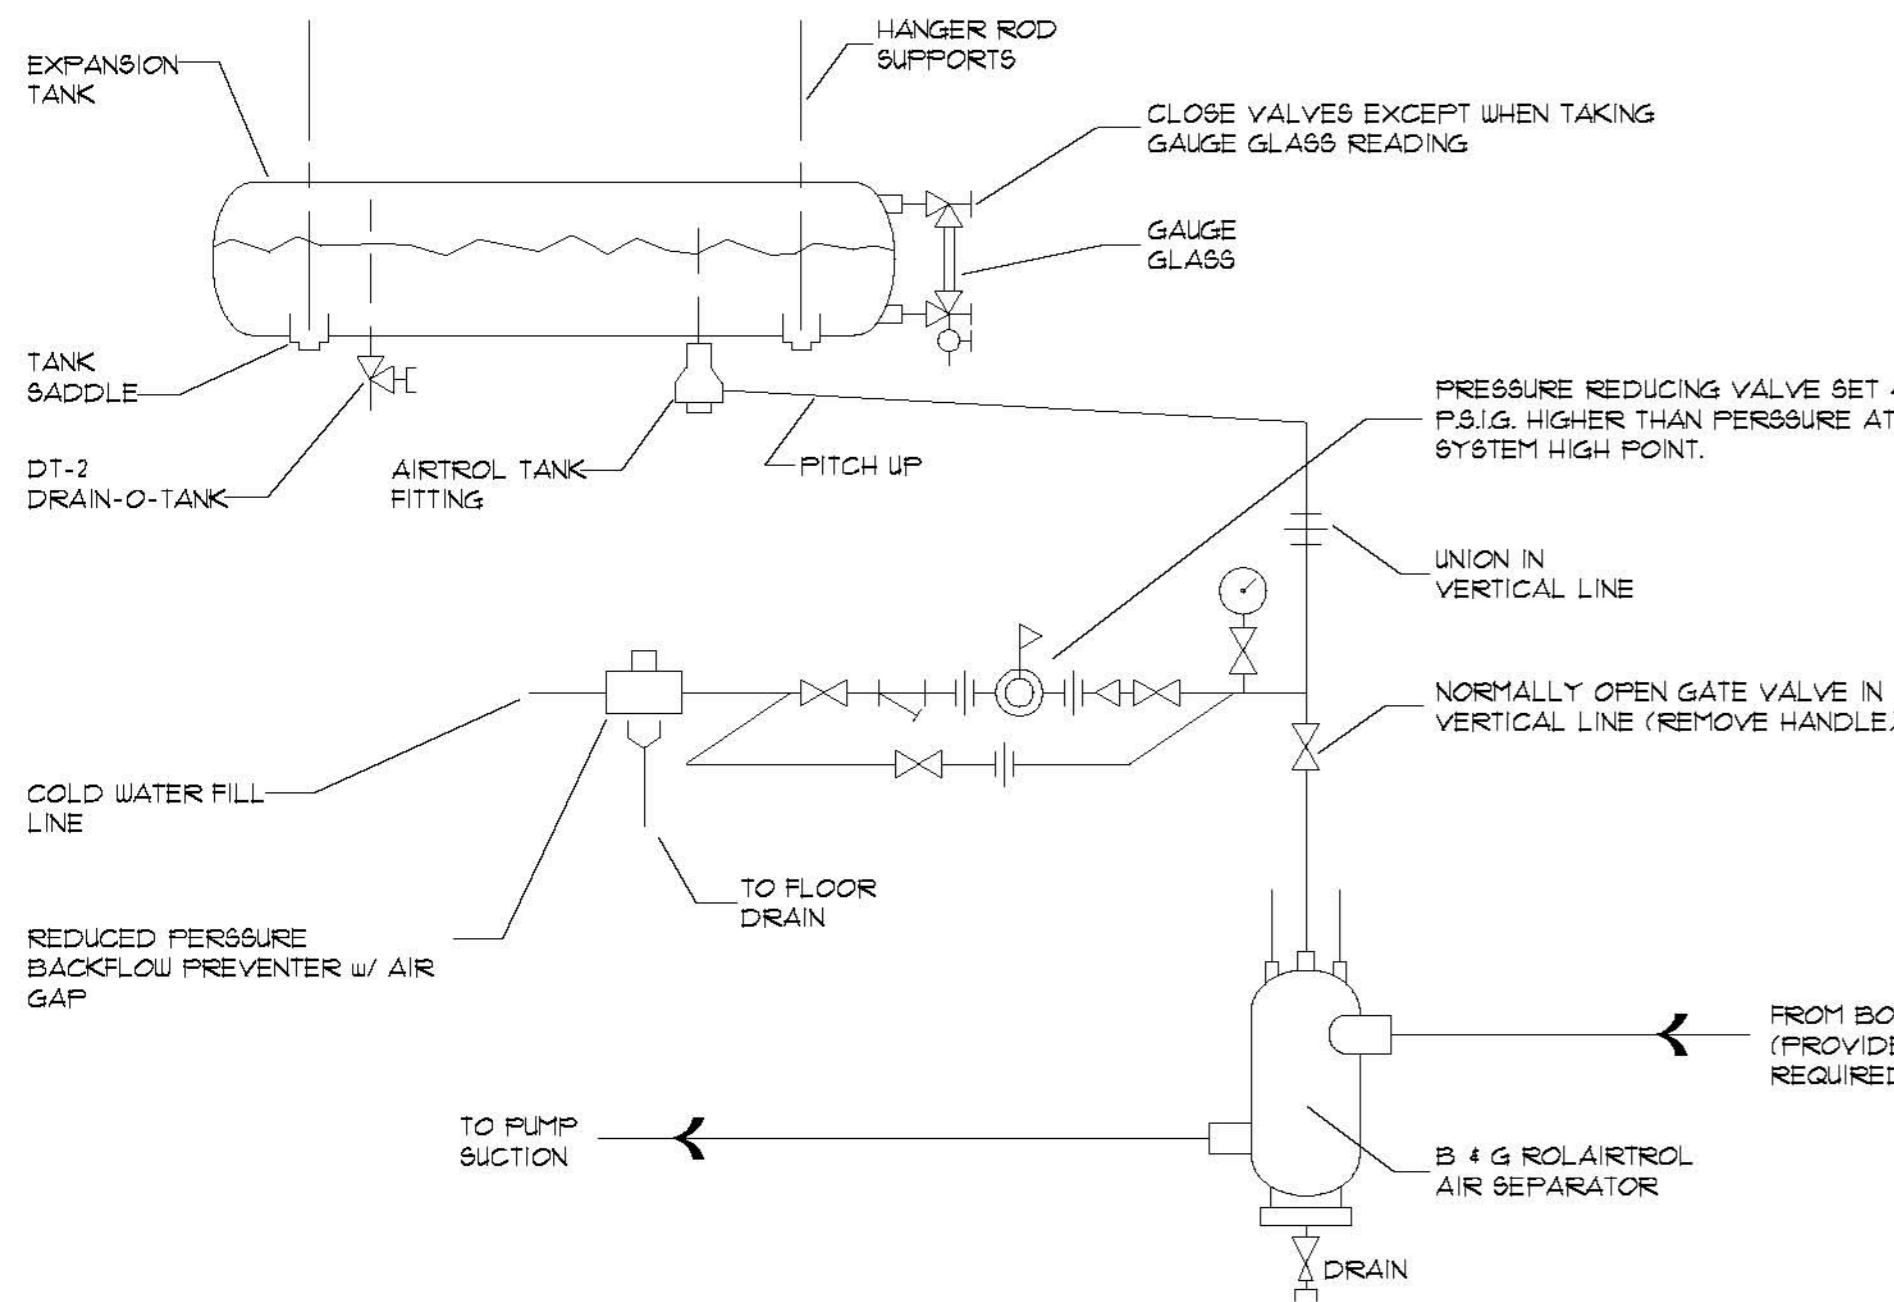


TYPICAL EXPANSION TANK CONNECTIONS DETAIL
NO SCALE

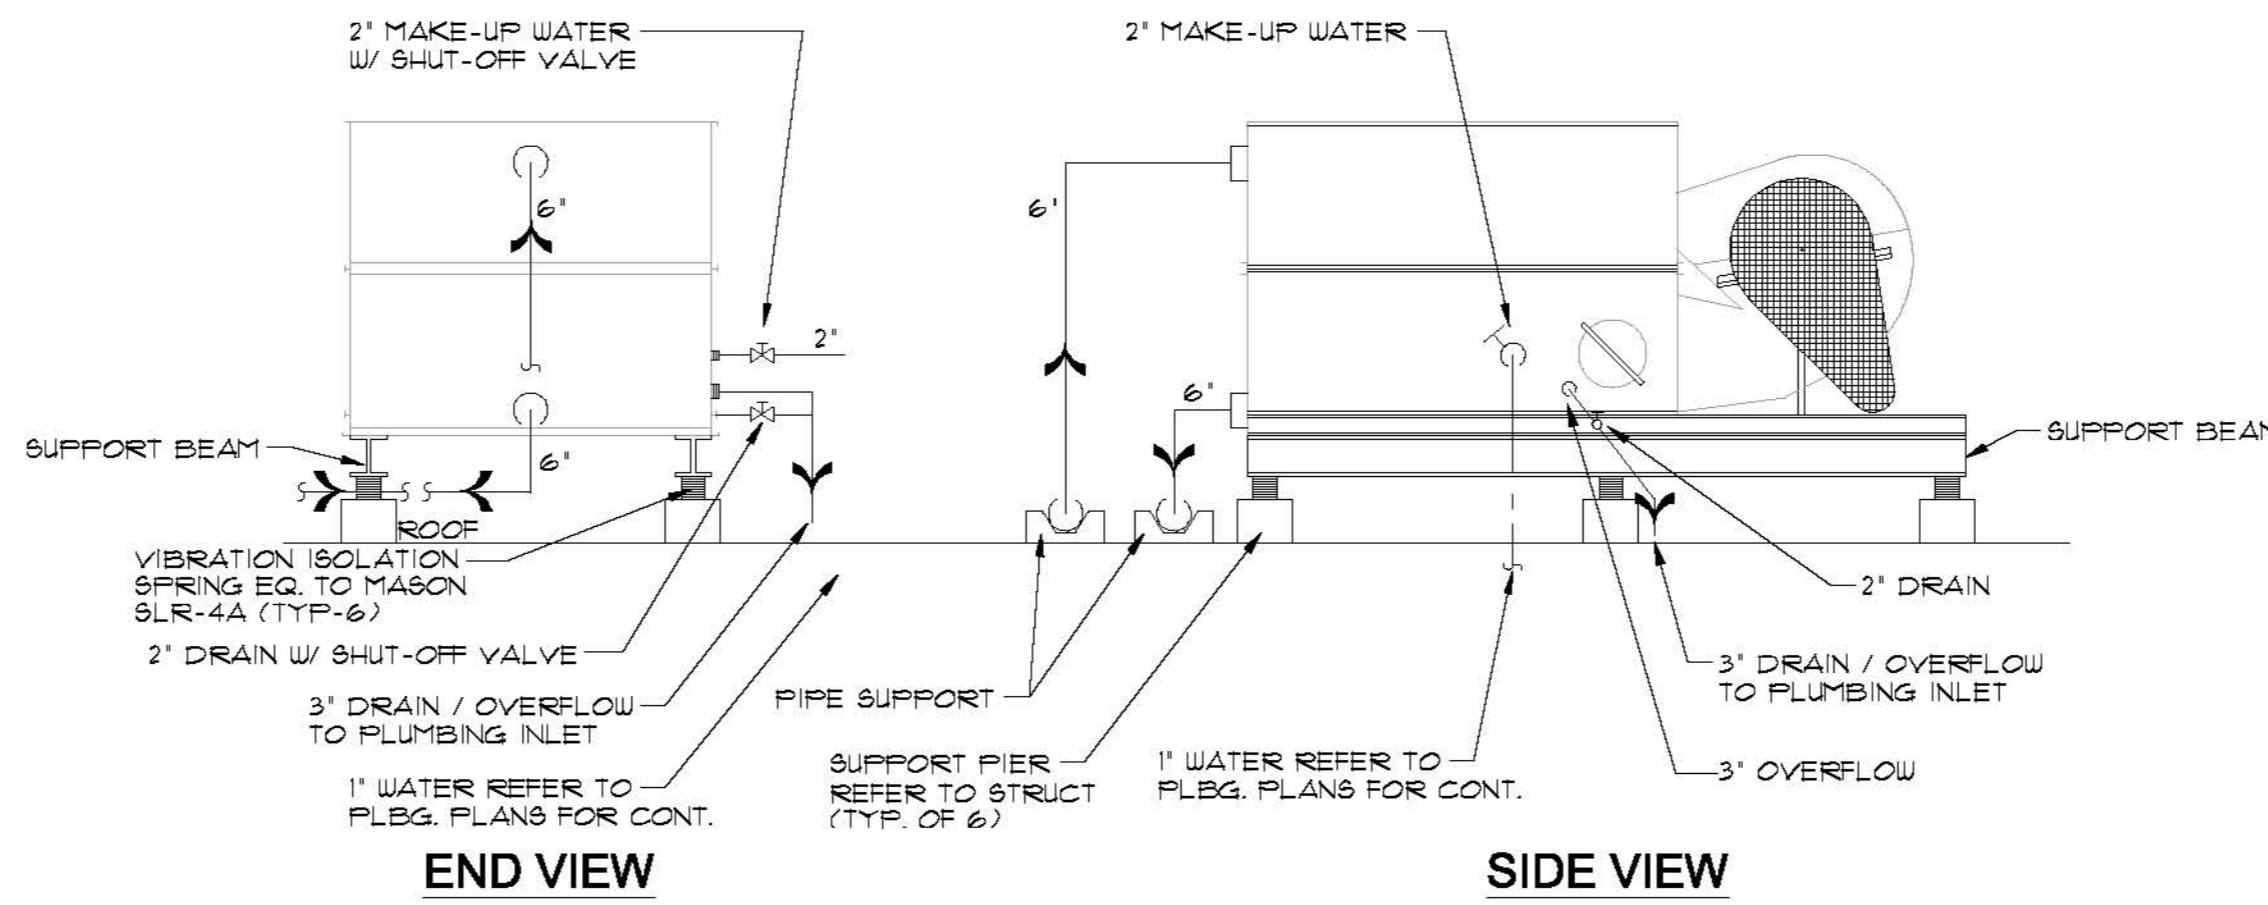


END VIEW

SIDE VIEW


- NOTES:
1. ALL PIPING TO THE COOLING TOWER SHALL BE INSULATED, HEAT TRACED AND PROTECTED W/ ALUMINUM JACKET.
 2. INSULATION SHALL BE FIBERGLASS 1-1/2\"/>

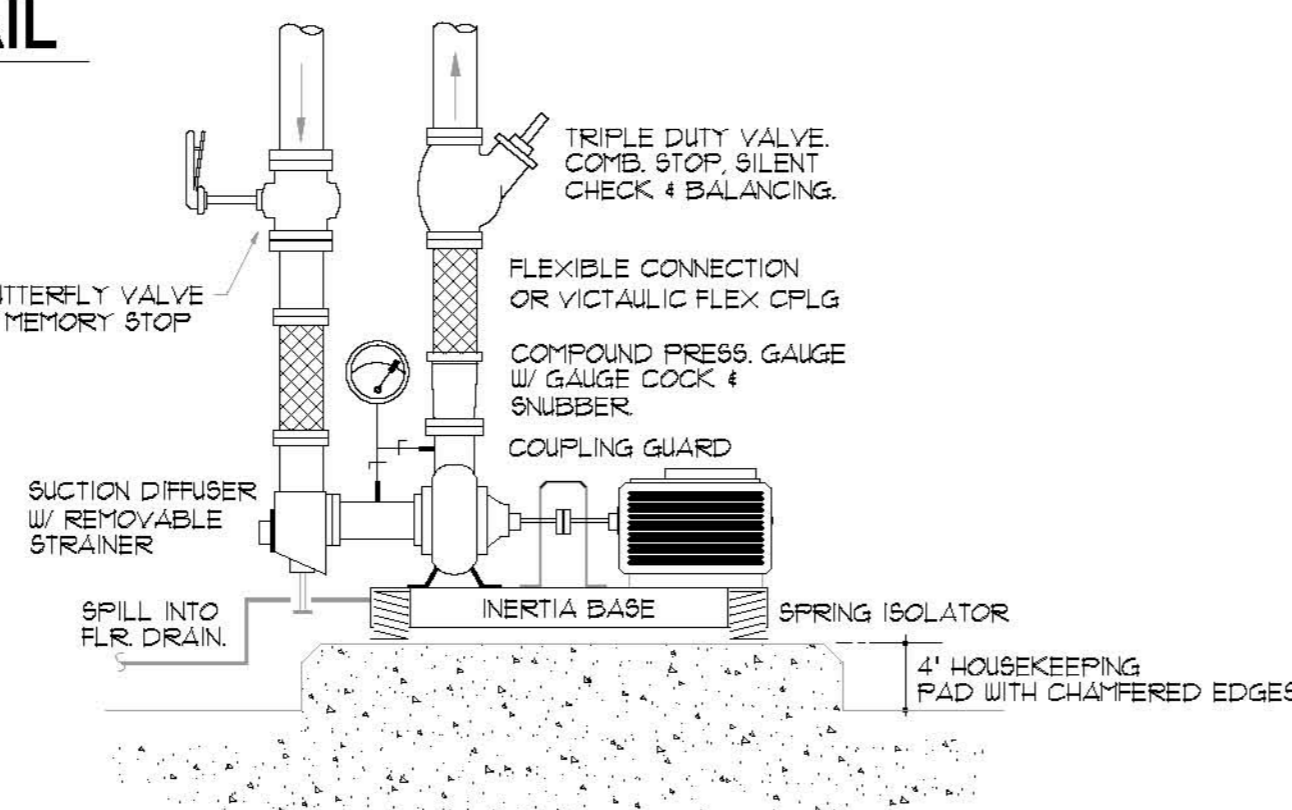

BASE MOUNTED PUMP DETAIL
NO SCALE

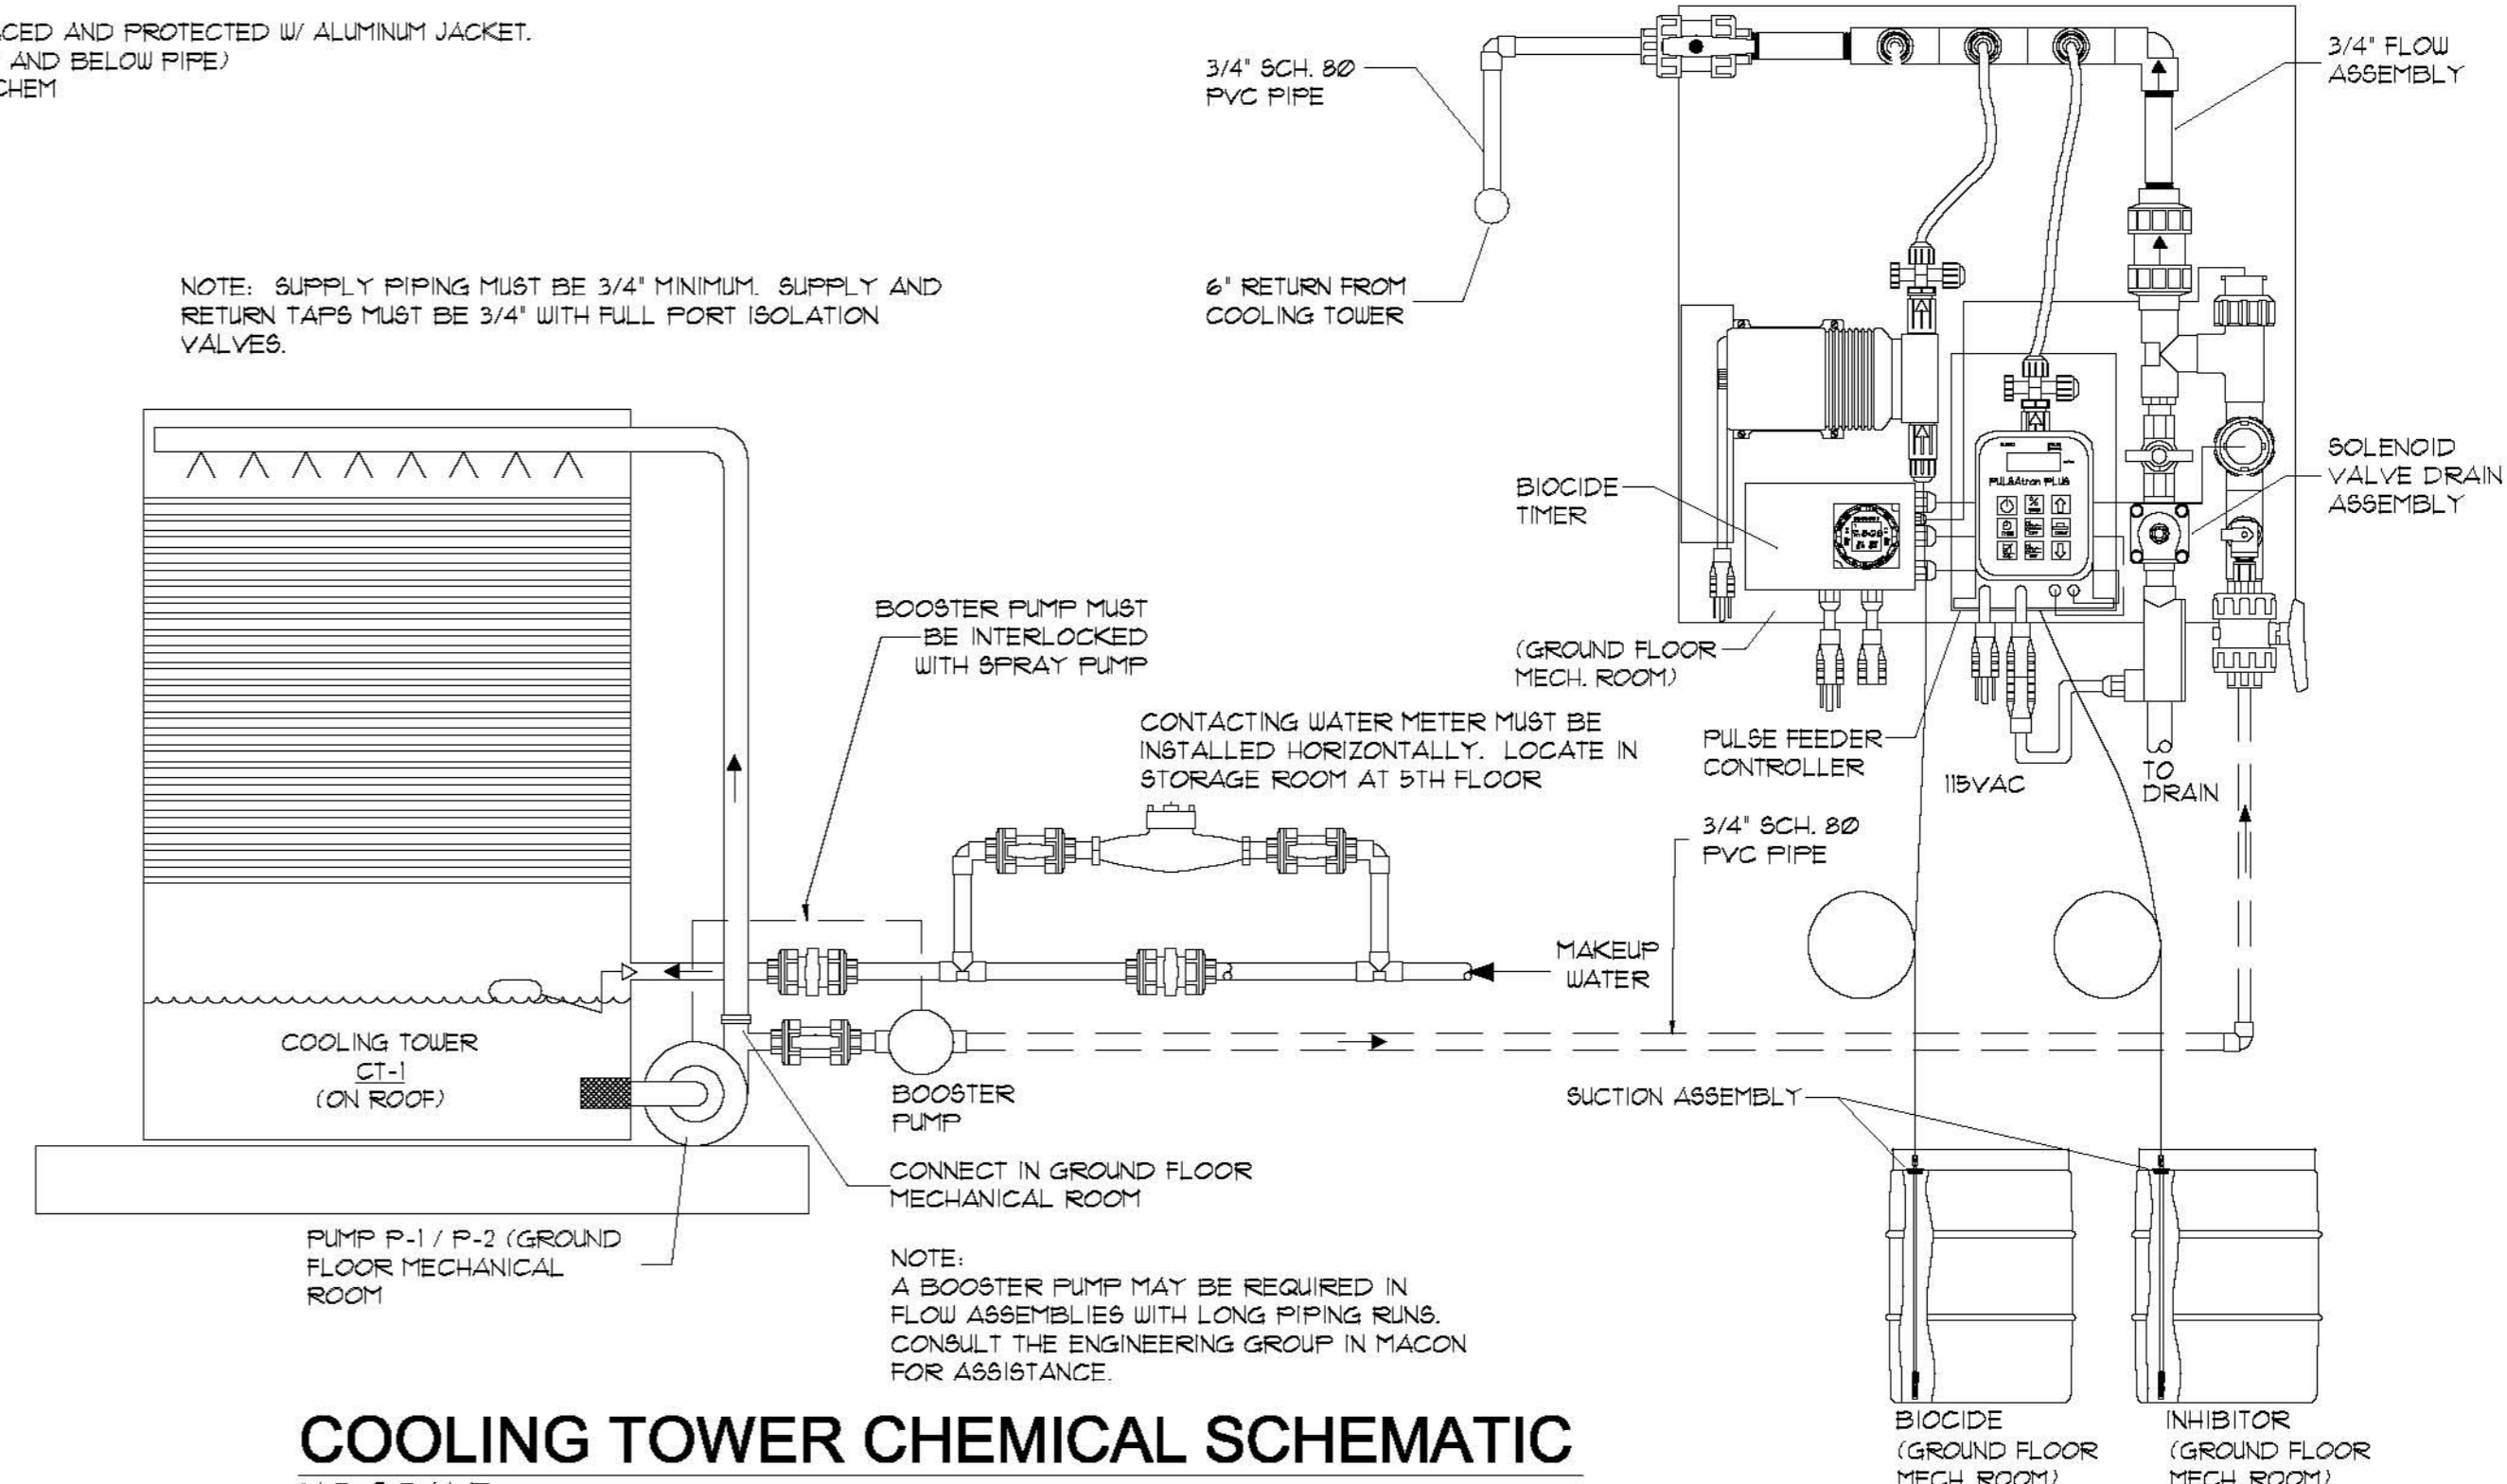

COOLING TOWER CHEMICAL SCHEMATIC
NO SCALE

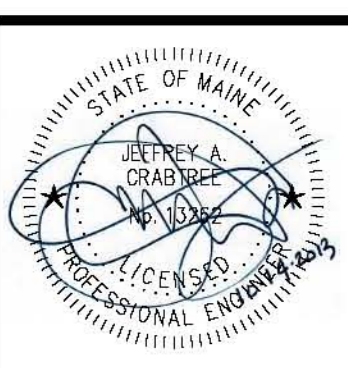

Prepared For:
119 DEVELOPMENT LLC
Mechanical Engineer:
Crabtree Engineering
278 Amelia Cove
Collierville, Tennessee 38017
jce98@bellsouth.net

Architect:
ARCHETYPE architects
48 Union Wharf Portland, Maine 04101
(207) 772-6022 Fax (207) 772-4056

Project:
PRESS HOTEL
390 CONGRESS STREET
PORTLAND, MAINE

Revisions:
1 | 13-07-01 | 30% Marriott Submission
2 | 13-09-09 | 60% Marriott Sub. & Pric.
3 | 13-10-14 | Issue for Bid & Marriott Revw

Date:
08 OCT 13

Scale:
1/8" = 1'-0"

HVAC DETAILS

M9.02