


1 | FOURTH FLOOR PLAN - WATER
SCALE: 1/8"=1'-0"

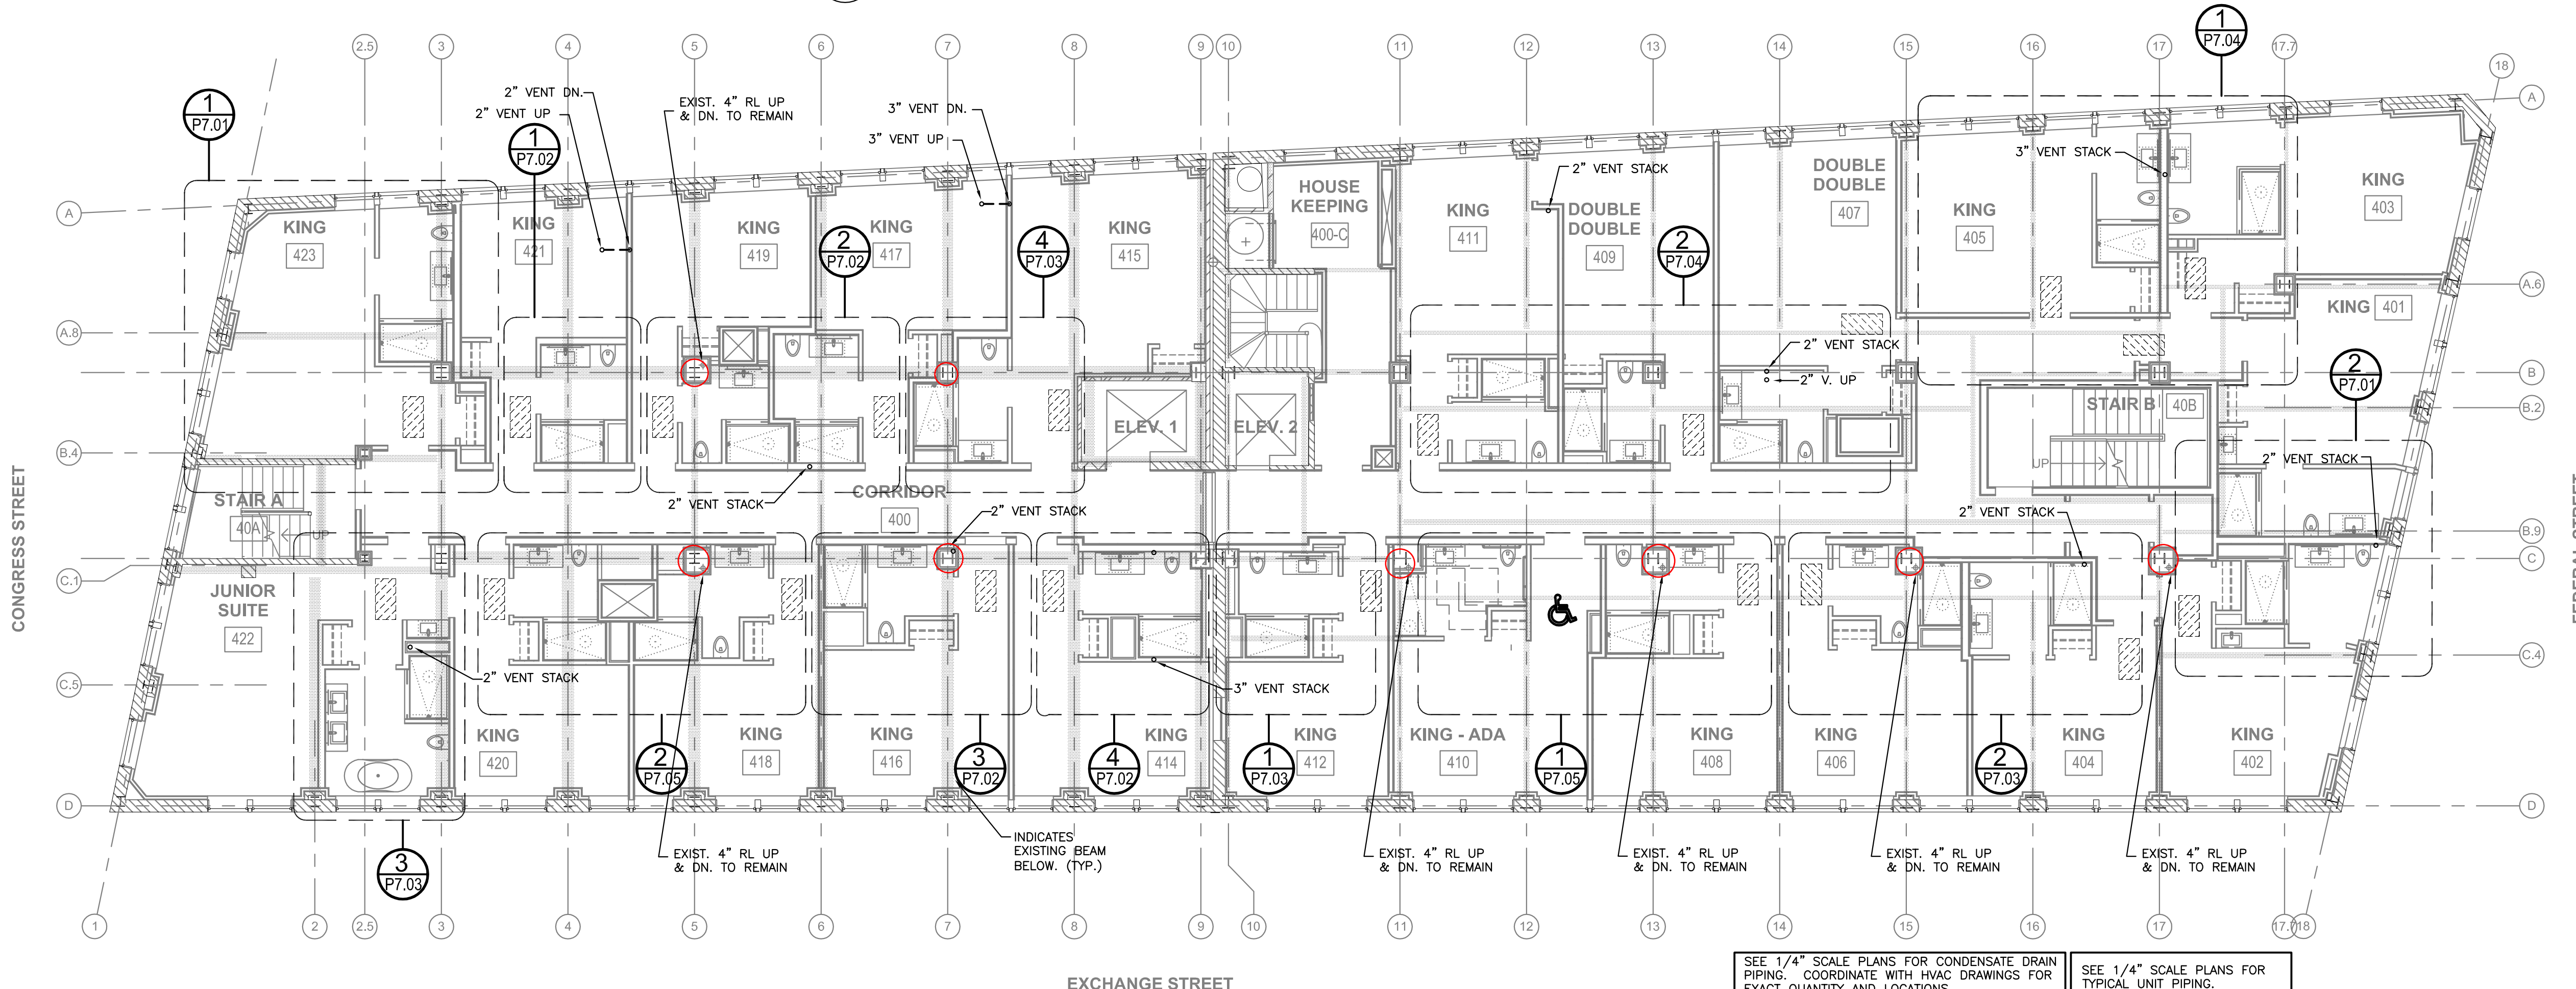


2 | FOURTH FLOOR PLAN - WASTE, VENT AND RAIN LEADER
SCALE: 1/8"=1'-0"

SEE 1/4" SCALE PLANS FOR TYPICAL UNIT PIPING.

SEE 1/4" SCALE PLANS FOR CONDENSATE DRAIN PIPING. COORDINATE WITH HVAC DRAWINGS FOR EXACT QUANTITY AND LOCATIONS.

SEE 1/4" SCALE PLANS FOR TYPICAL UNIT PIPING.

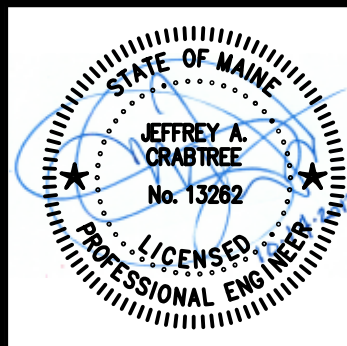

Prepared For:
119 Development, LLC
P.O. BOX 7468
Portland, ME 04112

Consultant:
CRABTREE ENGINEERING
278 AMELIA COVE
COLLIERVILLE, TN 38017
PLUMBING: bob@crabtreeeng.com

Architect:
ARCHETYPE architects
48 Union Wharf Portland, Maine 04101
(207) 772-6022 Fax (207) 772-4056

Project:
PRESS HOTEL
390 CONGRESS STREET
PORTLAND, ME 04101

Revisions:
1 | 13-07-01 30% Marriott Submission
2 | 13-09-09 60% Marriott Sub. & Pric.
3 | 13-10-14 Issue for Bid & Marriott Rev

Date:
13 October 2013
Scale:
1/8" = 1'-0"

FOURTH FLOOR PLANS - PLUMBING
P4.00