



REFER TO DRAWINGS AND SCHEDULES BY KNLD AND STONEHILL TAYLOR FOR ADDITIONAL LIGHTING INFORMATIONS

REFER TO SHEET E4.02 AND E4.03 FOR LIGHTING CONTROL PANEL SCHEDULES AND DIAGRAMS

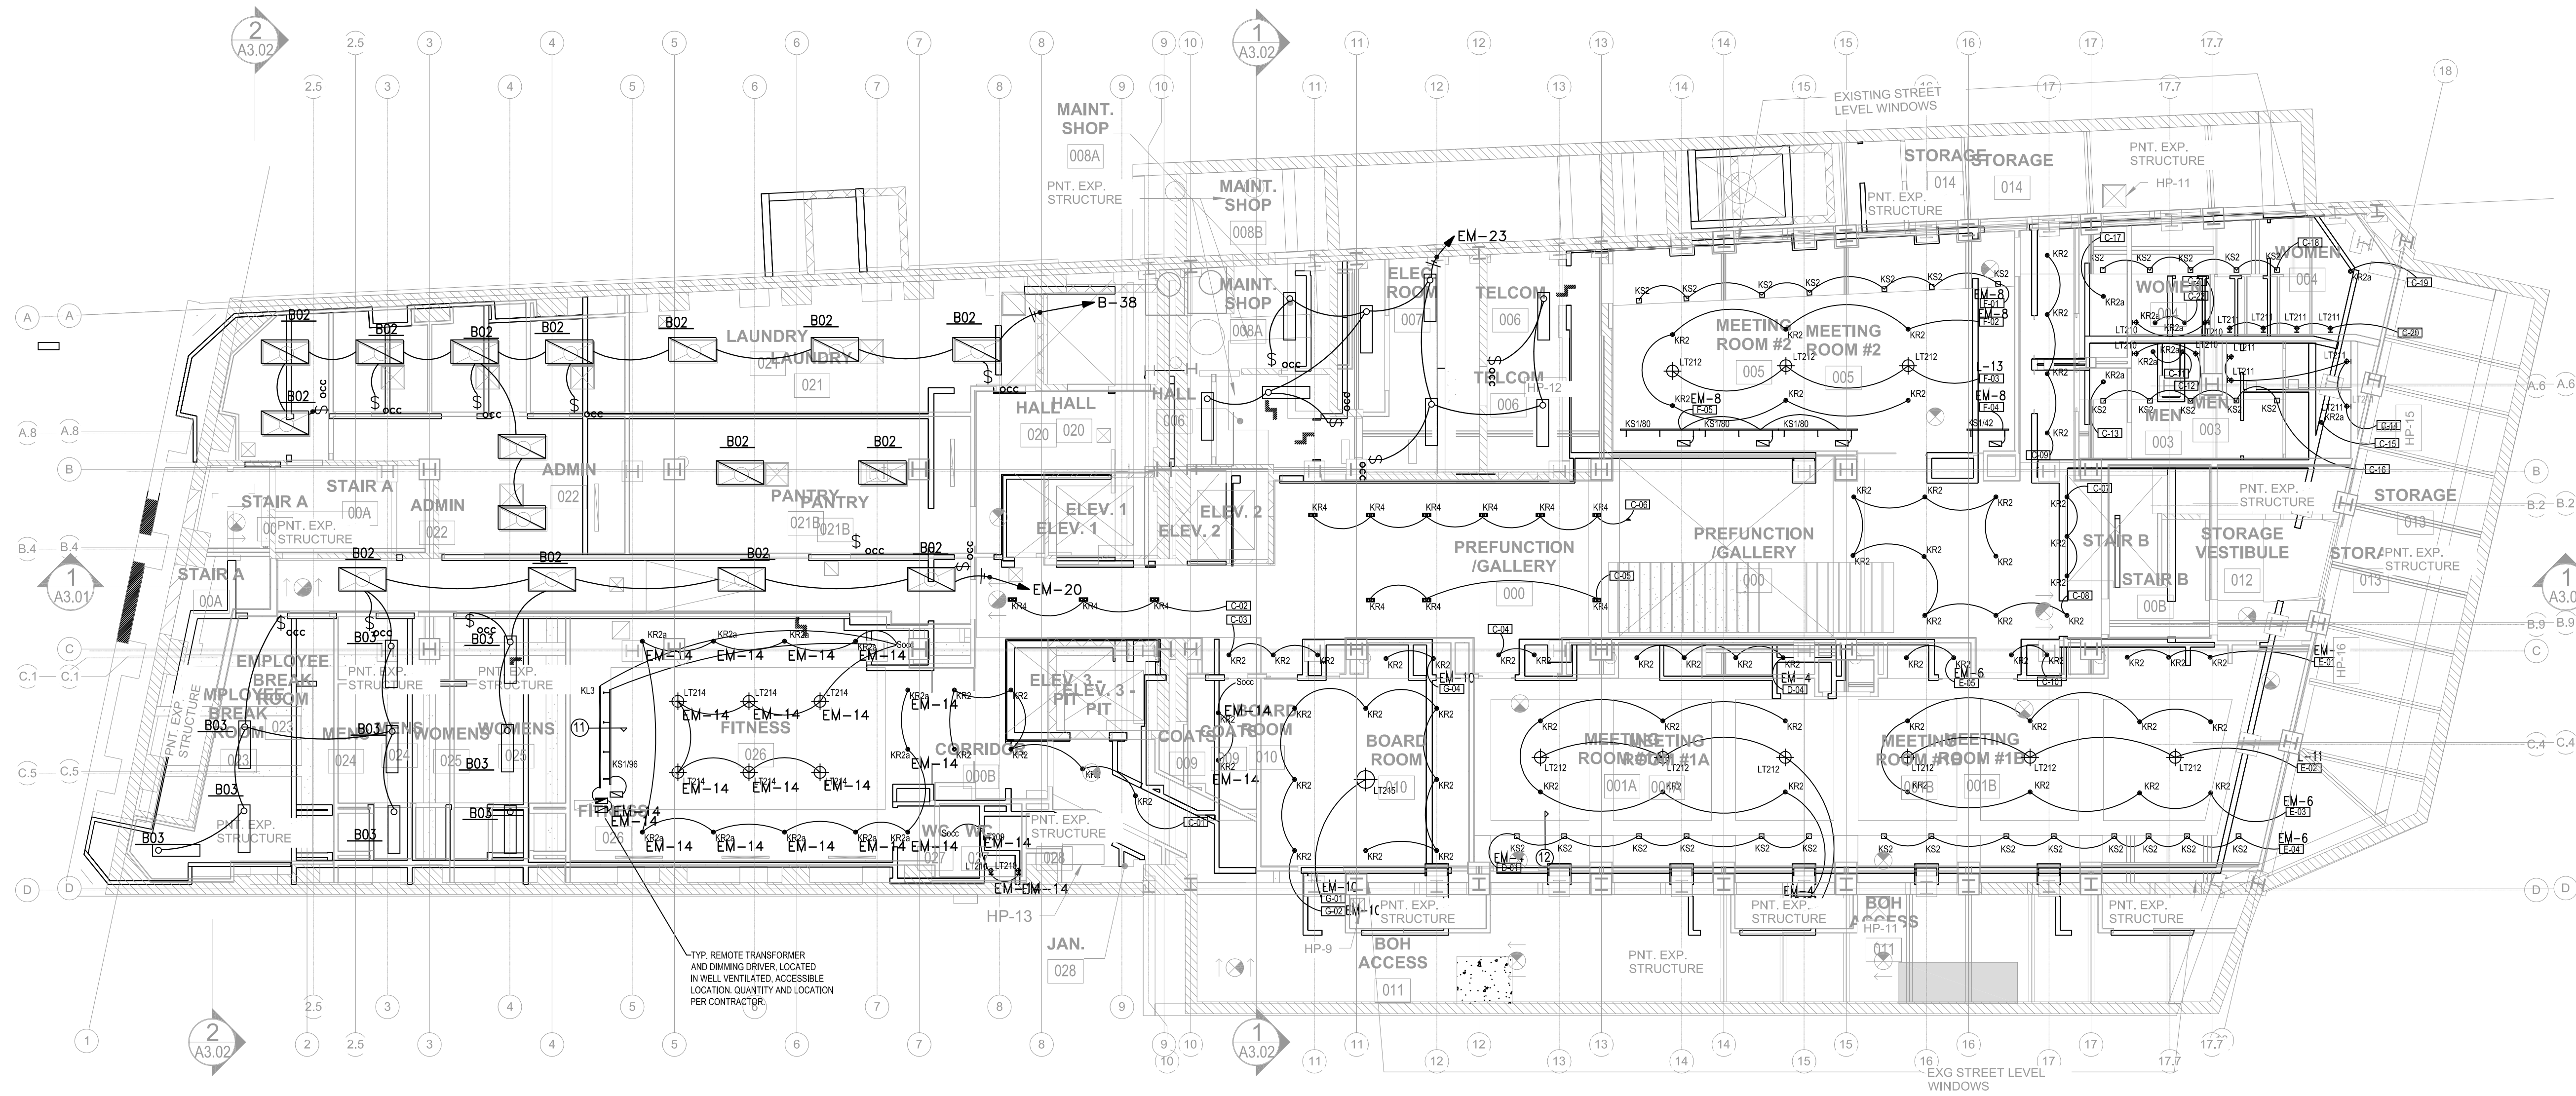

TYP. REMOTE TRANSFORMER AND DIMMING DRIVER LOCATED IN WELL VENTILATED, ACCESSIBLE LOCATION. QUANTITY AND LOCATION PER CONTRACTOR.

1 LOWER LEVEL LIGHTING PLAN
SCALE: 1/8"=1'-0"

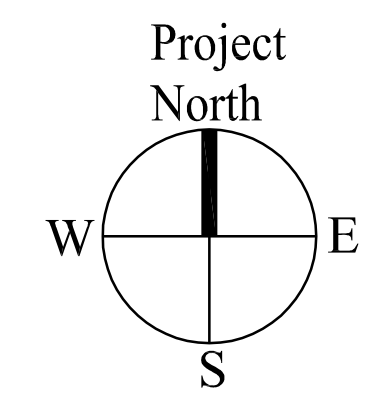

Prepared For:
119 Development, LLC
P.O. Box 7468
Portland, ME 04112

Consultant:
CHS ENGINEERING
CONSTANCE HICKEY SCOTT, PE
7846 WOOD OAK COVE
CORDOVA, TN 38016
TEL: (901) 839-5300
EMAIL: chscott@chsengineering.com

Architect:
ARCHETYPE architects
48 Union Wharf Portland, Maine 04101
(207) 772-6022 Fax (207) 772-4056

Project:
Press Hotel
119 Exchange St.
Portland, ME 04101

Revisions:
ISSUED FOR BID 10/14/13

Scale:
LOWER LEVEL LIGHTING PLAN

Date:
E1.02A