
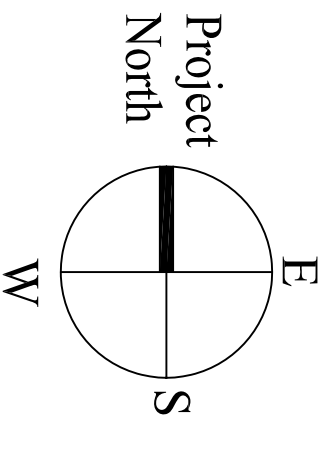


1 SEVENTH FLOOR FIRE ALARM PLAN  
SCALE: 1/8"=1'-0"

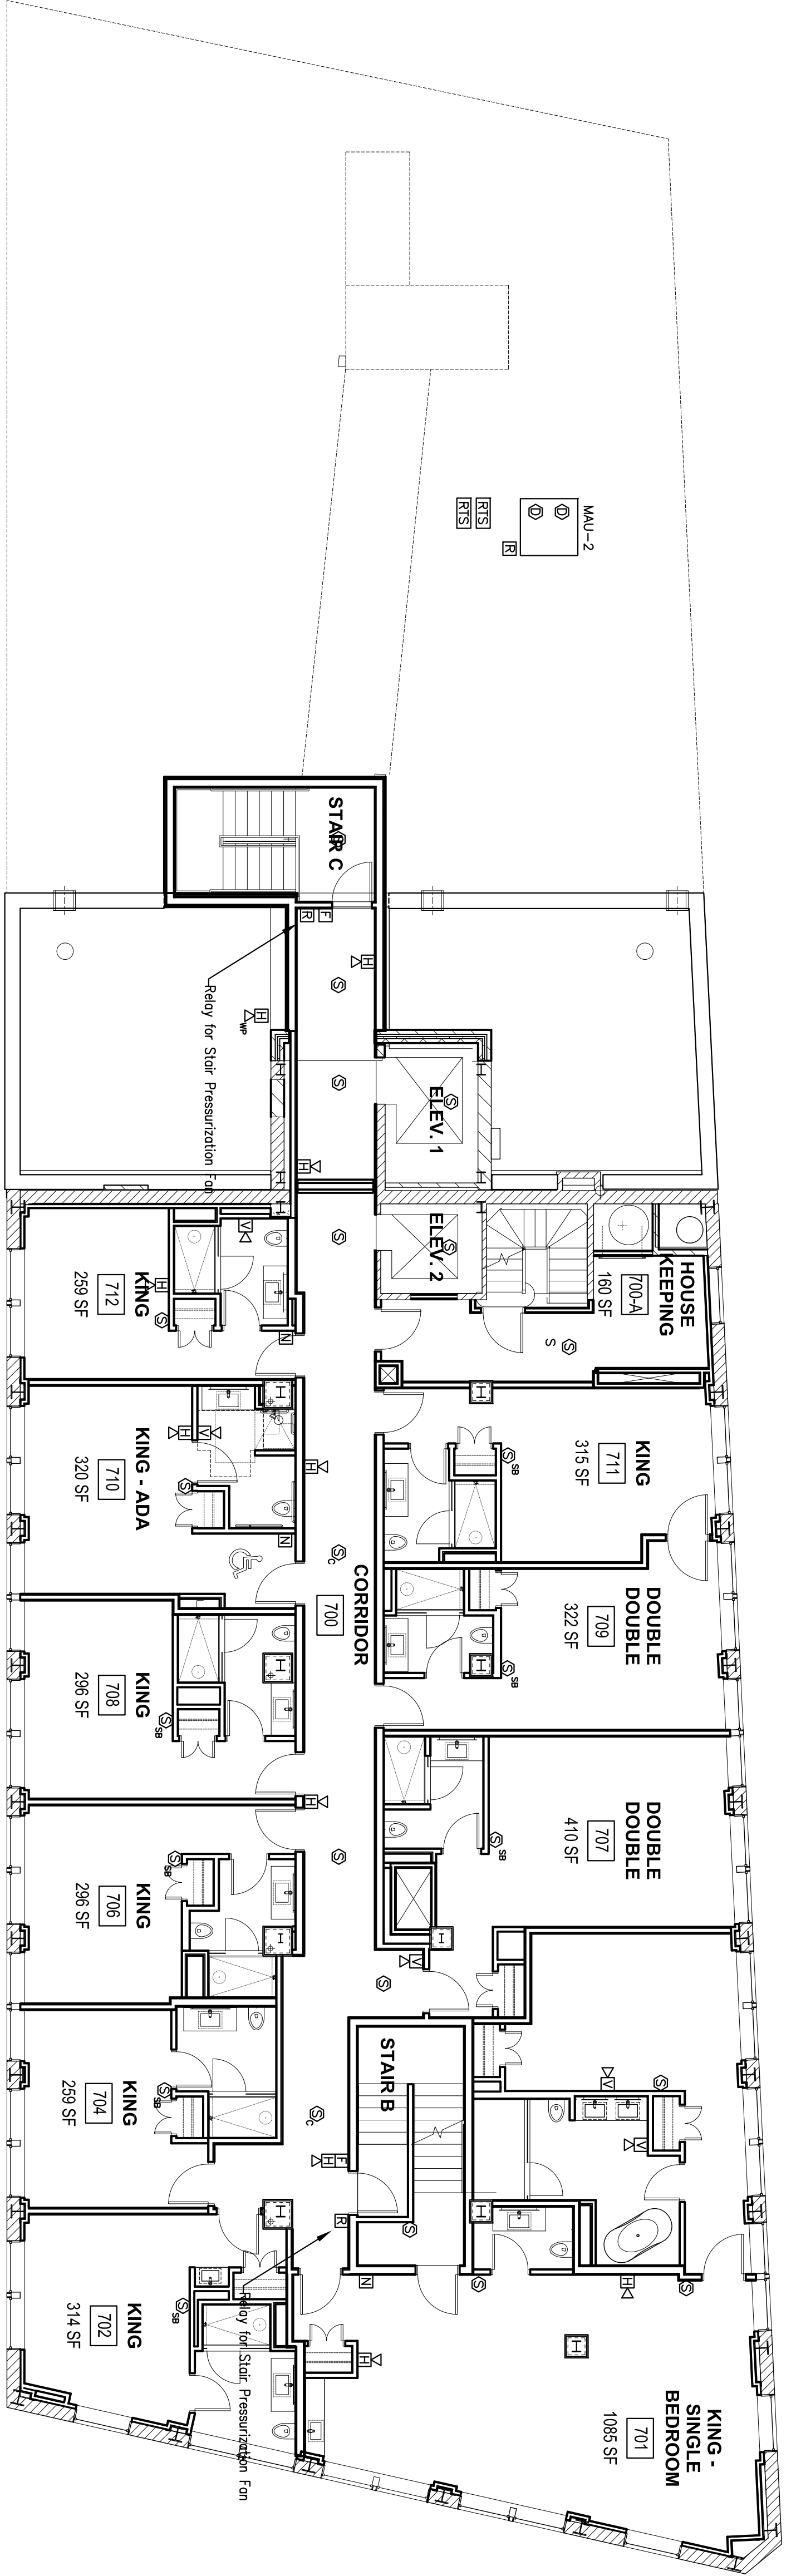

<b>FA1.09</b>	Date: 08 OCT 13	Scale:	Revisions:	<b>Project:</b> <b>PRESS HOTEL</b> 390 CONGRESS STREET PORTLAND, ME 04101	<b>Architect:</b> <b>ARCHETYPE</b> Architects 48 Union Wharf Portland, Maine 04101 (207) 772-6022 Fax (207) 772-4056	<b>Consultant:</b>	<b>Prepared For:</b> 119 Development, LLC
	<b>SEVENTH FLOOR FIRE ALARM PLAN</b>						