

Prepared For:  
**119 Development, LLC**

Consultant:  
 Crabtree Engineering  
 278 Amelia Cove  
 Collierville, Tennessee 38017  
 majidhamzadeh@yahoo.com


Architect:  
**ARCHETYPE** Architects  
 48 Union Wharf Portland, Maine 04101  
 (207) 772-6022 Fax (207) 772-4056

Project:  
**PRESS HOTEL**  
 390 CONGRESS STREET  
 PORTLAND, ME 04101

Revisions:  
 1 13\_07-01 30% Marriott Submission  
 2 13\_09-09 60% Marriott Sub. & Pric.  
 3 13\_10-14 Issue for Bid & Marriott Revw.

Date: 08 OCT 13  
 Scale: 1/8" = 1'-0"  
**LOWER LEVEL FIRE  
 SPRINKLER PLAN**

**F0.20**

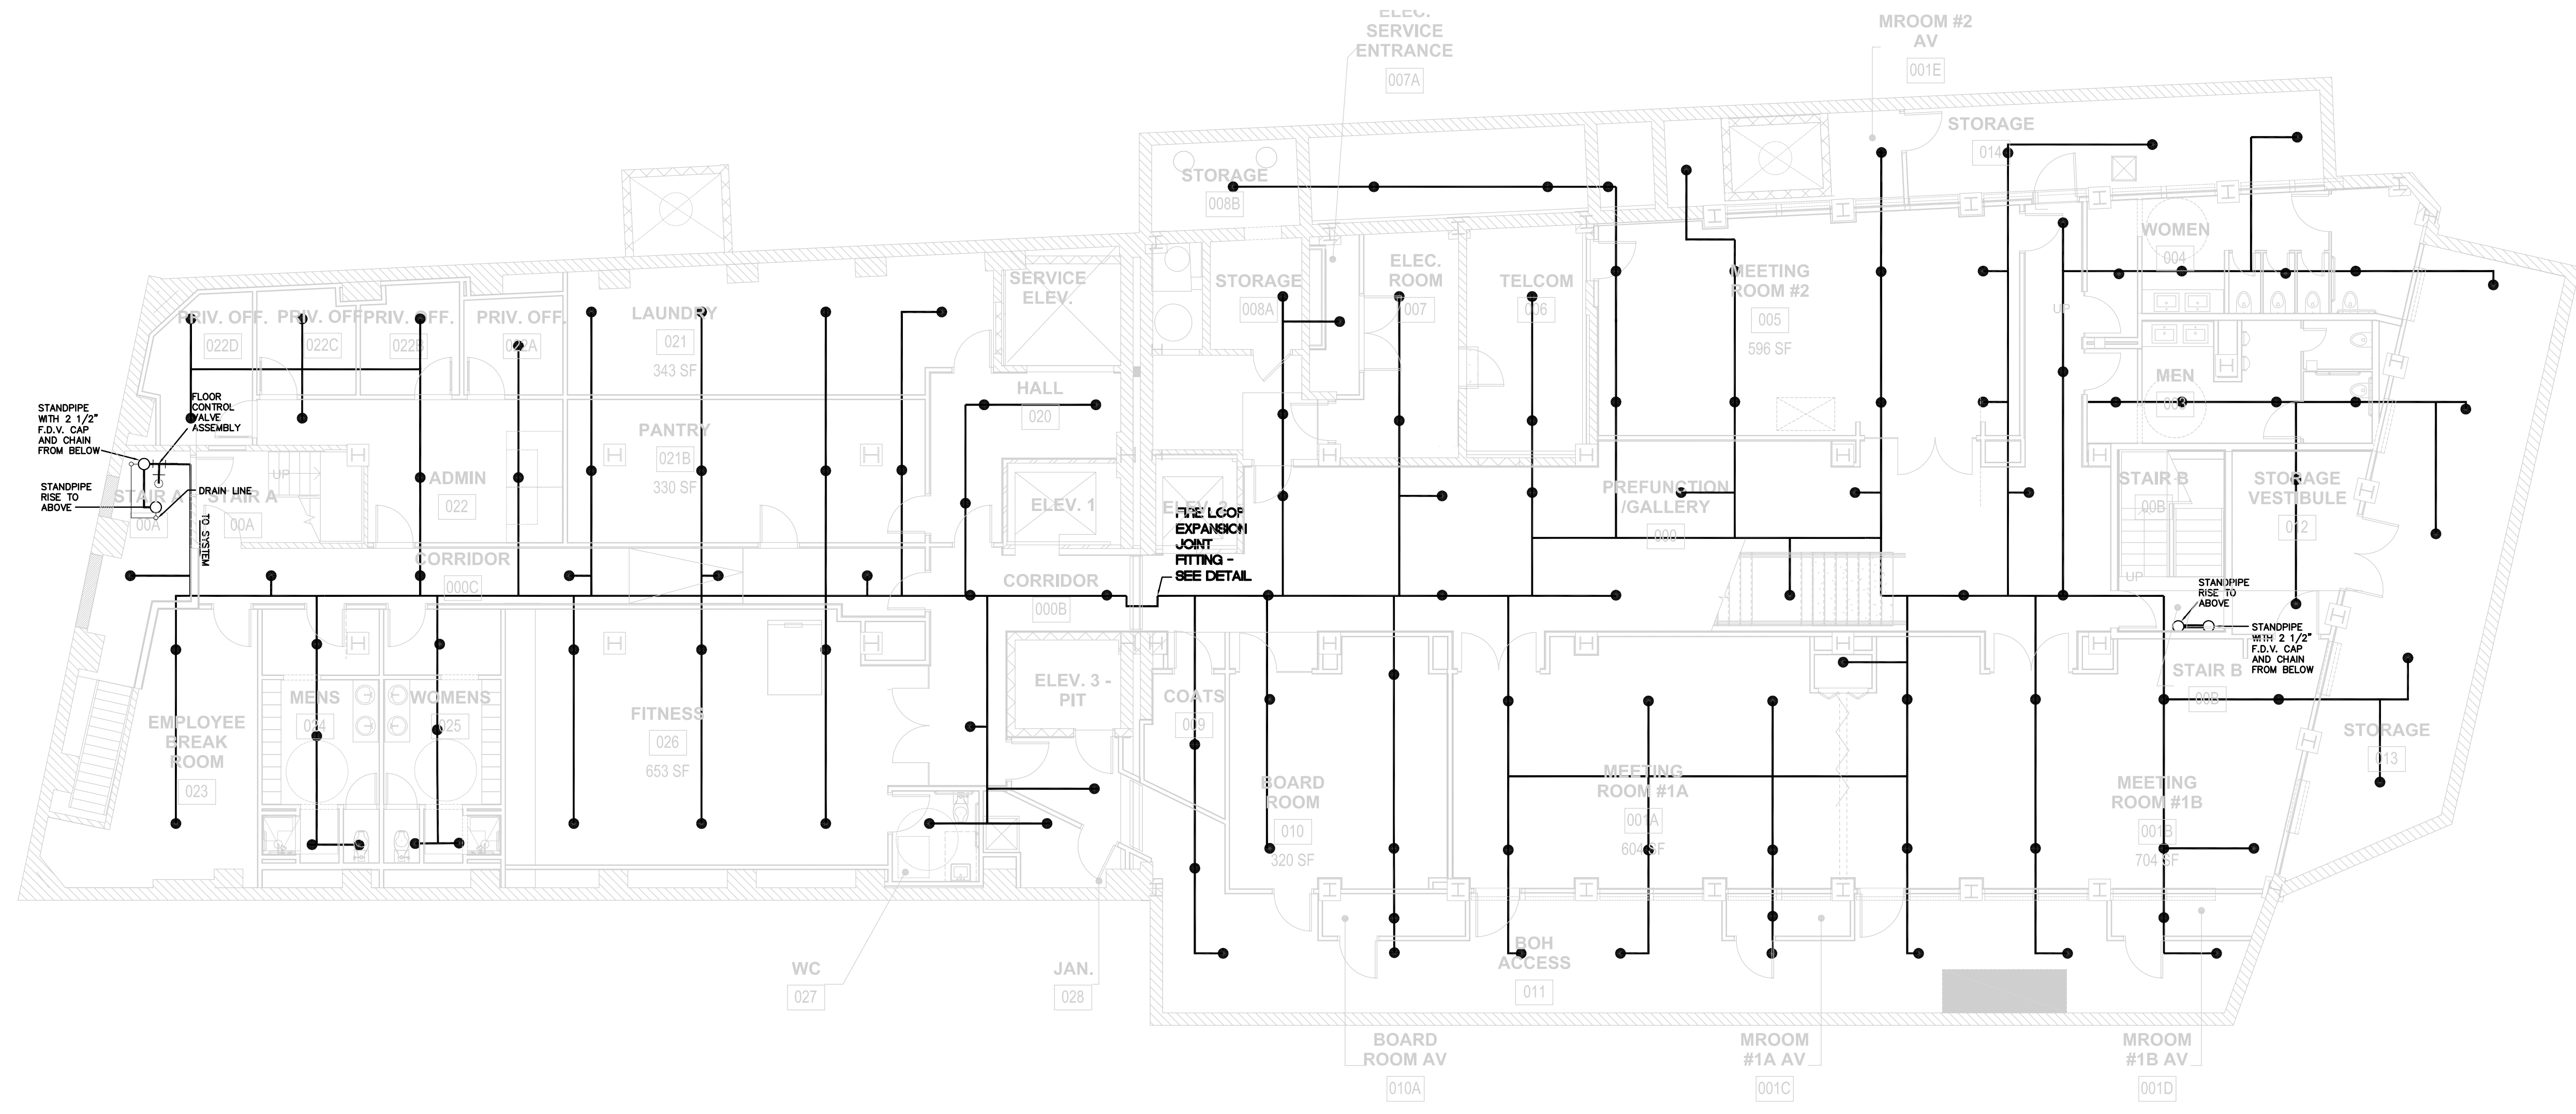

SPRINKLER LEGEND:

●	SEMI-RECESSED Q.R. WHITE PENDANT HEAD.
▼	SIDEWALL Q.R. WHITE HEAD.
▼ <sub>212</sub>	SIDEWALL Q.R. EXTENDED COVERAGE WHITE HEAD.

**1** LOWER LEVEL PLAN - FIRE SPRINKLER  
 SCALE: 1/8"=1'-0"

