

Prepared For:
119 Development, LLC

Consultant:
 Crabtree Engineering
 278 Amelia Cove
 Collierville, Tennessee 38017
 majidatanzadeh@yahoo.com


Architect:
ARCHITECTS
 Architects
 48 Union Wharf Portland, Maine 04101
 (207) 772-6022 Fax (207) 772-4056

Project:
PRESS HOTEL
 390 CONGRESS STREET
 PORTLAND, ME 04101

Revisions:
 1 | 13_07-01 | 30% Marriott Submission
 2 | 13_09-09 | 60% Marriott Sub. & Pric.
 3 | 13_10-14 | Issue for Bld & Marriott Revw

Date: 08 OCT 13
 Scale: 1/8" = 1'-0"
**FIRST FLOOR PLAN
 FIRE SPRINKLER
 PLAN**

F1.00

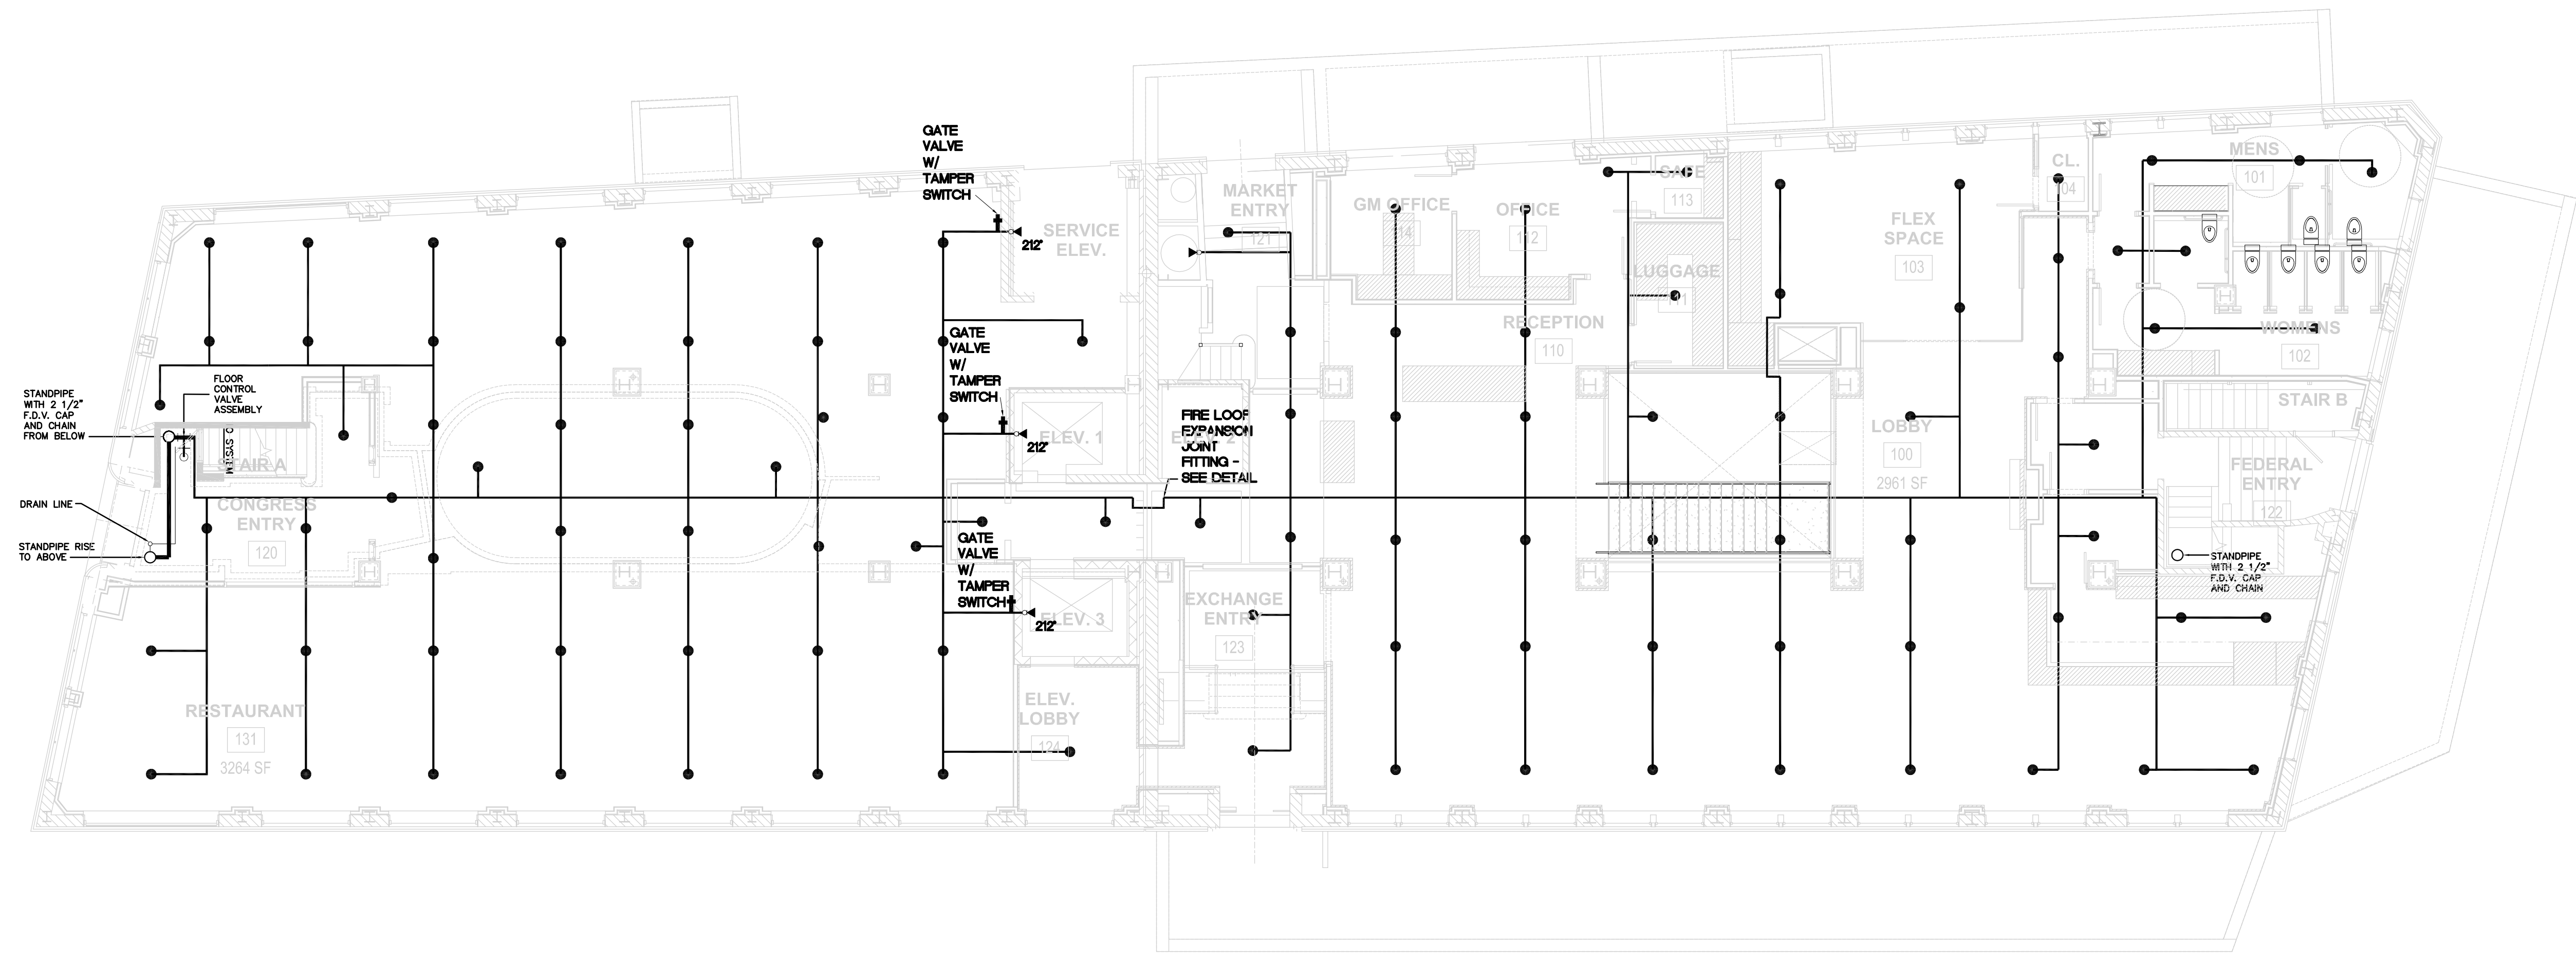

SPRINKLER LEGEND:	
●	SEMI-RECESSED Q.R. WHITE PENDANT HEAD.
▼	SIDEWALL Q.R. WHITE HEAD.
▼ ₂₁₂	SIDEWALL Q.R. EXTENDED COVERAGE WHITE HEAD.

1 | FIRST FLOOR PLAN - FIRE SPRINKLER
 SCALE: 1/8"=1'-0"

